


SECOND FLOOR PLAN  
SCALE 1/8" = 1'-0"

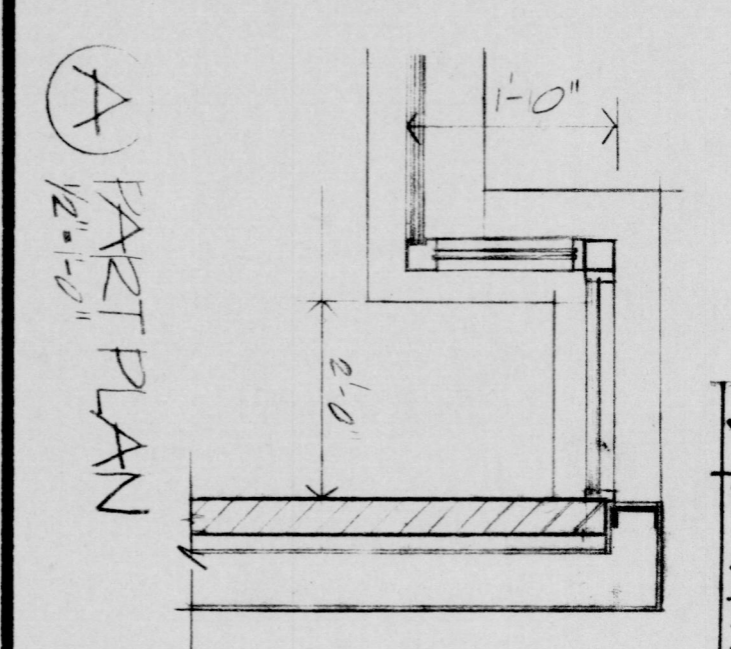

NOTE:  
1 PROVIDE 4" x 4" W/WR IN WALK-IN REFRIG.  
2 ALCOHOLIC FIRE NFD.

FINISH SCHEDULE LEGEND

NO.	DATE	DESCRIPTION	REVISIONS
1	8/14/10	REVISED PER A-7	REVISED
2	7/31/09	REVISED PER A-7	REVISED
3	1/31/09	REVISED	REVISED

NO.	DATE	DESCRIPTION	REVISIONS
1	8/14/10	REVISED PER A-7	REVISED
2	7/31/09	REVISED PER A-7	REVISED
3	1/31/09	REVISED	REVISED

NOTE:  
SEE GENERAL NOTES ON SMT A-6

Henry Adams, Inc.  
Mech./Elect. Engineers

Faisant Associates, Inc.  
Structural Engineers

Gaudreau, Inc.  
Architects Partners Engineers  
Baltimore  
810 Light Street, Baltimore, Maryland 21202

CORPORATE HEADQUARTERS  
**McCormick & Company**  
LOVETON BUSINESS CENTER  
BALTIMORE COUNTY, MARYLAND

KEY PLAN

BID PACK # 3

SECOND FLOOR PLAN  
PROJ. NO. DWG. NO.  
8914.10  
DATE  
04-1-90  
A-7