

- SPECIAL NOTES: (APPLICABLE TO DRAWING E-10)**
- 1 DOWN. SEE DRAWING E-9.
 - 2 1, 3 (LP-44).
 - 3 MOUNT 7" A.F.F.
 - 4 2, 4 (LP-44).
 - 5 SEE DETAIL 9/E-12 FOR BACK LIGHTING OF STAINED GLASS DOME.
 - 6 CONNECT TO NEAREST 20A, 120V, 1Ø CIRCUIT IN THIS AREA.
 - 7 SEE ARCHITECTURAL DETAIL 3A/A-42 FOR FIXTURE MOUNTING.
 - 8 SEE DETAIL 11/E-13 FOR EQUIPMENT LOCATION IN THIS ROOM.

MEZZANINE FLOOR PLAN - LIGHTING
SCALE: 1/8" = 1'-0"

ROOM NUMBER	ROOM NAME
4000	LOBBY
4001	FUTURE OFFICE
4002	ELECT. ROOM
4003	ELECT. ROOM
4004	WOMEN
4005	WOMEN
4006	ELEV. MACH.
4007	RELV. ROOM
4008	RELV. ROOM
4009	RELV. ROOM
4010	RELV. ROOM
4011	RELV. ROOM
4012	RELV. ROOM
4013	CORRIDOR


Henry Adams, Inc.
Mech./Elect. Engineers

Faisant Associates, Inc.
Structural Engineers

Gaudreau, Inc.
Architects/Interior Designers

Baltimore
610 Light Street, Baltimore, Maryland 21201

CORPORATE HEADQUARTERS
McCormick & Company
LOVETON BUSINESS CENTER
BALTIMORE COUNTY, MARYLAND

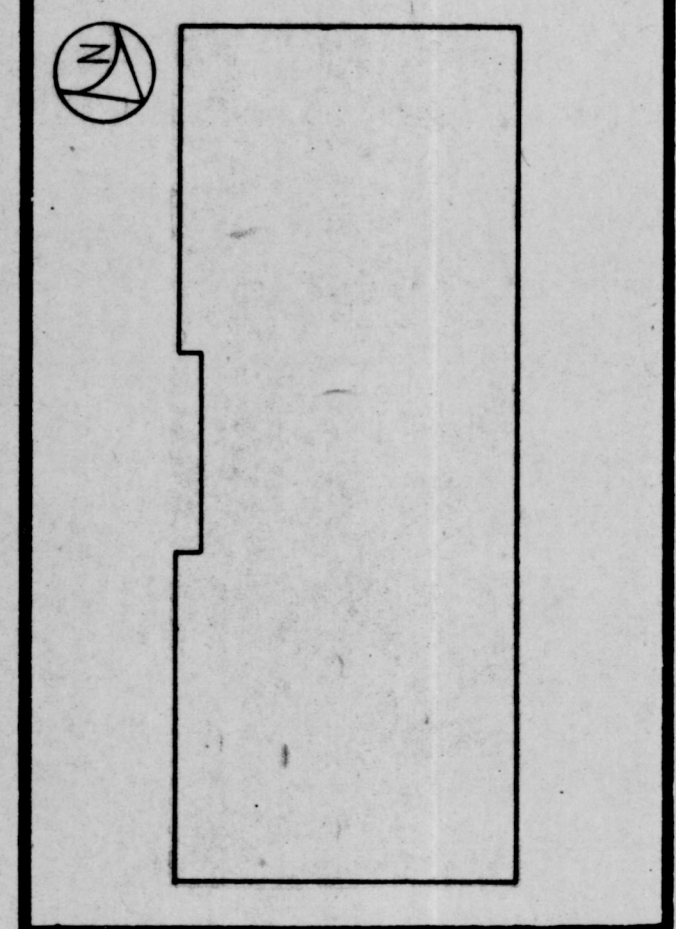

REVISIONS	
NO.	DESCRIPTION
1	6-17-79 CONSTRUCTION SET

PROJ. NO.	8914.10
DWG. NO.	E-10
DATE	4/11/80