

Electrical Legend

| | | | |
|------|--|-----|--|
| ⊕ | DUPLEX WALL OUTLET | S | WALL SWITCH |
| ⊕GFI | GFI RATED DUPLEX WALL OUTLET | Sm | MOTION ACTIVATED WALL SWITCH |
| ⊕ | QUADRAPLEX WALL OUTLET | S3 | 3 WAY WALL SWITCH |
| ⊕GFI | GFI RATED QUADRAPLEX WALL OUTLET | Sd | DOOR MOUNTED LIGHT SWITCH |
| ■ | JUNCTION BOX FOR OWNER SELECTED FIXTURE | Sm3 | MOTION ACTIVATED 3 WAY WALL SWITCH |
| SD | SMOKE DETECTOR PER CODE INCLUDE ATTIC SPACE PER CODE | ■CM | CEILING MOUNTED JUNCTION BOX |
| CO | CO2 DETECTOR PER CODE INCLUDE ATTIC SPACE PER CODE | | |
| ⊞ | ELECTRIC PANEL | | OUTLETS WITH A 'GFI' DESIGNATION NEXT TO THEM ARE GROUND FAULT INTERRUPTER CIRCUITS. |
| ⊙ | RECESSED DOWNLIGHT | | OUTLETS WITH A 'WP' DESIGNATION NEXT TO THEM ARE WEATHERPROOF OUTLET WITH COVERS. |
| ⊕ | 220 V OUTLET FOR WASHING MACHINE MOUNT 42" AFF | | ALL OTHER OUTLETS SHALL BE MOUNTED AT 18" ABOVE FINISHED FLOOR, UNLESS NOTED OTHERWISE. |
| ⊕ | DRYER OUTLET MOUNT 42" AFF | | TELEPHONE OUTLETS SHALL HAVE A 1/2" CONDUIT WITH FULL WIRE RUN FROM THE OUTLET BOX TO A JUNCTION BOX LOCATED 6" ABOVE THE CEILING. |
| ⊕ | OWNER SUPPLIED DOORBELL EXTERIOR RATED | | |



ARCHITECTS


9738 Briarcliffe Lane · Ellicott City, Maryland 21042
410.730.4300 Fax 410.988.2174 E-Mail JPCArchitects@verizon.net

Professional Certification:
I certify that these documents were prepared and approved by me, and that I am a duly licensed Architect under the laws of the State of Maryland, License Number #5297-A, Expiration Date: 06/27/2021



Professional Seal and Signature

Proposed Home Plans

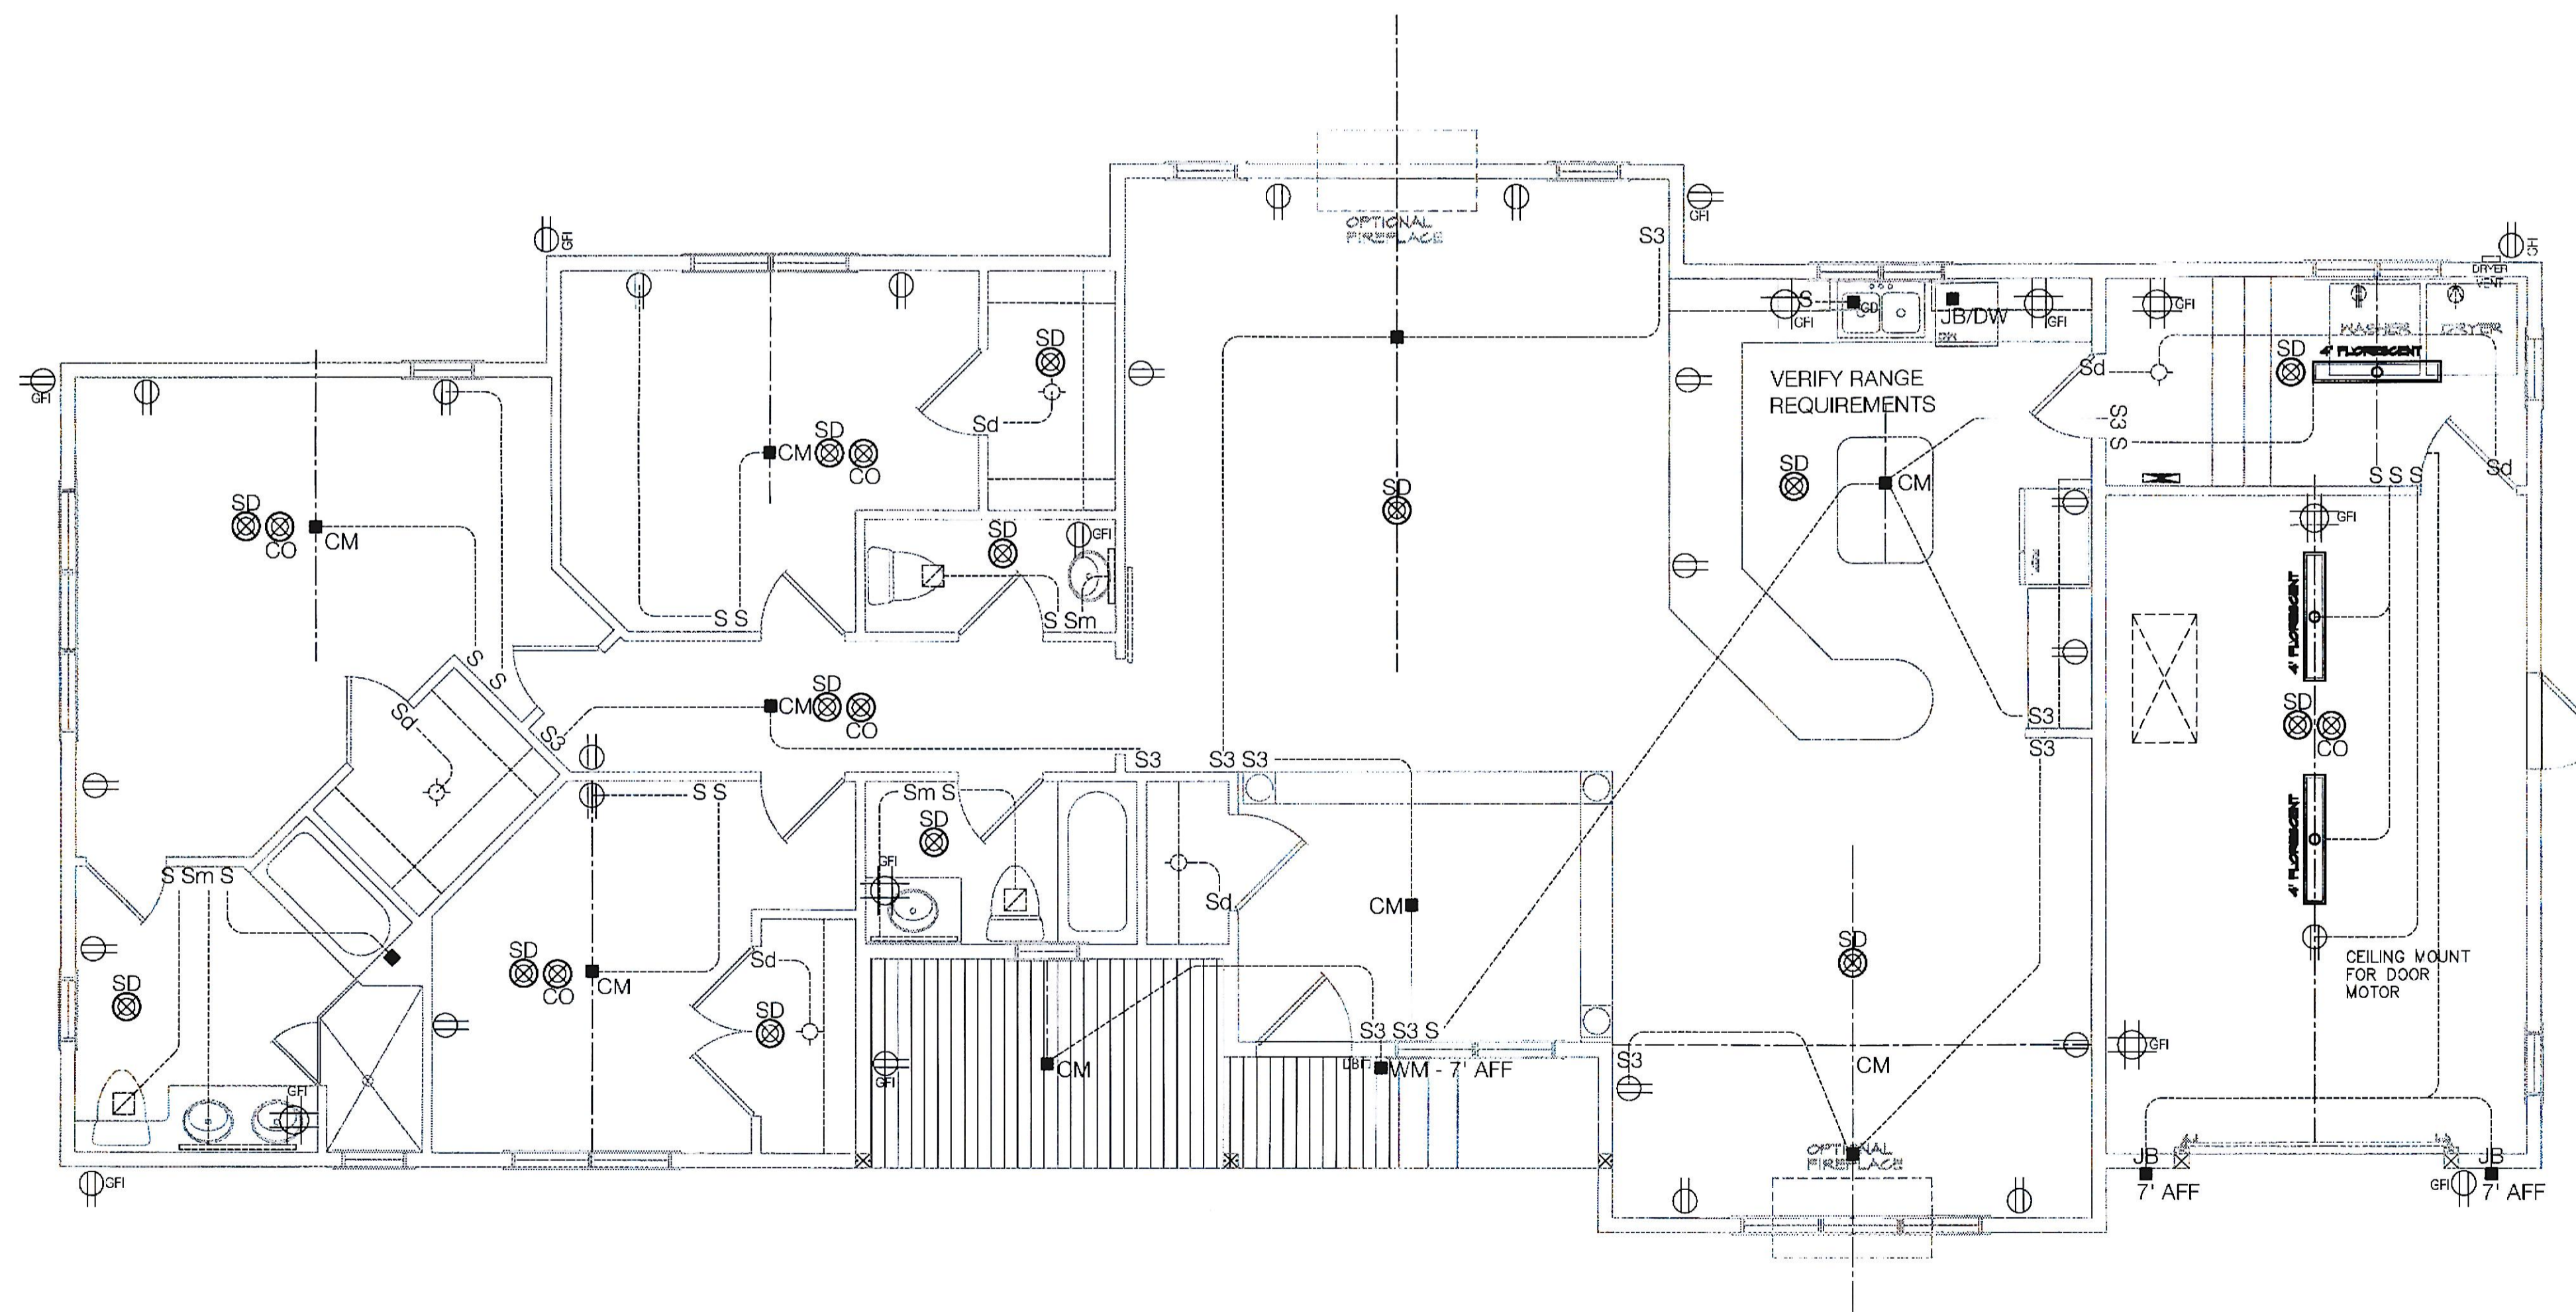

1721 Lake Avenue
Shady Side, Maryland 20764

| Revisions | | |
|-----------|-------------|------|
| Number | Description | Date |
| | | |
| | | |
| | | |
| | | |
| | | |

Sheet Title:
FIRST FLOOR ELECTRICAL PLAN

Scale: 1/4" = 1'-0"
Date: DECEMBER 1, 2019
Project Number: 2019.42
Drawn By: JPC
Sheet Number:

FIRST FLOOR ELECTRICAL PLAN
SCALE: 1/4" = 1'-0"

E.1