


- GENERAL NOTES**
1. CONCEAL ALL PIPING ABV. G.W.B. CEILING BETWEEN JOISTS WHERE POSSIBLE
  2. SEE ARCH. REFLECTED CEILING PLAN FOR EXACT DUCT & AIR DEVICE LOCATIONS

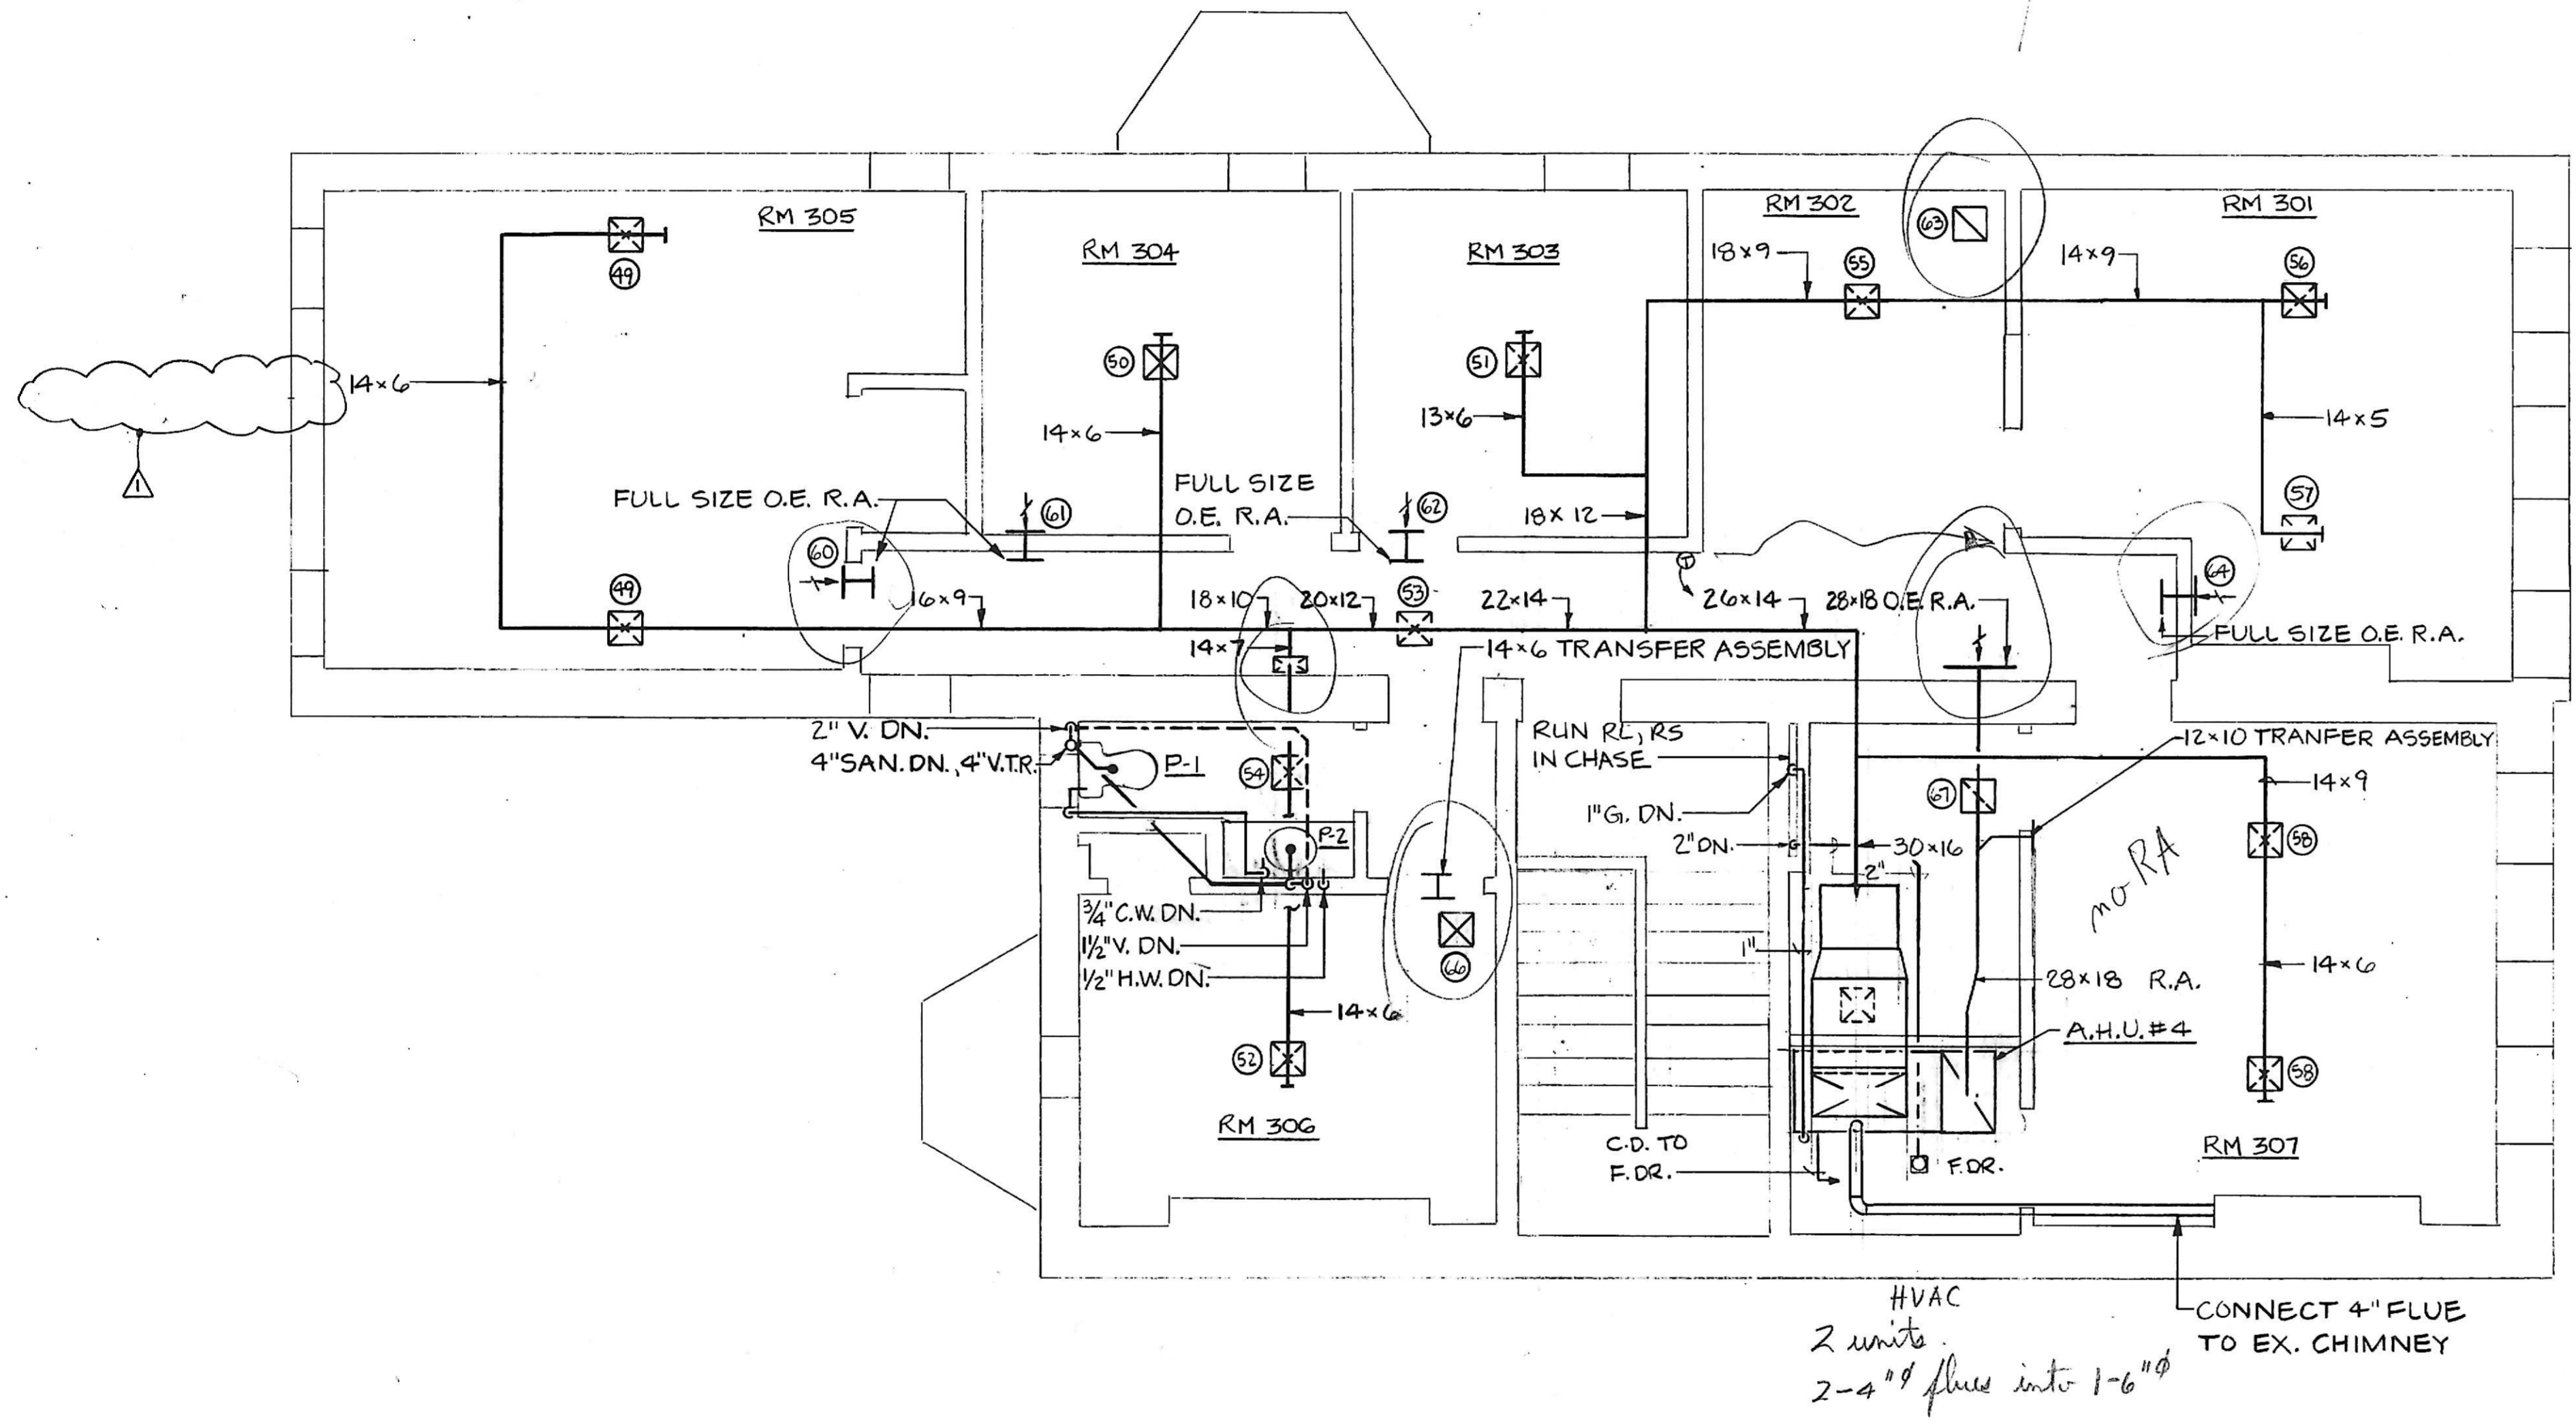

**DEMOLITION NOTES**

REMOVE EXISTING PLUMBING SYSTEM IN ITS ENTIRETY. TURN OVER SALVAGABLE FIXTURES & PIPING TO OWNER. REMOVE ENTIRE HEATING SYSTEM IN ITS ENTIRETY WITH THE EXCEPTION OF THE EXISTING FLUE. PATCH ALL HOLES IN SURFACES & STRUCTURE TO SATISFACTION OF ENGINEER.

**THIRD FLOOR PLAN**  
SCALE: 1/4" = 1'-0"

NO.	DATE	DESCRIPTION

**Cho Wilks & Benn**  
316 North Charles Street  
Baltimore, Maryland 21201  
(301) 576-0440  
ARCHITECTS

**MARYLAND INSTITUTE**

DRAWN BY: J.D. CHECKED BY: K.K.

**THIRD FLOOR PLAN**  
Contract Dwg.

PROJECT NO.: 1710	SHEET NO.: M-4
SCALE: AS NOTED	
DATE: 10-27-88	
LATEST REV: 8-11-89	