




SANITARY RISER DIAGRAM
NOT TO SCALE

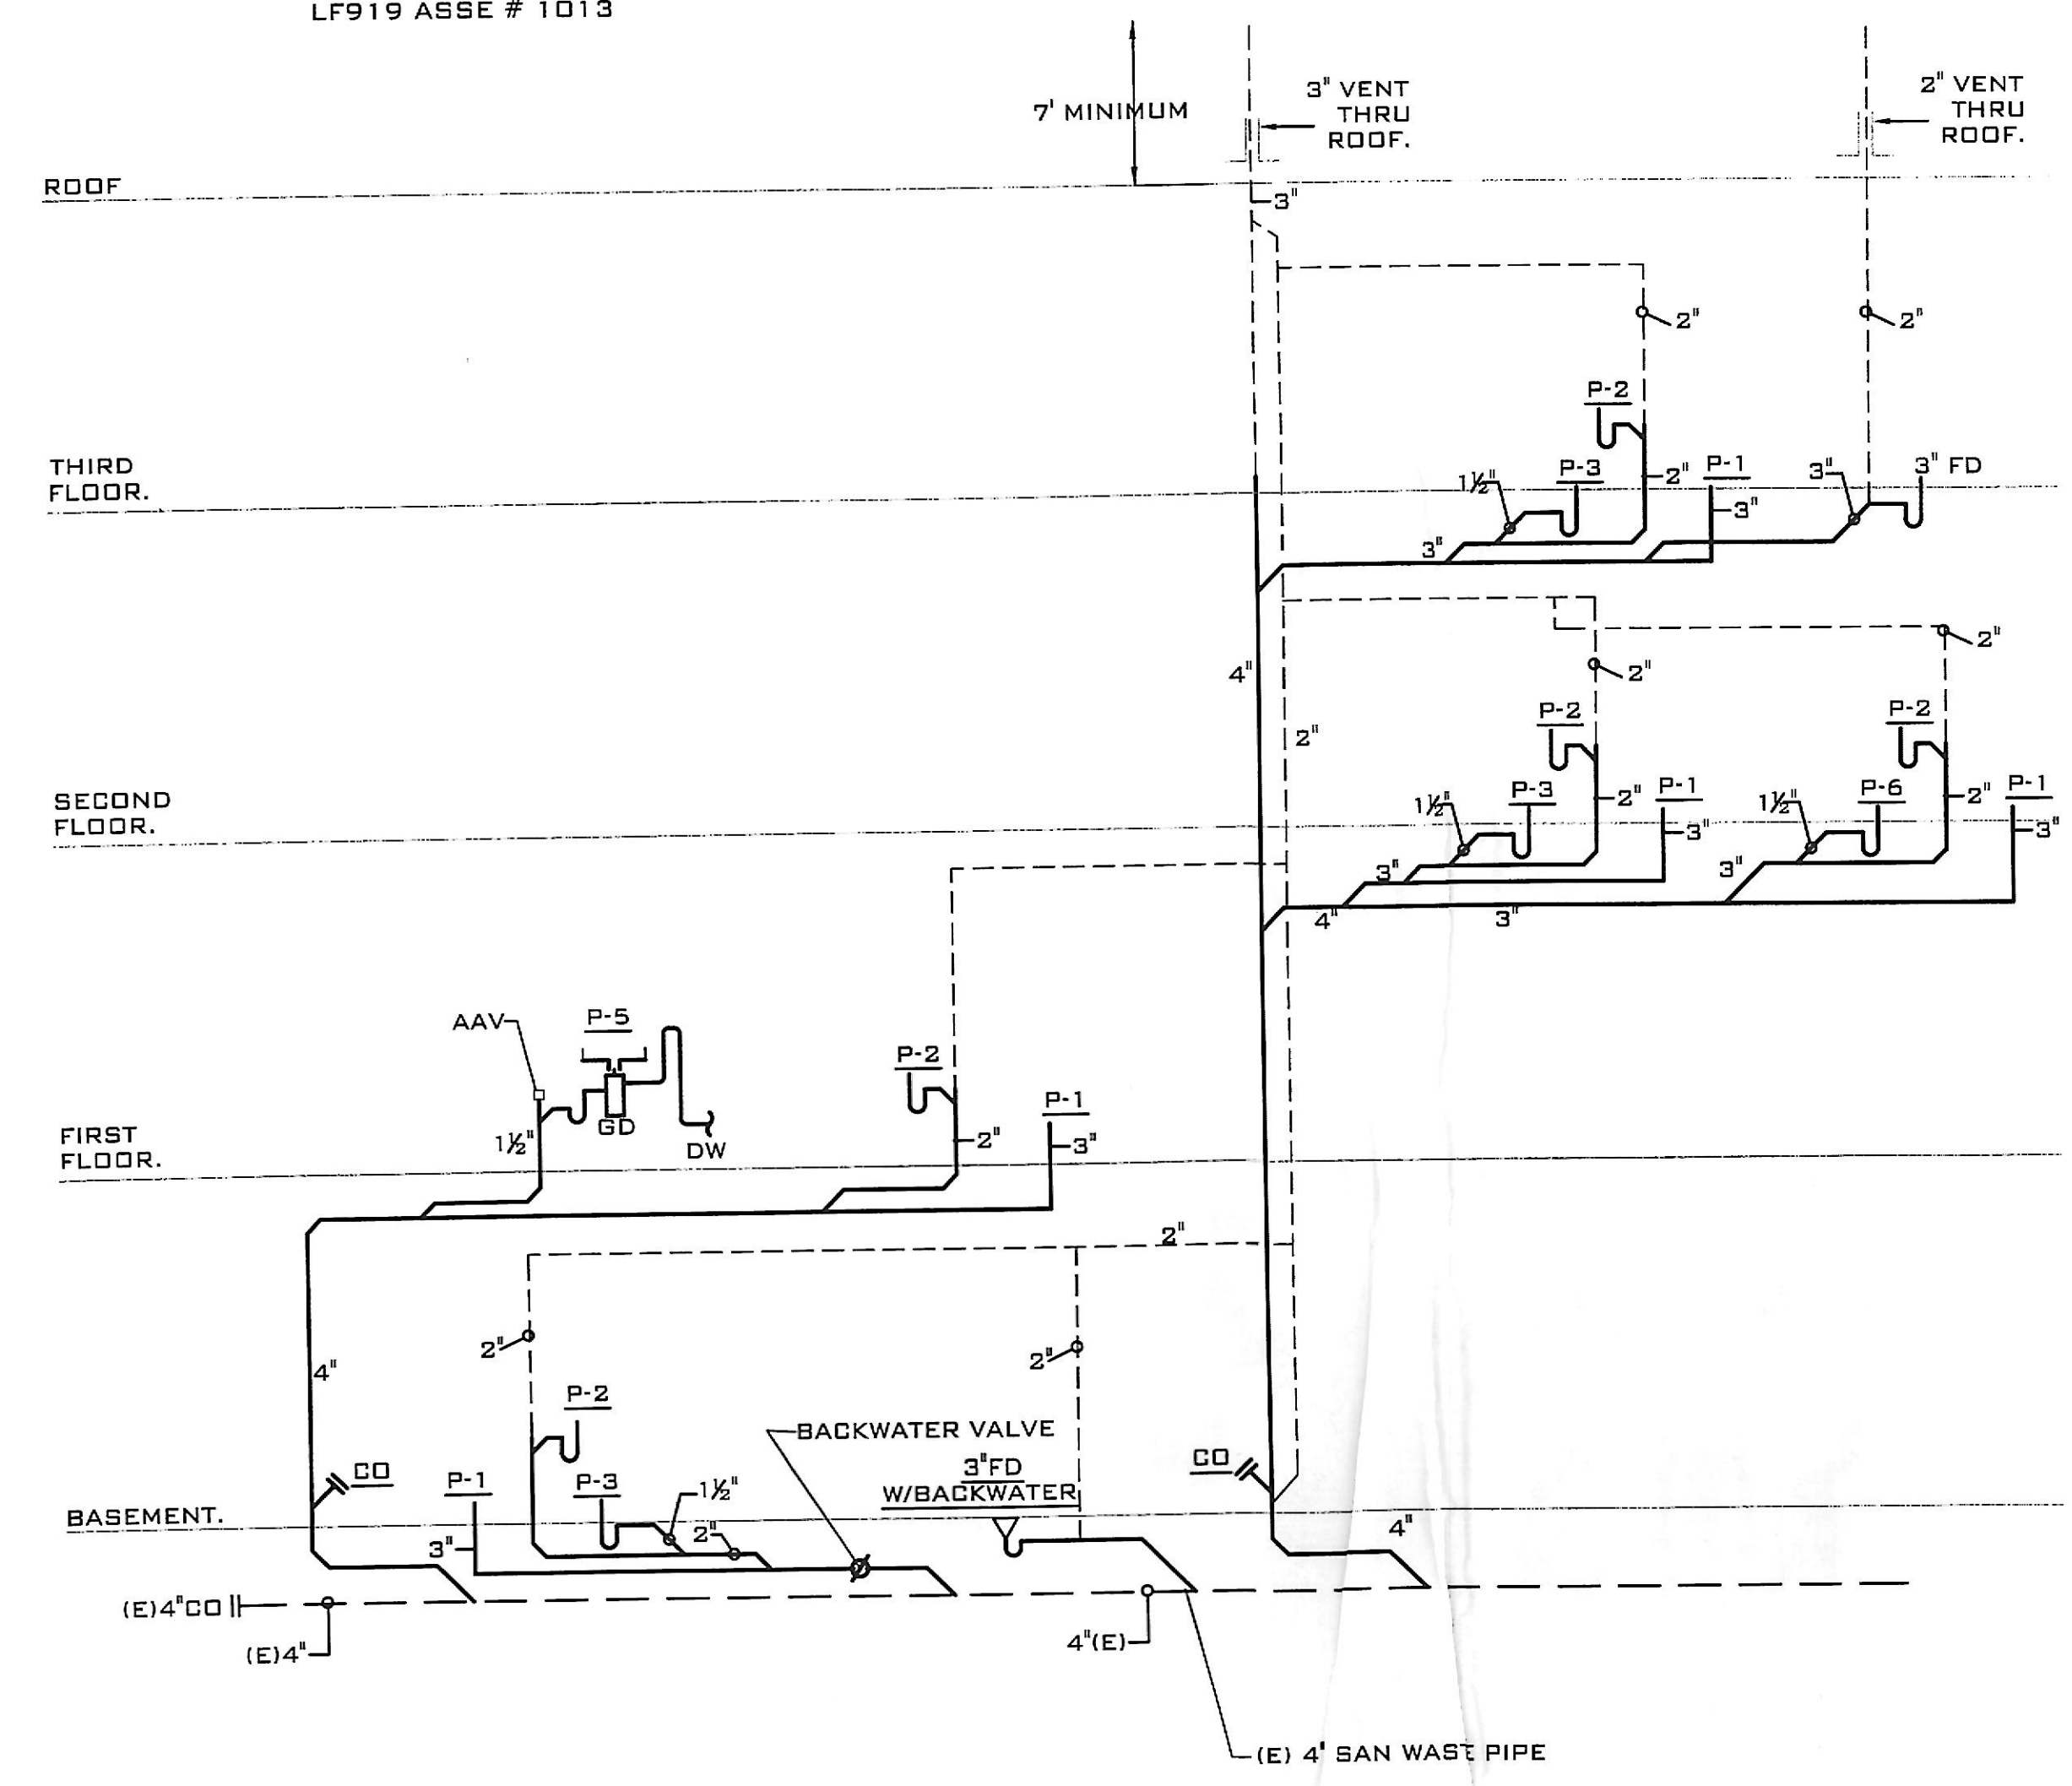


GAS RISER DIAGRAM
NOT TO SCALE

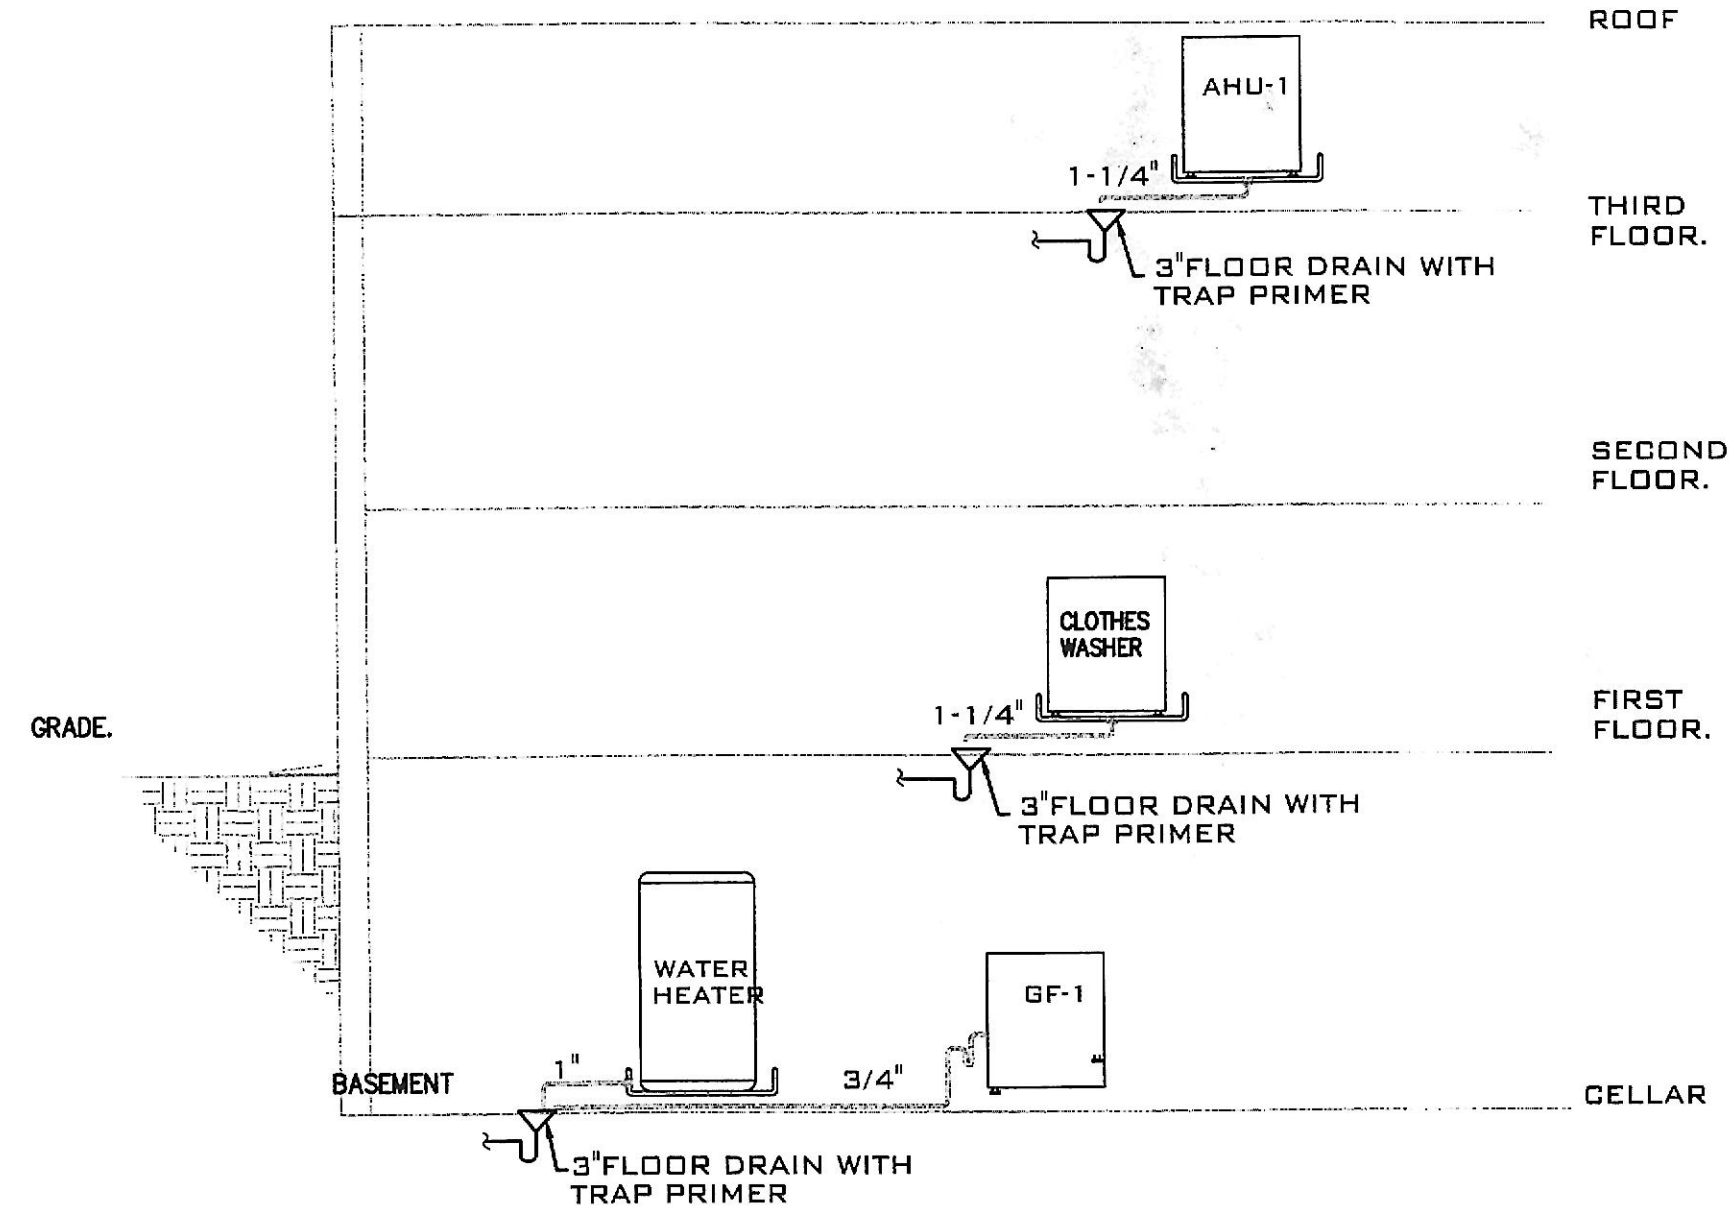

CONDENSATED AND SAFETY DRAINS RISER DIAGRAM
NOT TO SCALE

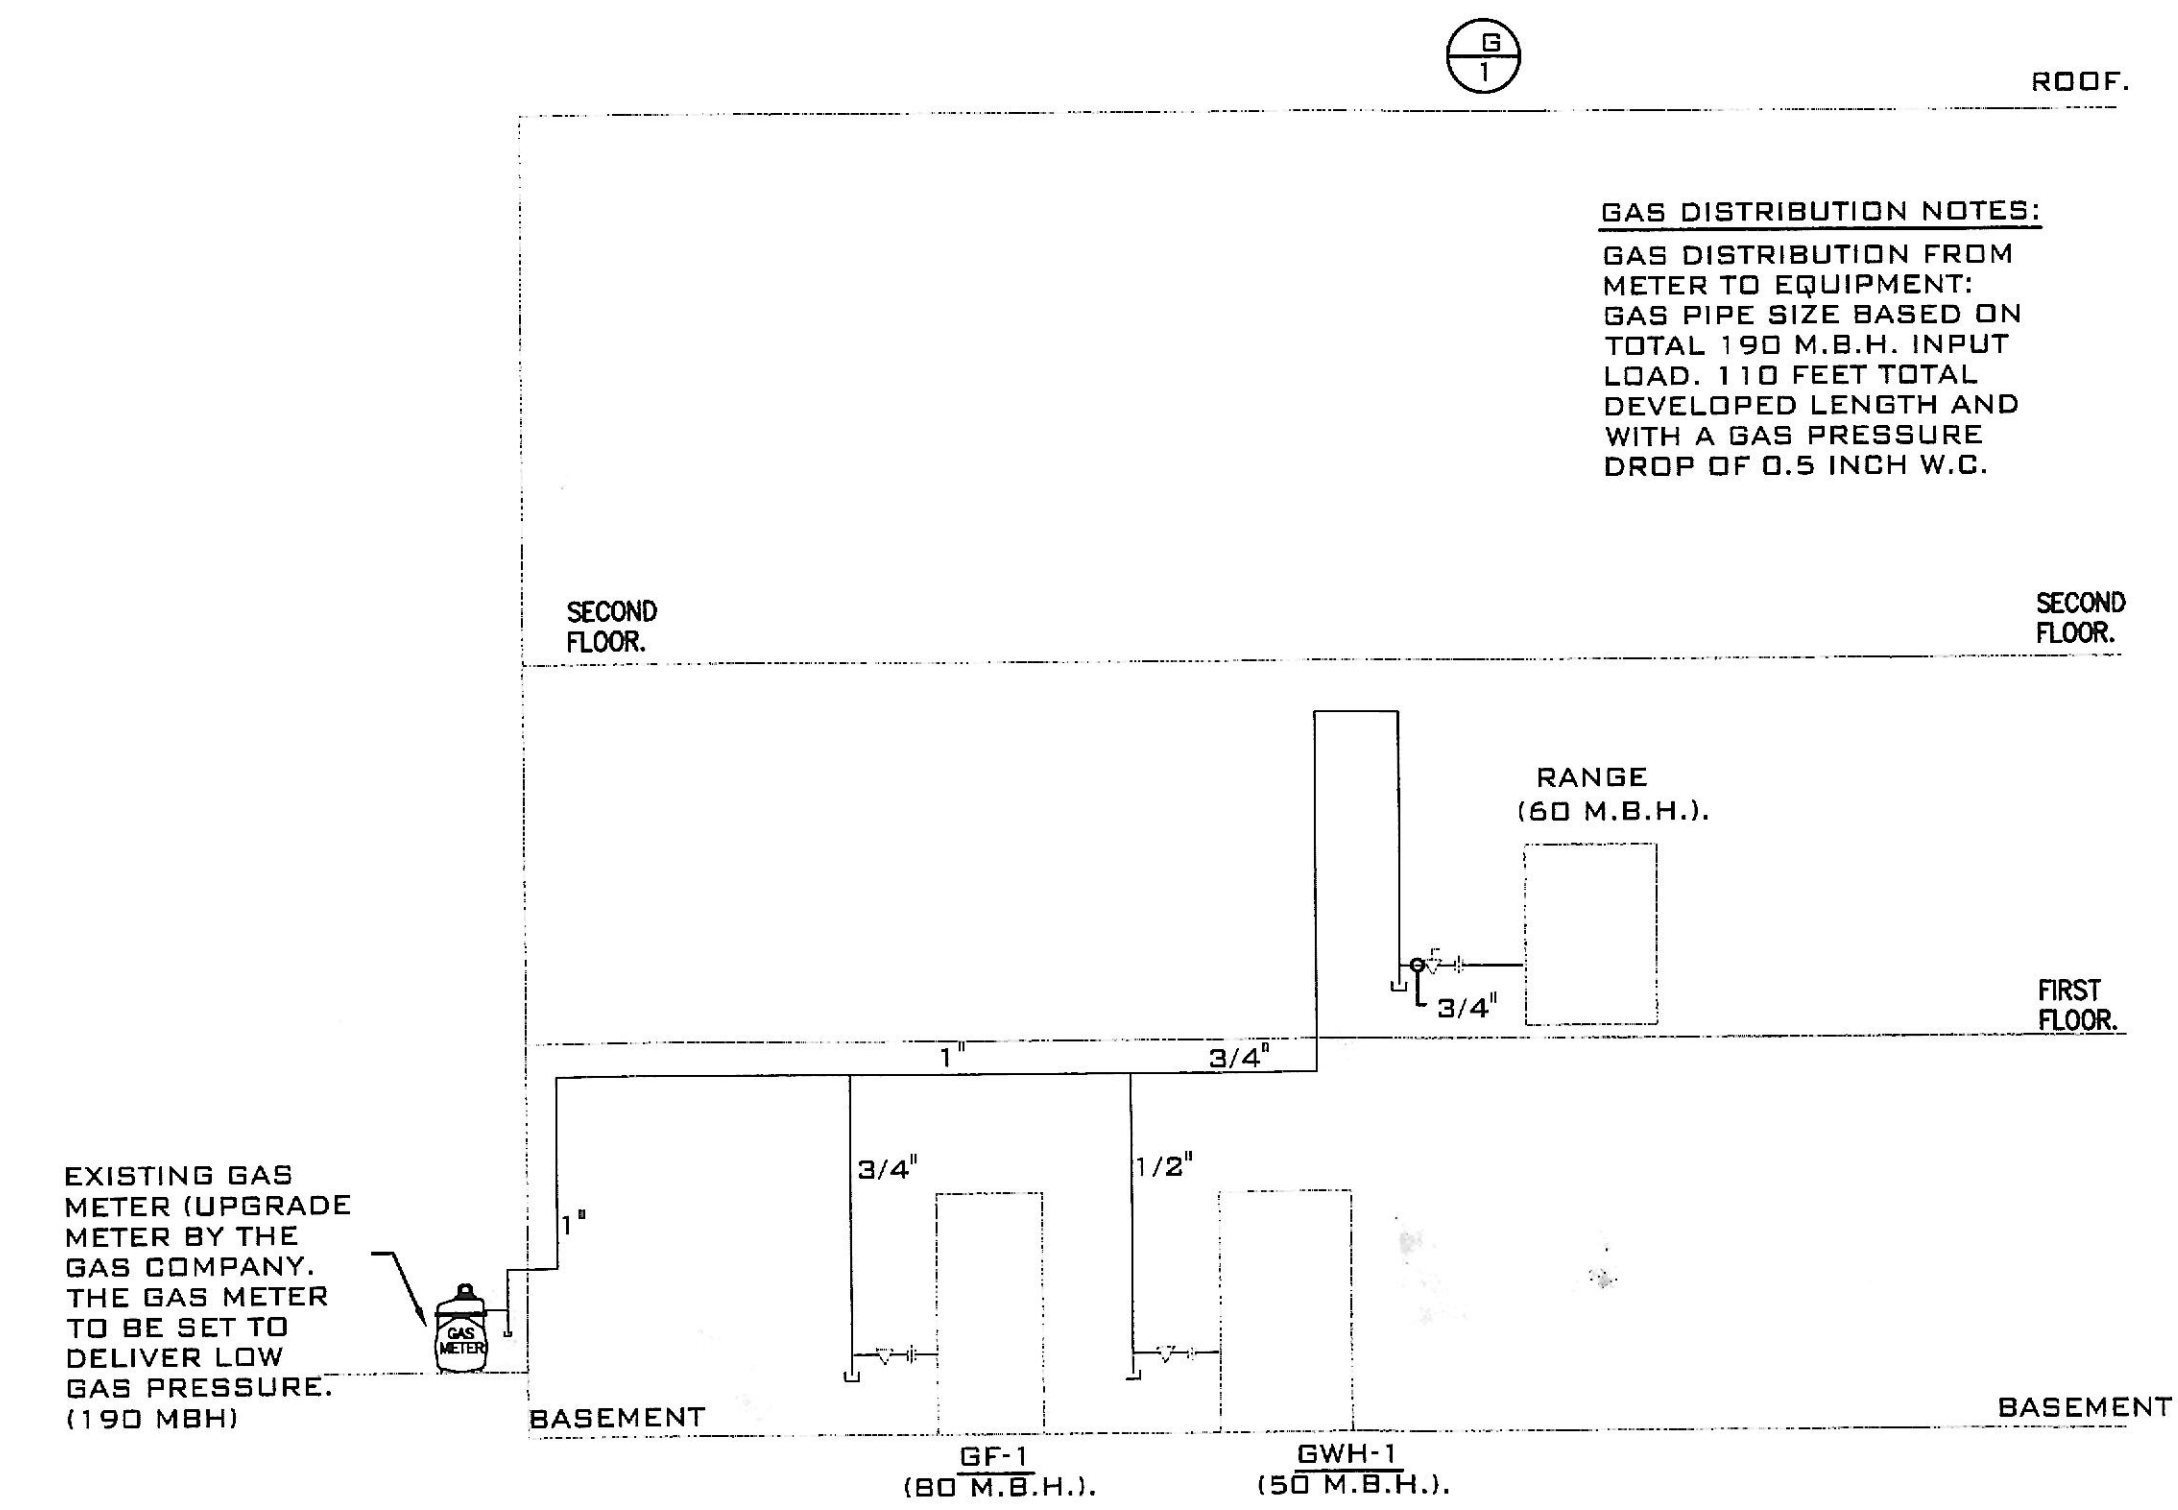


GAS DISTRIBUTION NOTES:
GAS DISTRIBUTION FROM METER TO EQUIPMENT:
GAS PIPE SIZE BASED ON TOTAL 190 M.B.H. INPUT LOAD. 110 FEET TOTAL DEVELOPED LENGTH AND WITH A GAS PRESSURE DROP OF 0.5 INCH W.C.

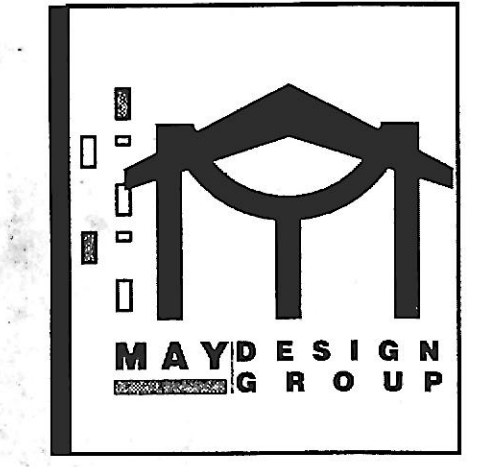

4015 WOODLEA AVE
BALTIMORE, 21206 MD
SQ: 6,996 LOT: 016

PROFESSIONAL CERTIFICATION:
I HEREBY CERTIFY THAT THESE DOCUMENTS WERE PREPARED AND APPROVED BY ME, AND THAT I AM A DULY LICENSED PROFESSIONAL ENGINEER UNDER LAWS OF THE STATE OF MARYLAND.
LICENSE NO: 43013 EXPIRATION DATE: 12-11-2020

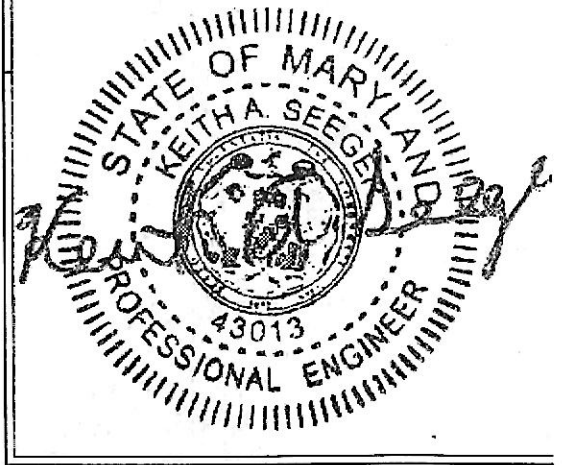

SCALE: AS NOTED
DATE:
PROJECT NUMBER:

RISER DIAGRAMS

P200

