

GENERAL NOTES: ROOF

- A. MAINTAIN ALL MANUFACTURER'S CLEARANCES ON ALL EQUIPMENT.
- B. SPILL UNIT CONDENSATE TO NEAREST ROOF DRAIN. SIZE CONDENSATE PIPE PER MANUFACTURER'S RECOMMENDATIONS.
- C. REFER TO SHEETS M403 AND M404 FOR ROOFTOP UNIT DETAILS.

KEYNOTES

- M3 ROUTE THE REFRIGERANT PIPING DOWN THROUGH A NEW ROOF CURB/PIPING PORTAL. PROVIDE A ROOF PRODUCTS MODEL RPPC-90 ROOF CURB WITH PIPE CHASE. REFER TO THE PIPE PORTAL DETAIL ON SHEET M602 FOR ADDITIONAL INFORMATION. ROOF CURB SHALL BE 3'-0" AWAY FROM CONDENSING UNIT. REFRIGERANT PIPING SHALL BE SUPPORTED BY COOPER B-LINE C-SERIES ROOFTOP SUPPORTS.
- M4 CONDENSING UNIT MOUNTED ON A ROOF CURB. REFER TO DETAIL ON SHEET M602.
- M5 PROVIDE DUCT SUPPORTS 5'-0" ON CENTER. DUCT SUPPORTS SHALL BE COOPER, B-LINE, MODEL C-SERIES OR EQUAL.
- M7 TERMINATE UNIT EXHAUST AT LEAST 25'-0" FROM ANY UNITS' OUTSIDE AIR INTAKE. PROVIDE DUCT WITH EPOXY WEATHER COATING AND 1/2" MESH SCREEN.
- M8 ROOF HYDRANT; REFERENCE PLUMBING DRAWINGS FOR ADDITIONAL DETAIL.
- M9 DUCTWORK DOWN TO FLOOR BELOW. REFER TO SHEET M121 FOR CONTINUATION.
- M13 DUCTWORK DOWN TO FLOOR BELOW. REFER TO SHEET M124 FOR CONTINUATION.

VMDO

VMDO Architects
210 E. Main Street
Charlottesville, VA 22902
181-986-5881
vmdo.com




10411 Meeting Street
Prospect, Kentucky 40099
502.226.2065 • F 502.226.2691
www.cmtaengr.com




Catholic Diocese of Arlington
I encourage and track your faith journey

PAUL VI CATHOLIC HIGH SCHOOL

CATHOLIC DIOCESE OF ARLINGTON
200 North Glebe Road
Arlington, VA 22203
Loudoun County ZCPA Number 2016-0005
VMDO Project Number 15.1188

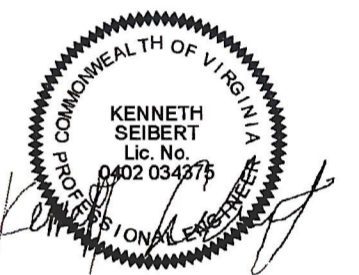



Checked By DRH
Drawn By CMG

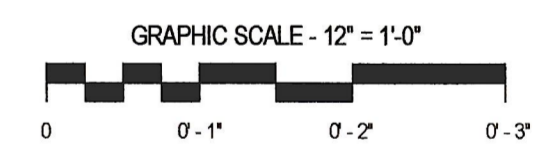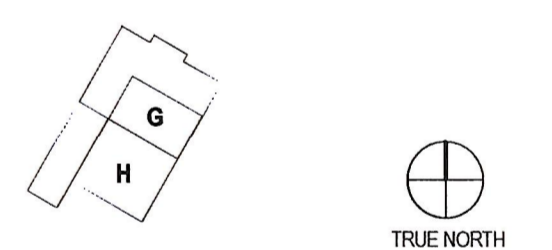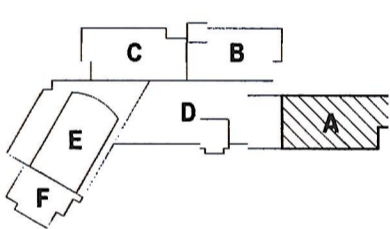

ISSUES AND REVISIONS	DATE
NO. SUBMITTAL	

ROOF PLAN - AREA A - MECHANICAL

M301

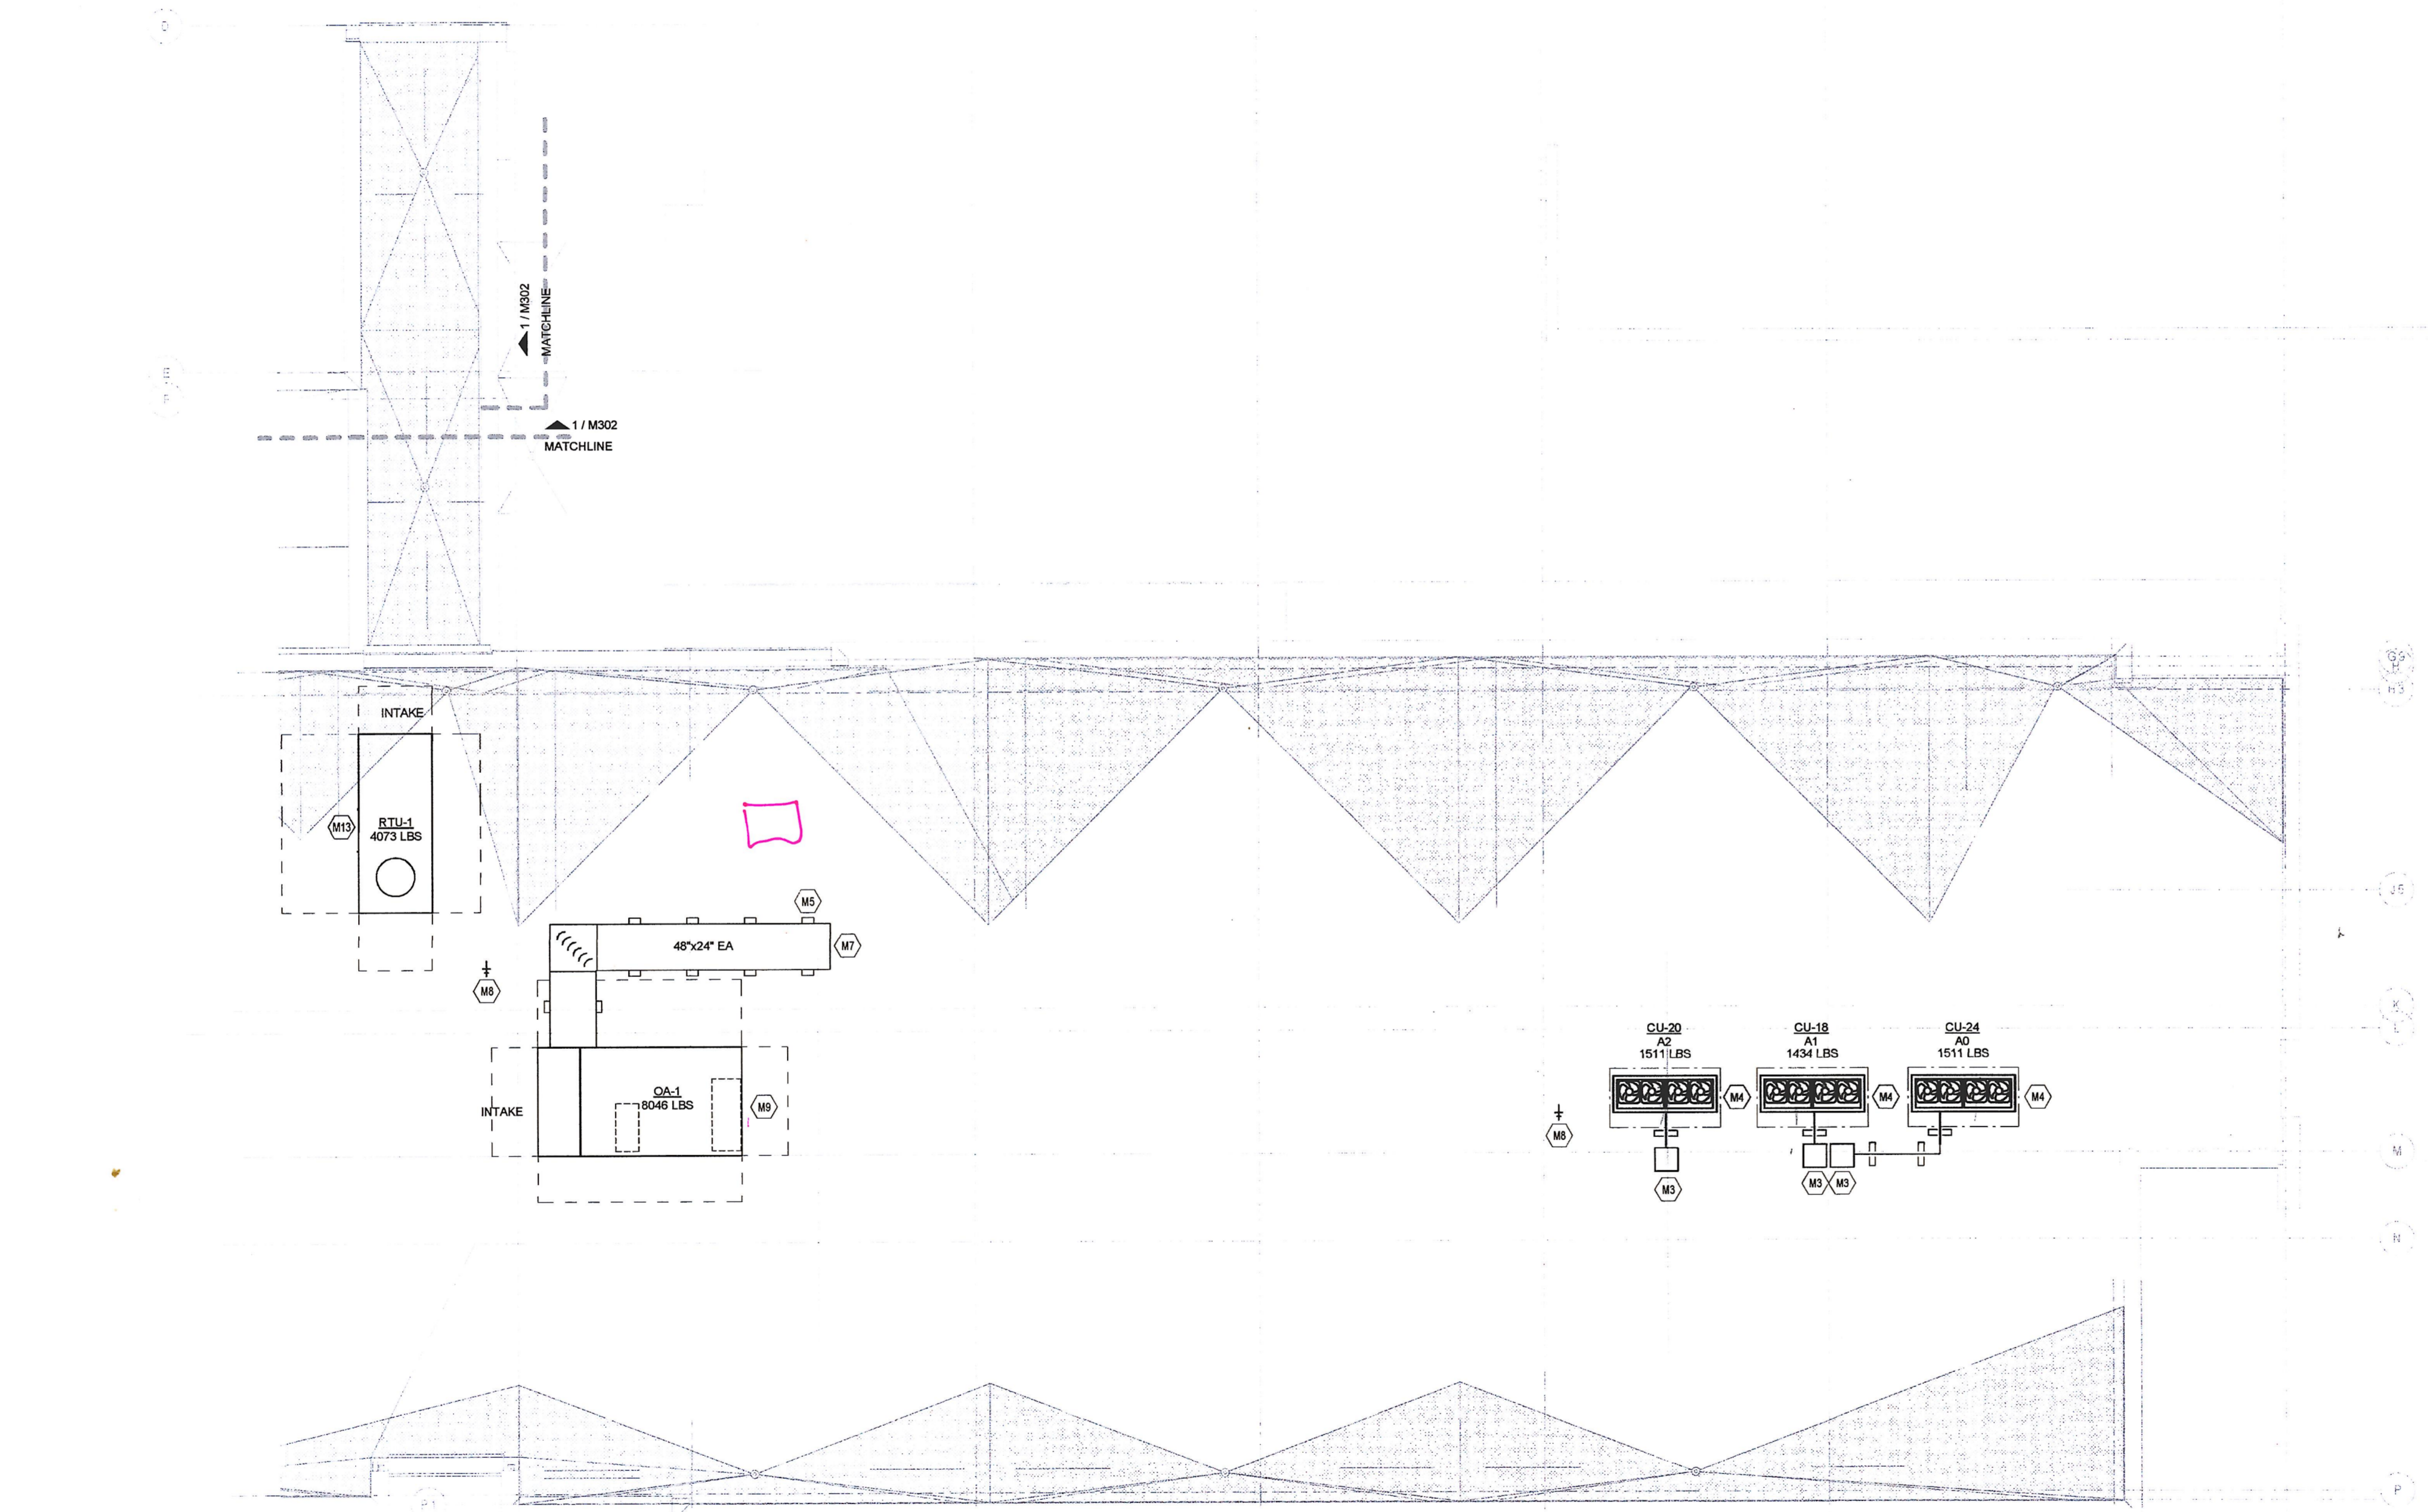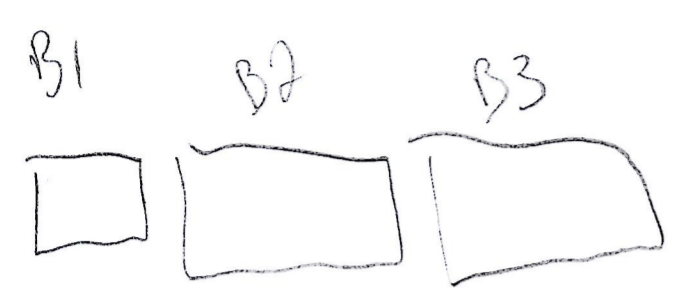

1 ROOF - MECHANICAL - AREA A
1/8" = 1'-0"