
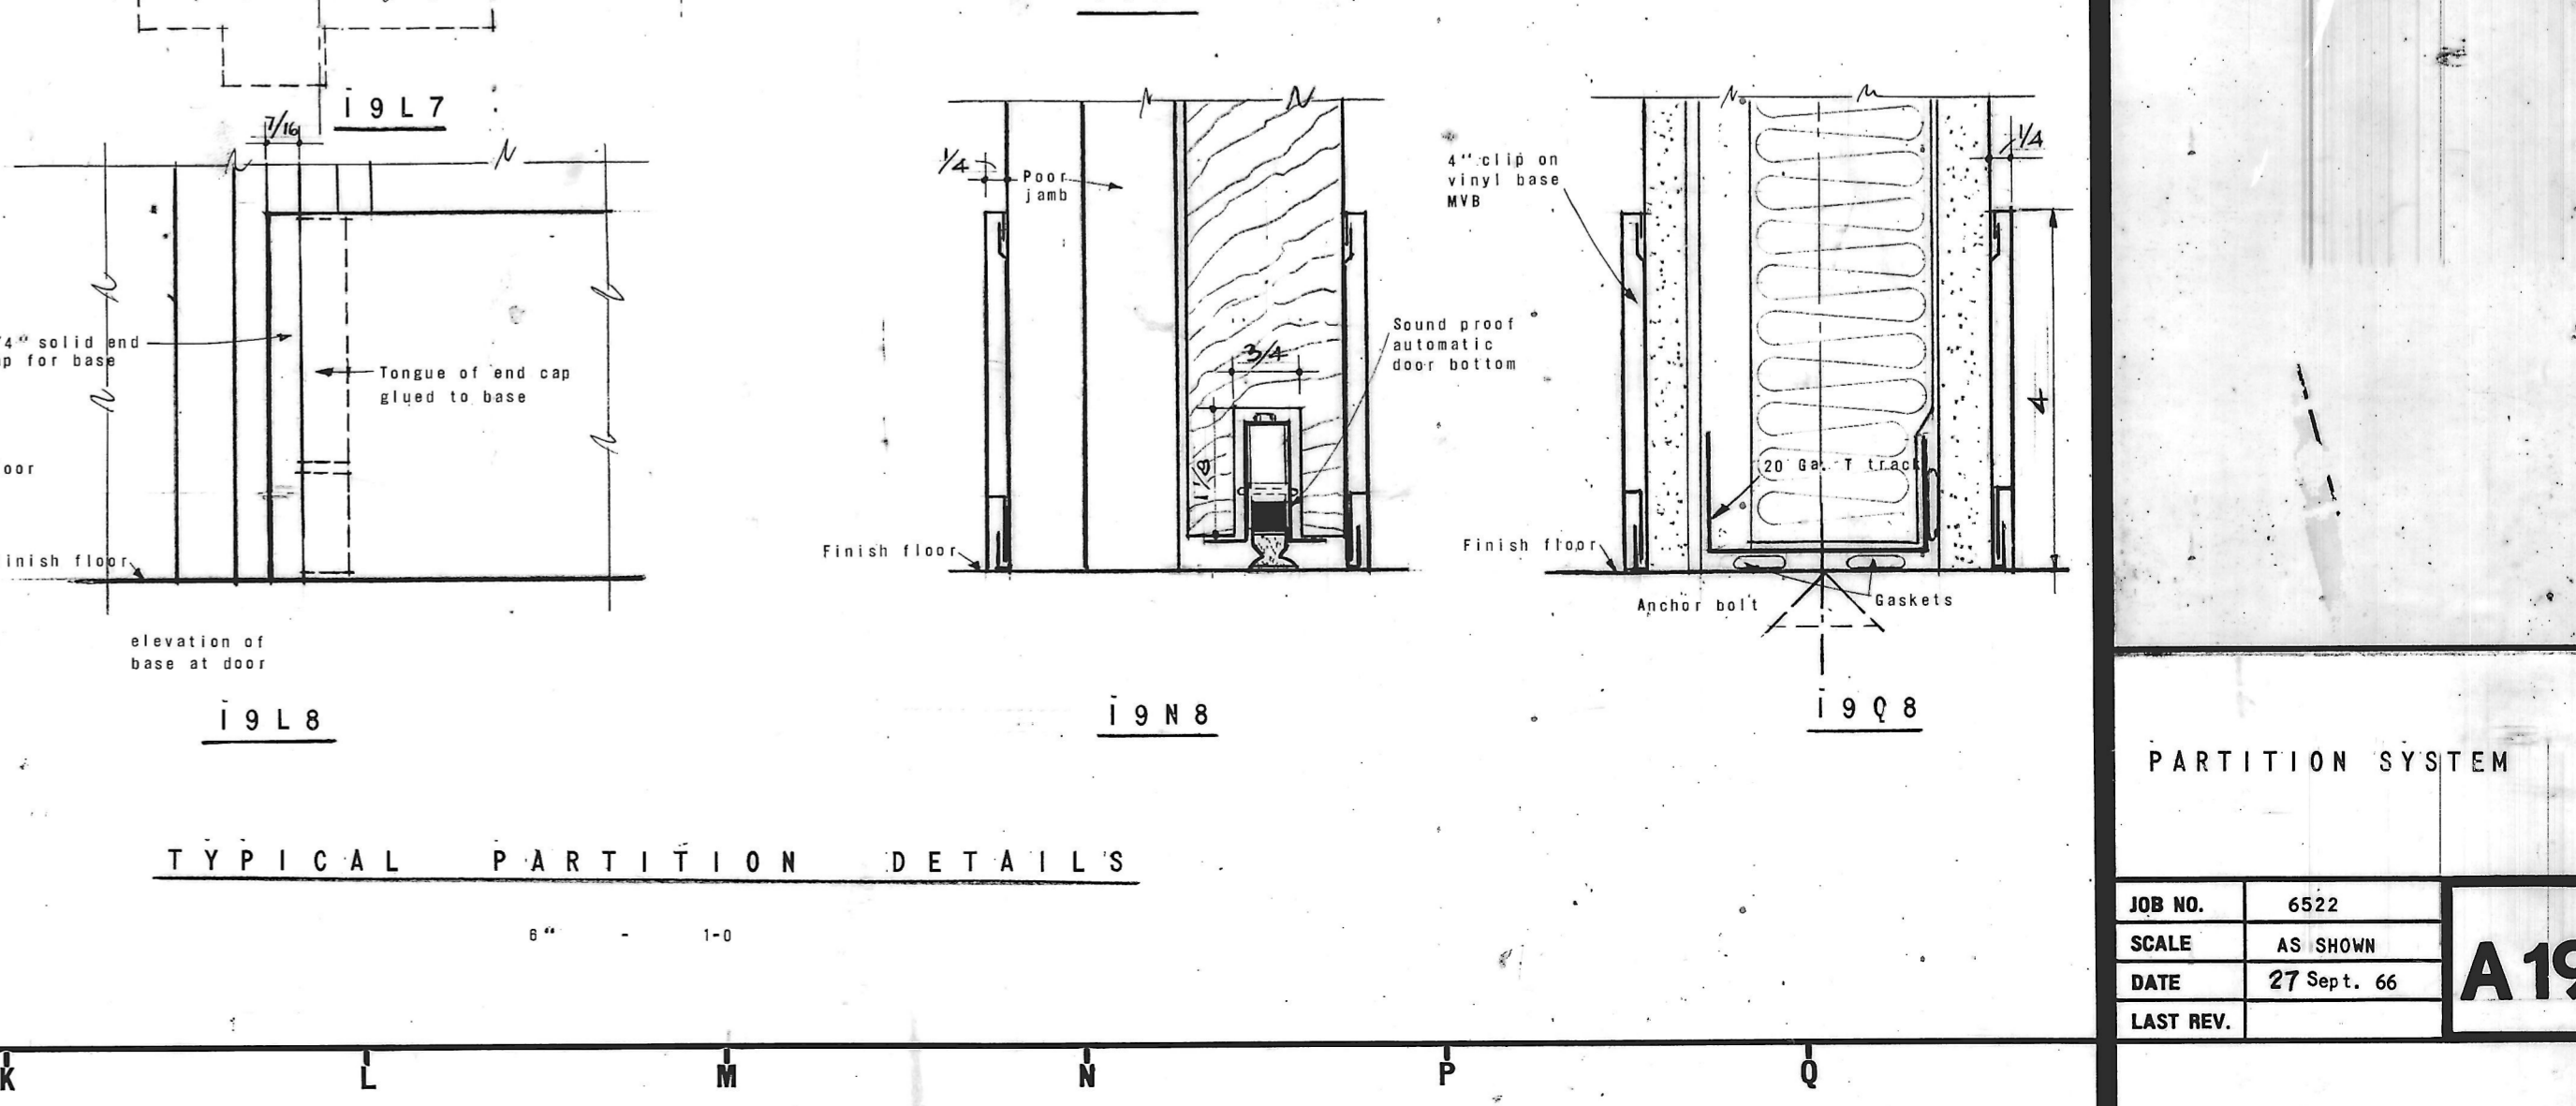
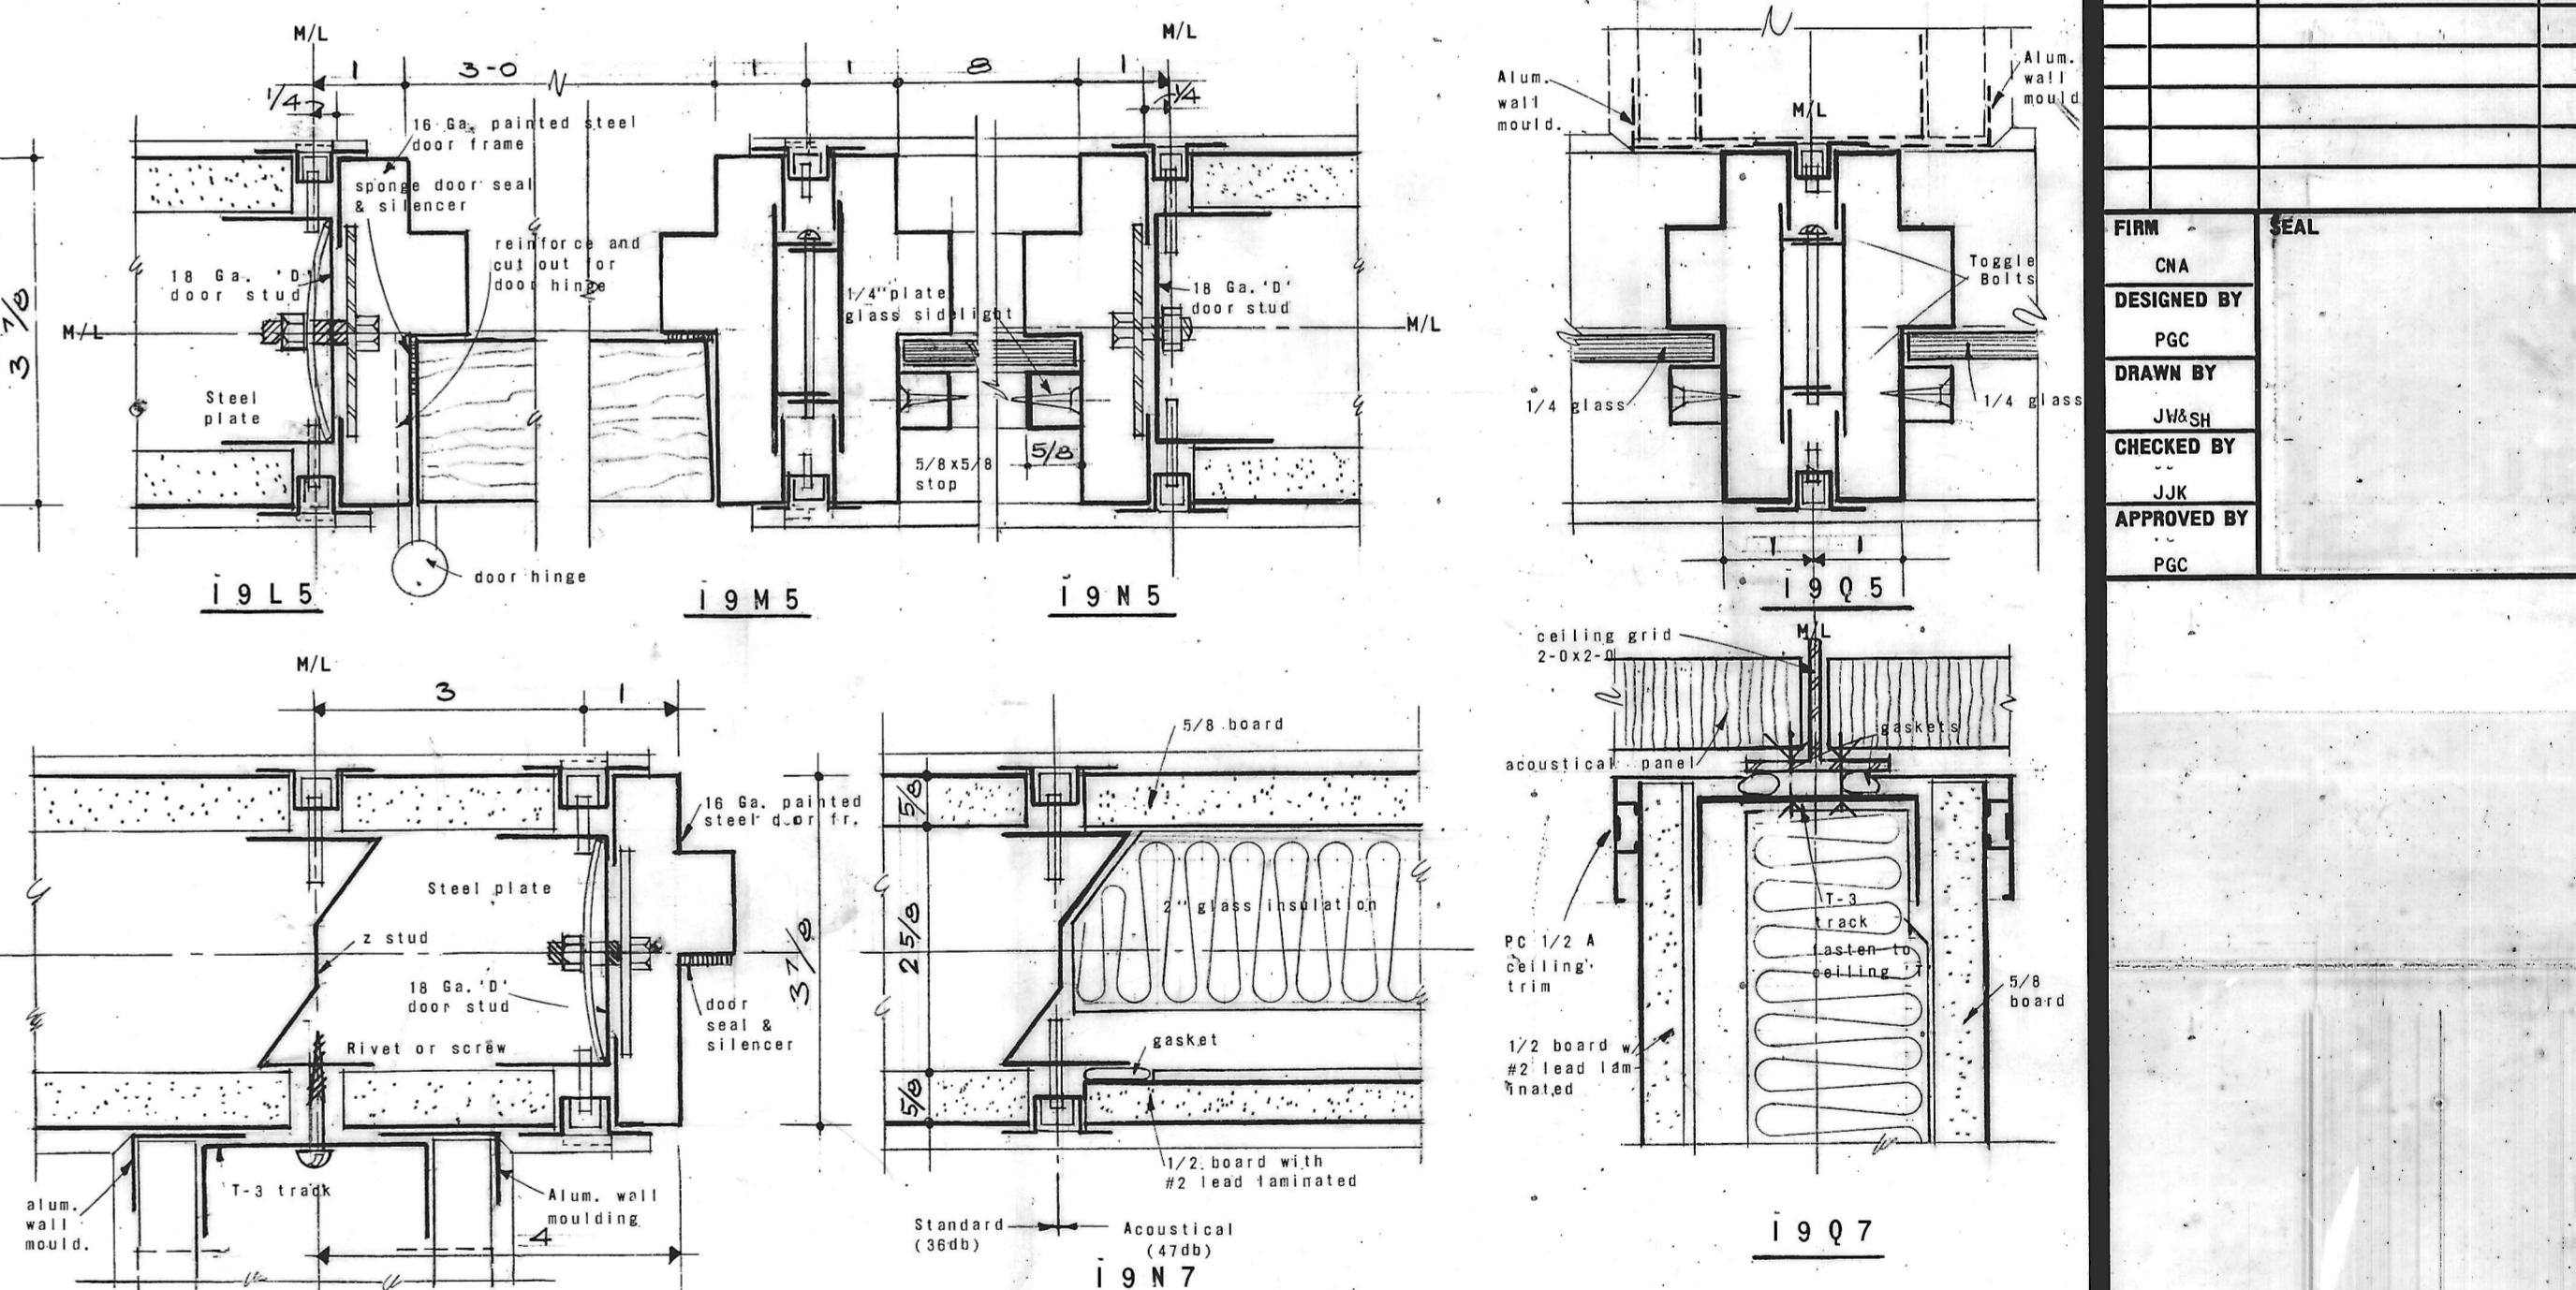
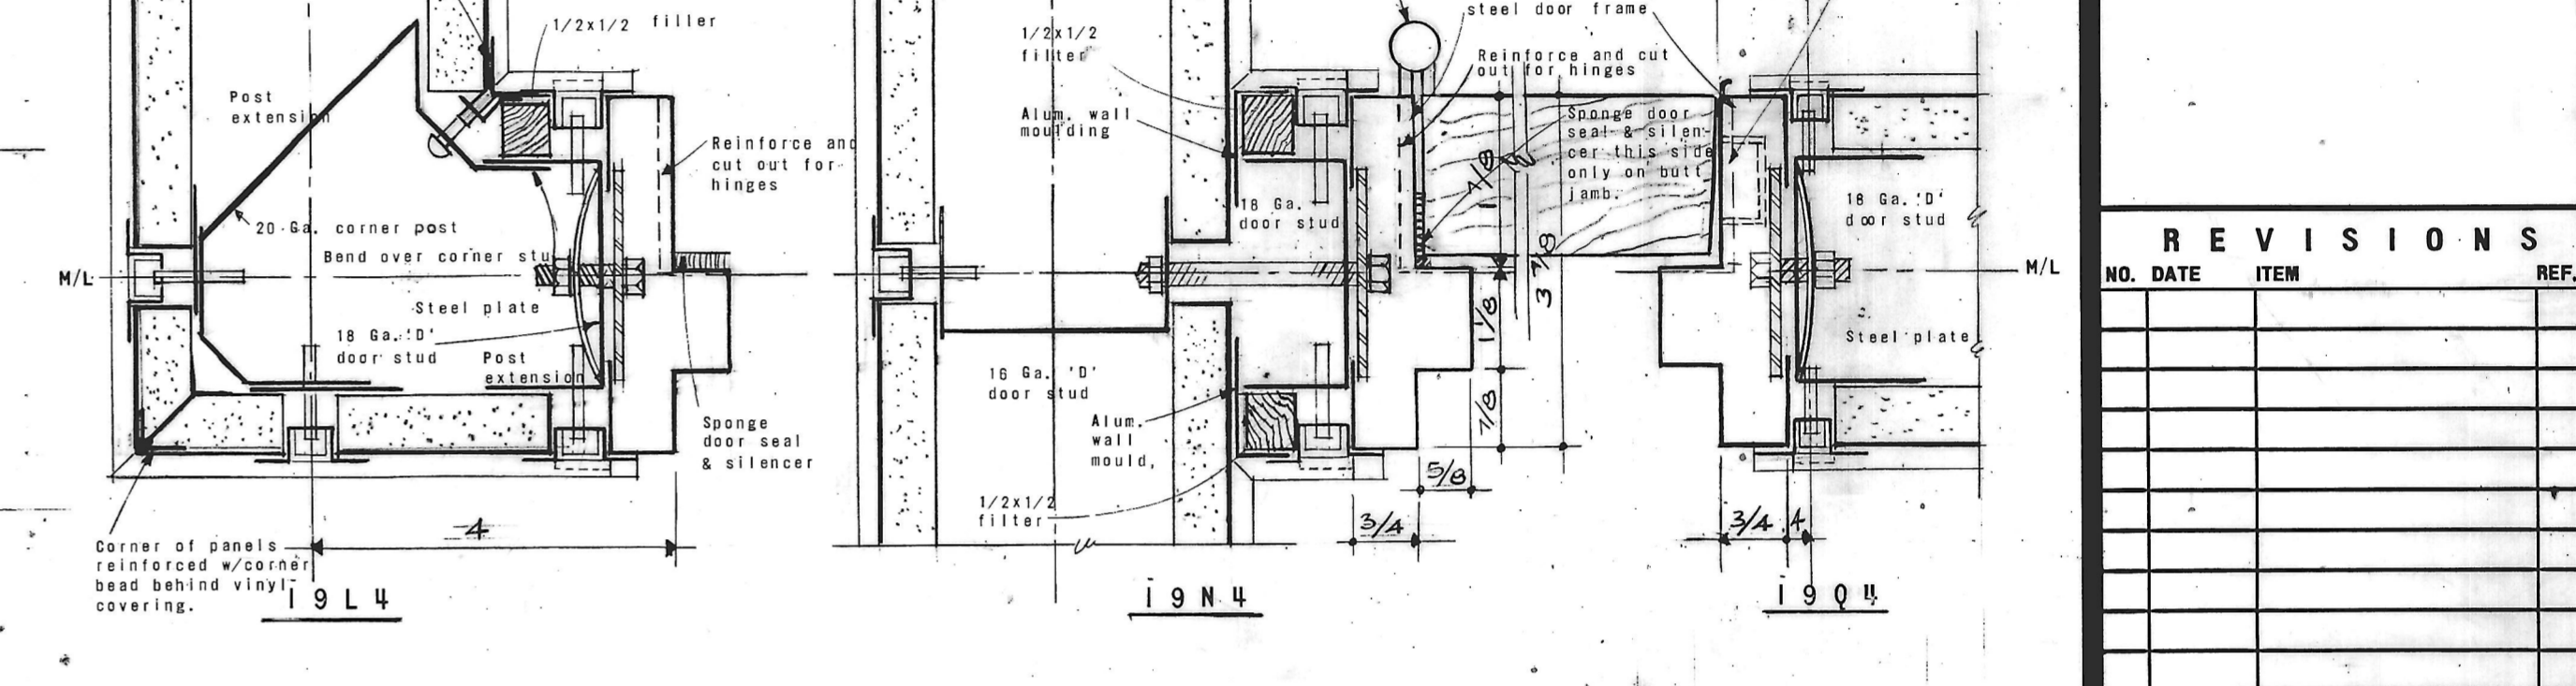
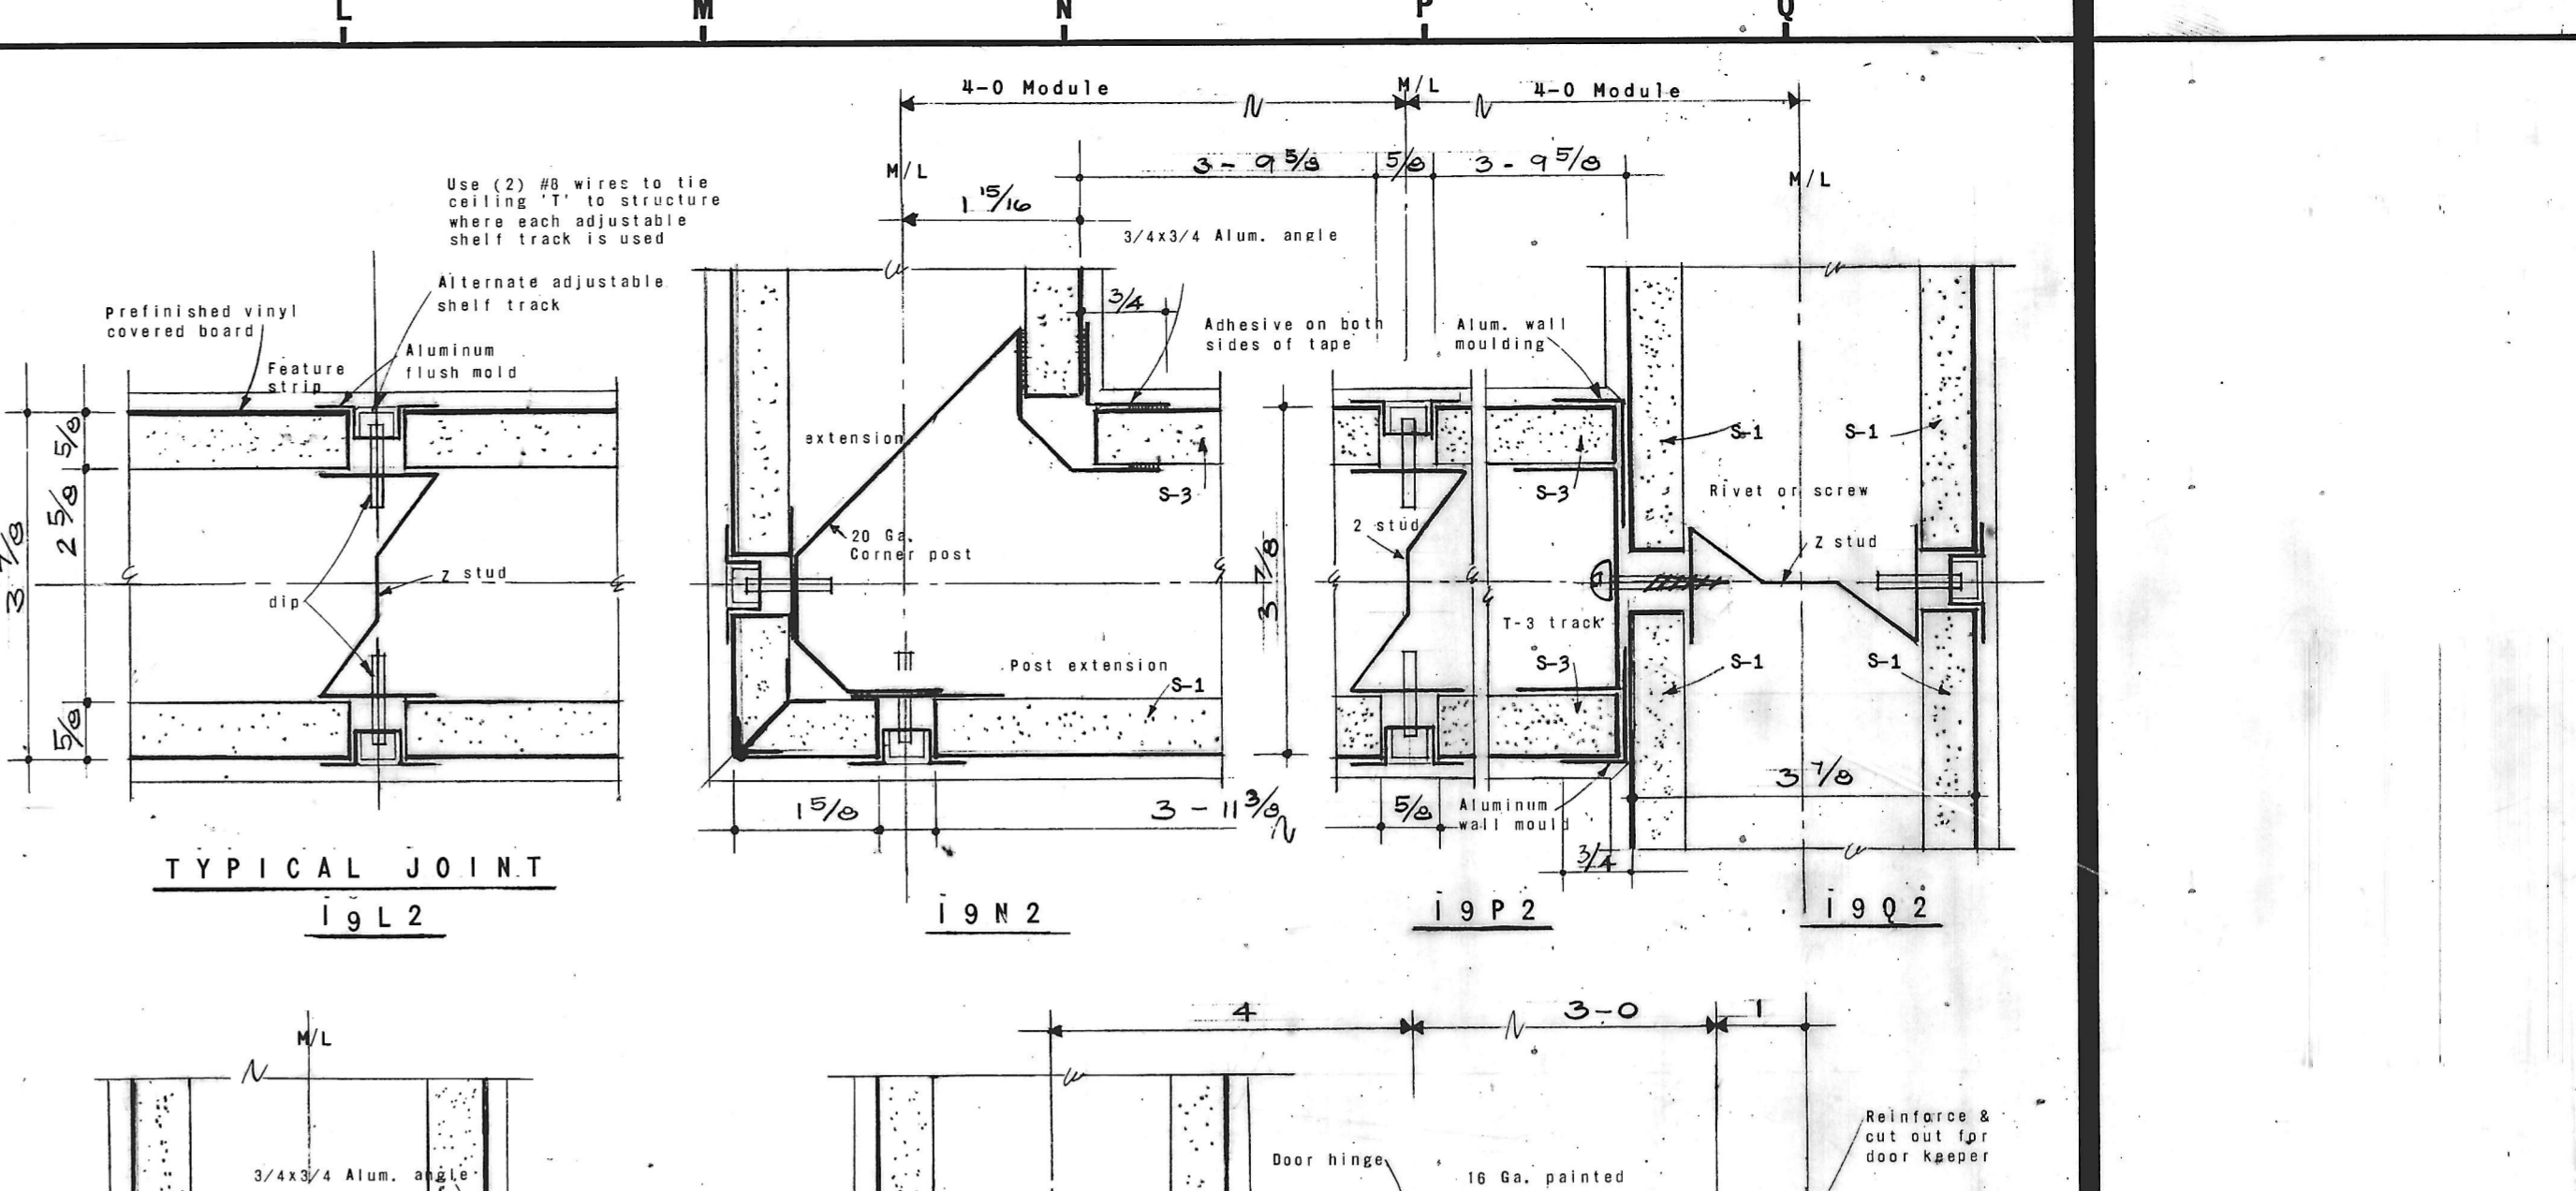


**PANEL SCHEDULE**

BLDG. STD.	KEY	PANEL TYPE	MODULAR SIZE	CONDITION	DRYWALL SHEET WIDTH	LOCATION
*	S-1	SOLID	4-0 x 8-7	FULL MODULE	3-11 3/8	
*	S-2	SOLID	2-0 x 8-7	FULL MODULE	1-11 3/8	
*	S-3	SOLID	4-0 x 8-7	CORNER - STARTER	3-9 5/8	INSIDE PANEL
*	S-4	SOLID	2-0 x 8-7	CORNER - STARTER	1-9 5/8	INSIDE PANEL
*	C	SOLID		CORNER	1 5/8 x 1 5/8	PREFORMED
	D-1	DOOR	4-0 x 8-7	FULL MODULE	3-11 3/8	ABOVE DOOR
	D-2	DOOR	4-0 x 8-7	CORNER - STARTER	3-9 5/8	INSIDE PANEL
	D-3	DOOR	4-0 x 8-7	SIDE LIGHT	3-11 3/8	ABOVE DOOR
	G-1	GLAZED	4-0 x 8-7	FULL MODULE	3-11 3/8	ABOVE GLASS
	G-2	GLAZED	2-0 x 8-7	FULL MODULE	1-11 3/8	ABOVE GLASS
	G-3	GLAZED	4-0 x 8-7	CORNER STARTER	3-9 5/8	INSIDE PANEL
	G-4	GLAZED	2-0 x 8-7	CORNER STARTER	1-9 5/8	INSIDE PANEL
	G-5 THRU G-8	GLAZED	SIM. G-1 THRU G-4	SOLID 3-6 HIGH	SIM. G-1 THRU G-4	
	G-9 THRU G-12	GLAZED	SIM. G-1 THRU G-4	FULL HEIGHT GLASS	SIM. G-1 THRU G-4	

**NOTES:**  
 PREFIX - D - Ahead of above key - indicates DOOR HEIGHT PARTITIONS of solid, door opening or glazed types.  
 PREFIX - L - Ahead of above key - indicates LOW PARTITIONS, glazed above with gates in openings.  
 SUFFIX - A - After above key - indicates ACOUSTICAL wall panels (47 db). All partitions between separate tenants and between tenants and corridors to be acoustical type.  
 COLOR - Building standard unless noted on lease plan.  
 GLASS - Clear crystal - unless noted on lease plan.

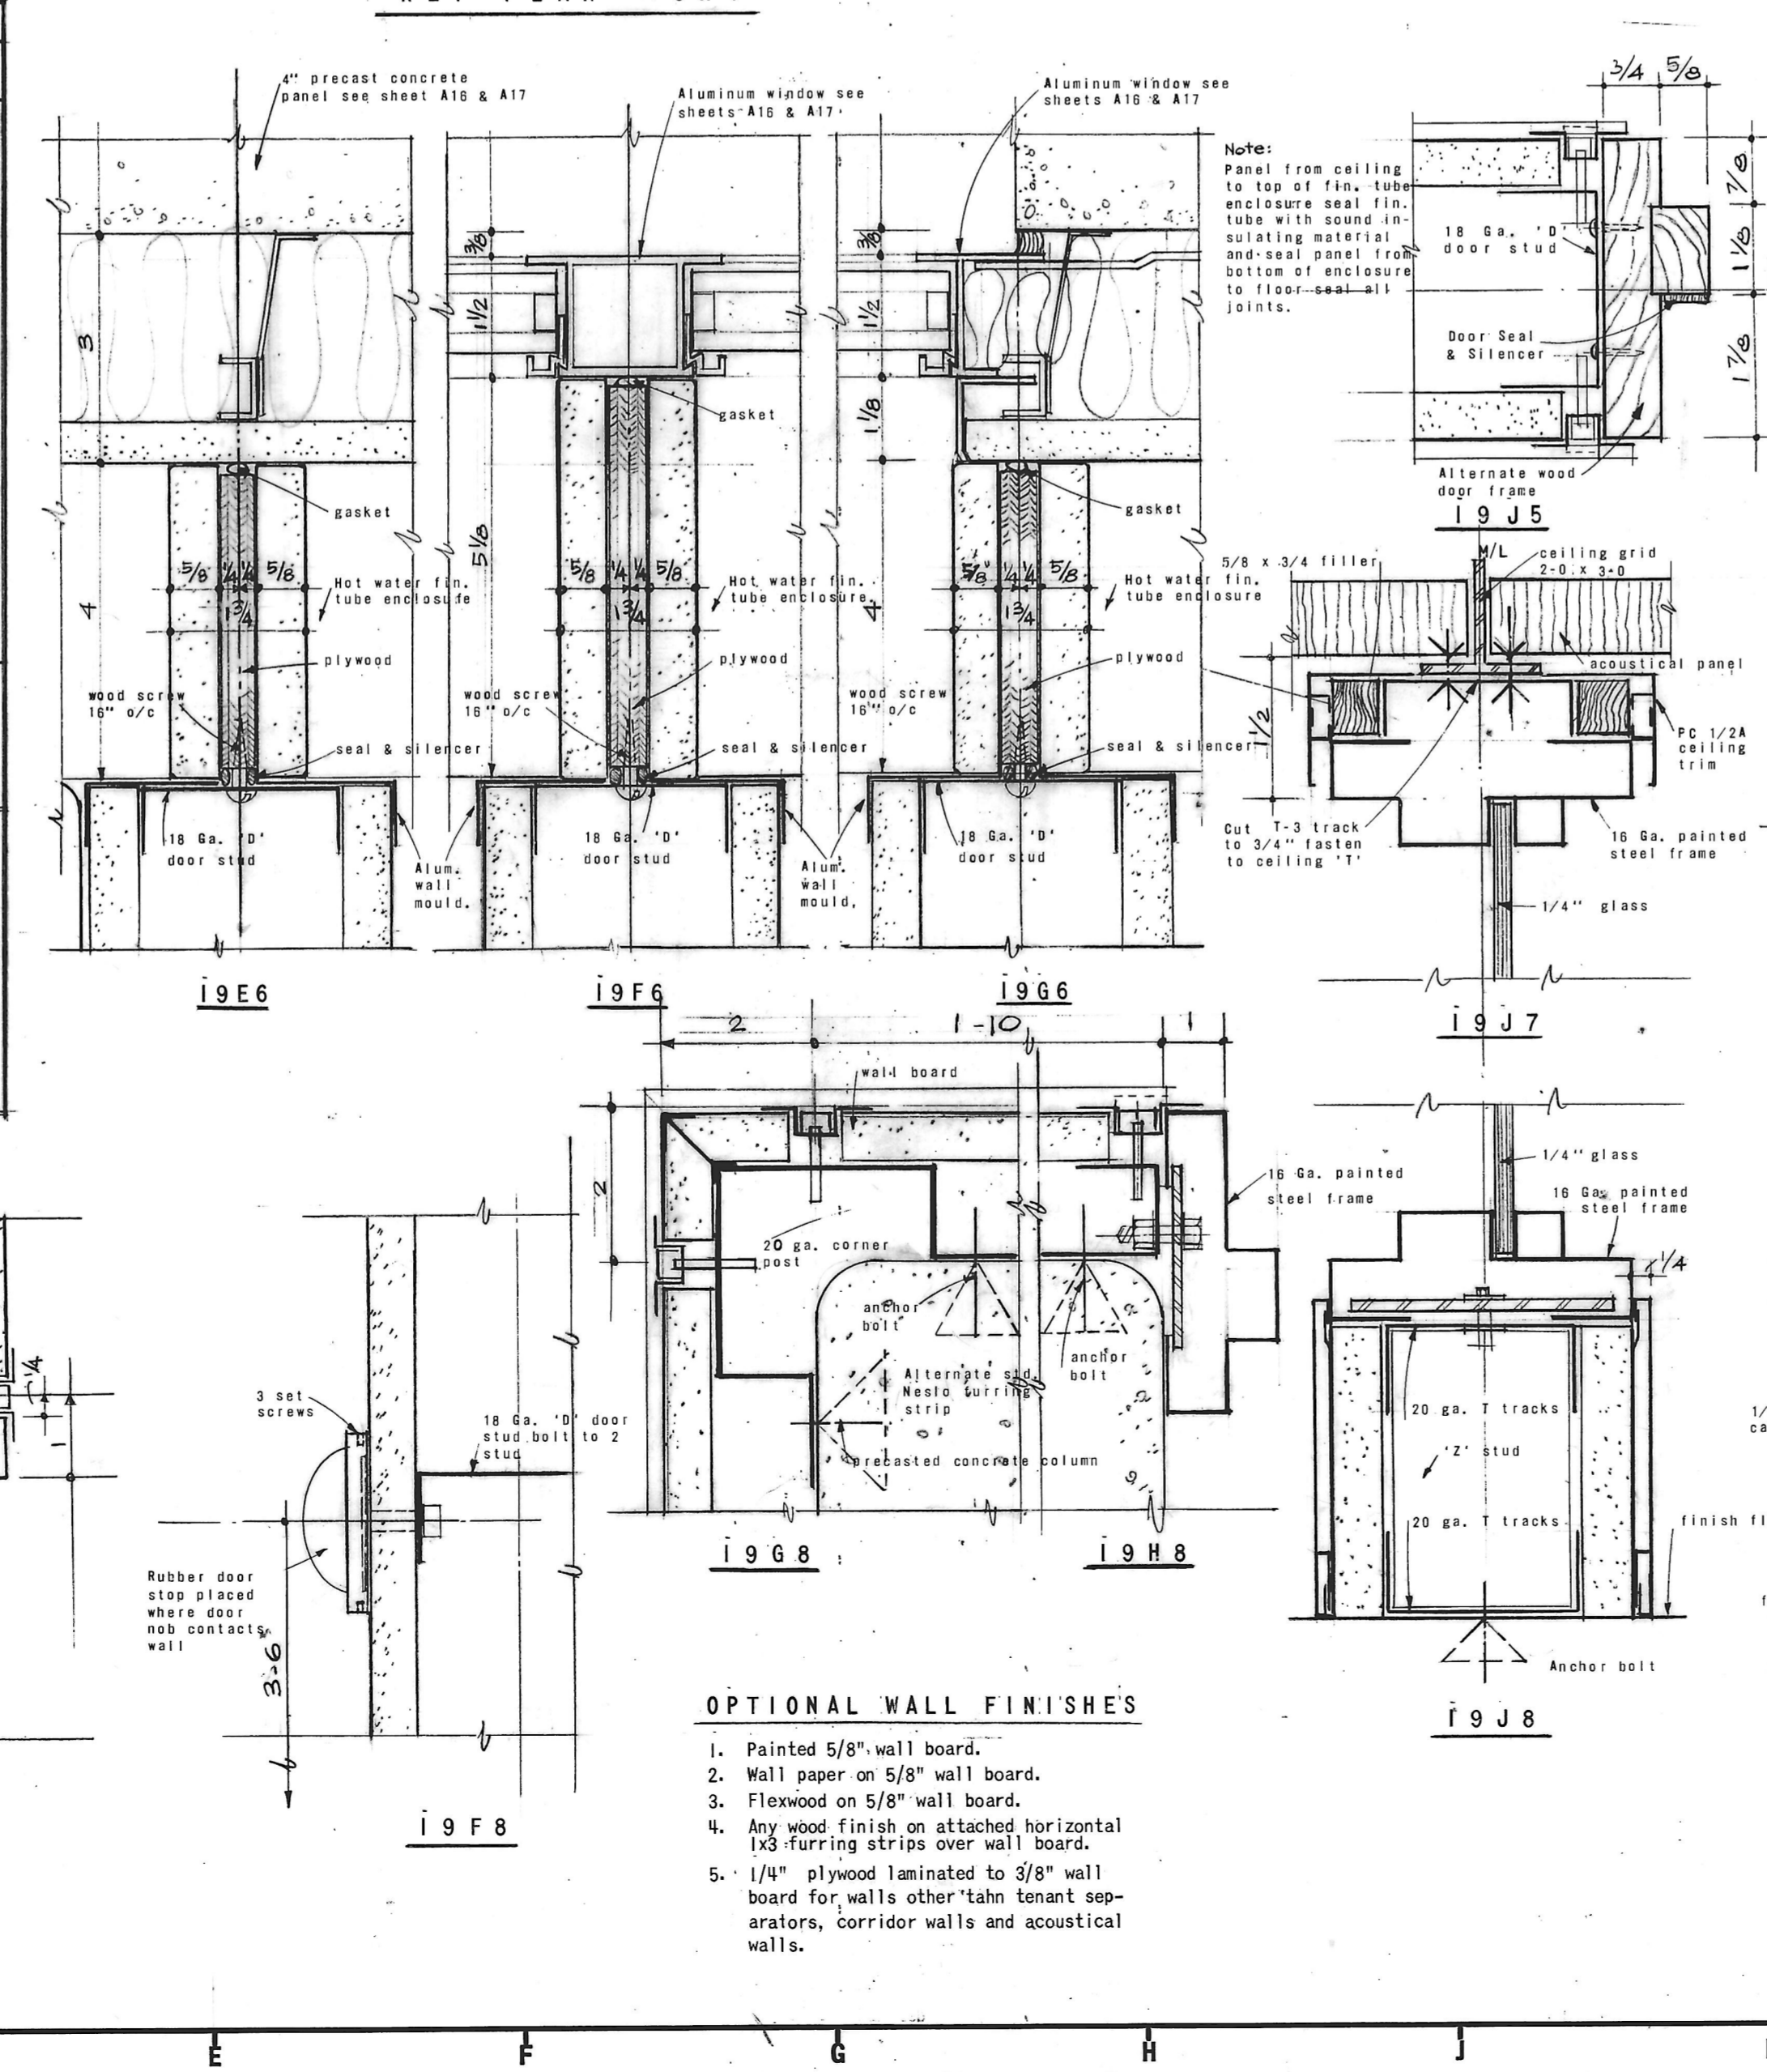

**REVISIONS**

NO.	DATE	ITEM	REF.

FIRM: CNA  
 DESIGNED BY: PGC  
 DRAWN BY: JMS/SJ  
 CHECKED BY: JJK  
 APPROVED BY: PGC

**PARTITION SYSTEM**

JOB NO. 6522  
 SCALE AS SHOWN  
 DATE 27 Sep. 66  
 LAST REV.

**A19**