


NOTES

1. All piping and ductwork at clg. unless indicated otherwise.

PLUMBING CONNECTION		SCHEDULE			
DESIGNATION	FIXTURE	H.W.	C.W.	WASTE	REMARKS
P-1	Water Closet	-	1	4	
P-2	Urinal	-	1	2	
P-3	Service Sink	1/2	1/2	3	
P-4	Counter Top Sinks	1/2	1/2	1 1/2	
P-5	Water Mixer (See Detail this sheet)	1/2	1/2	-	3" P.D.
DWC	Drinking Water Cooler	-	1/2	1 1/2	

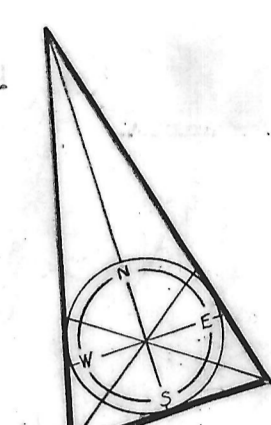



REVISIONS

NO.	DATE	ITEM	REF.
1	11/23/66	Add Oil Interceptor	



FIRM H. ADAMS
 DESIGNED BY GHZ
 DRAWN BY ACP
 CHECKED BY AEW
 APPROVED BY KVB

SEAL H.A. JOB NO. N-16

SECTION MIA1
Scale: 1/4" = 1'-0"

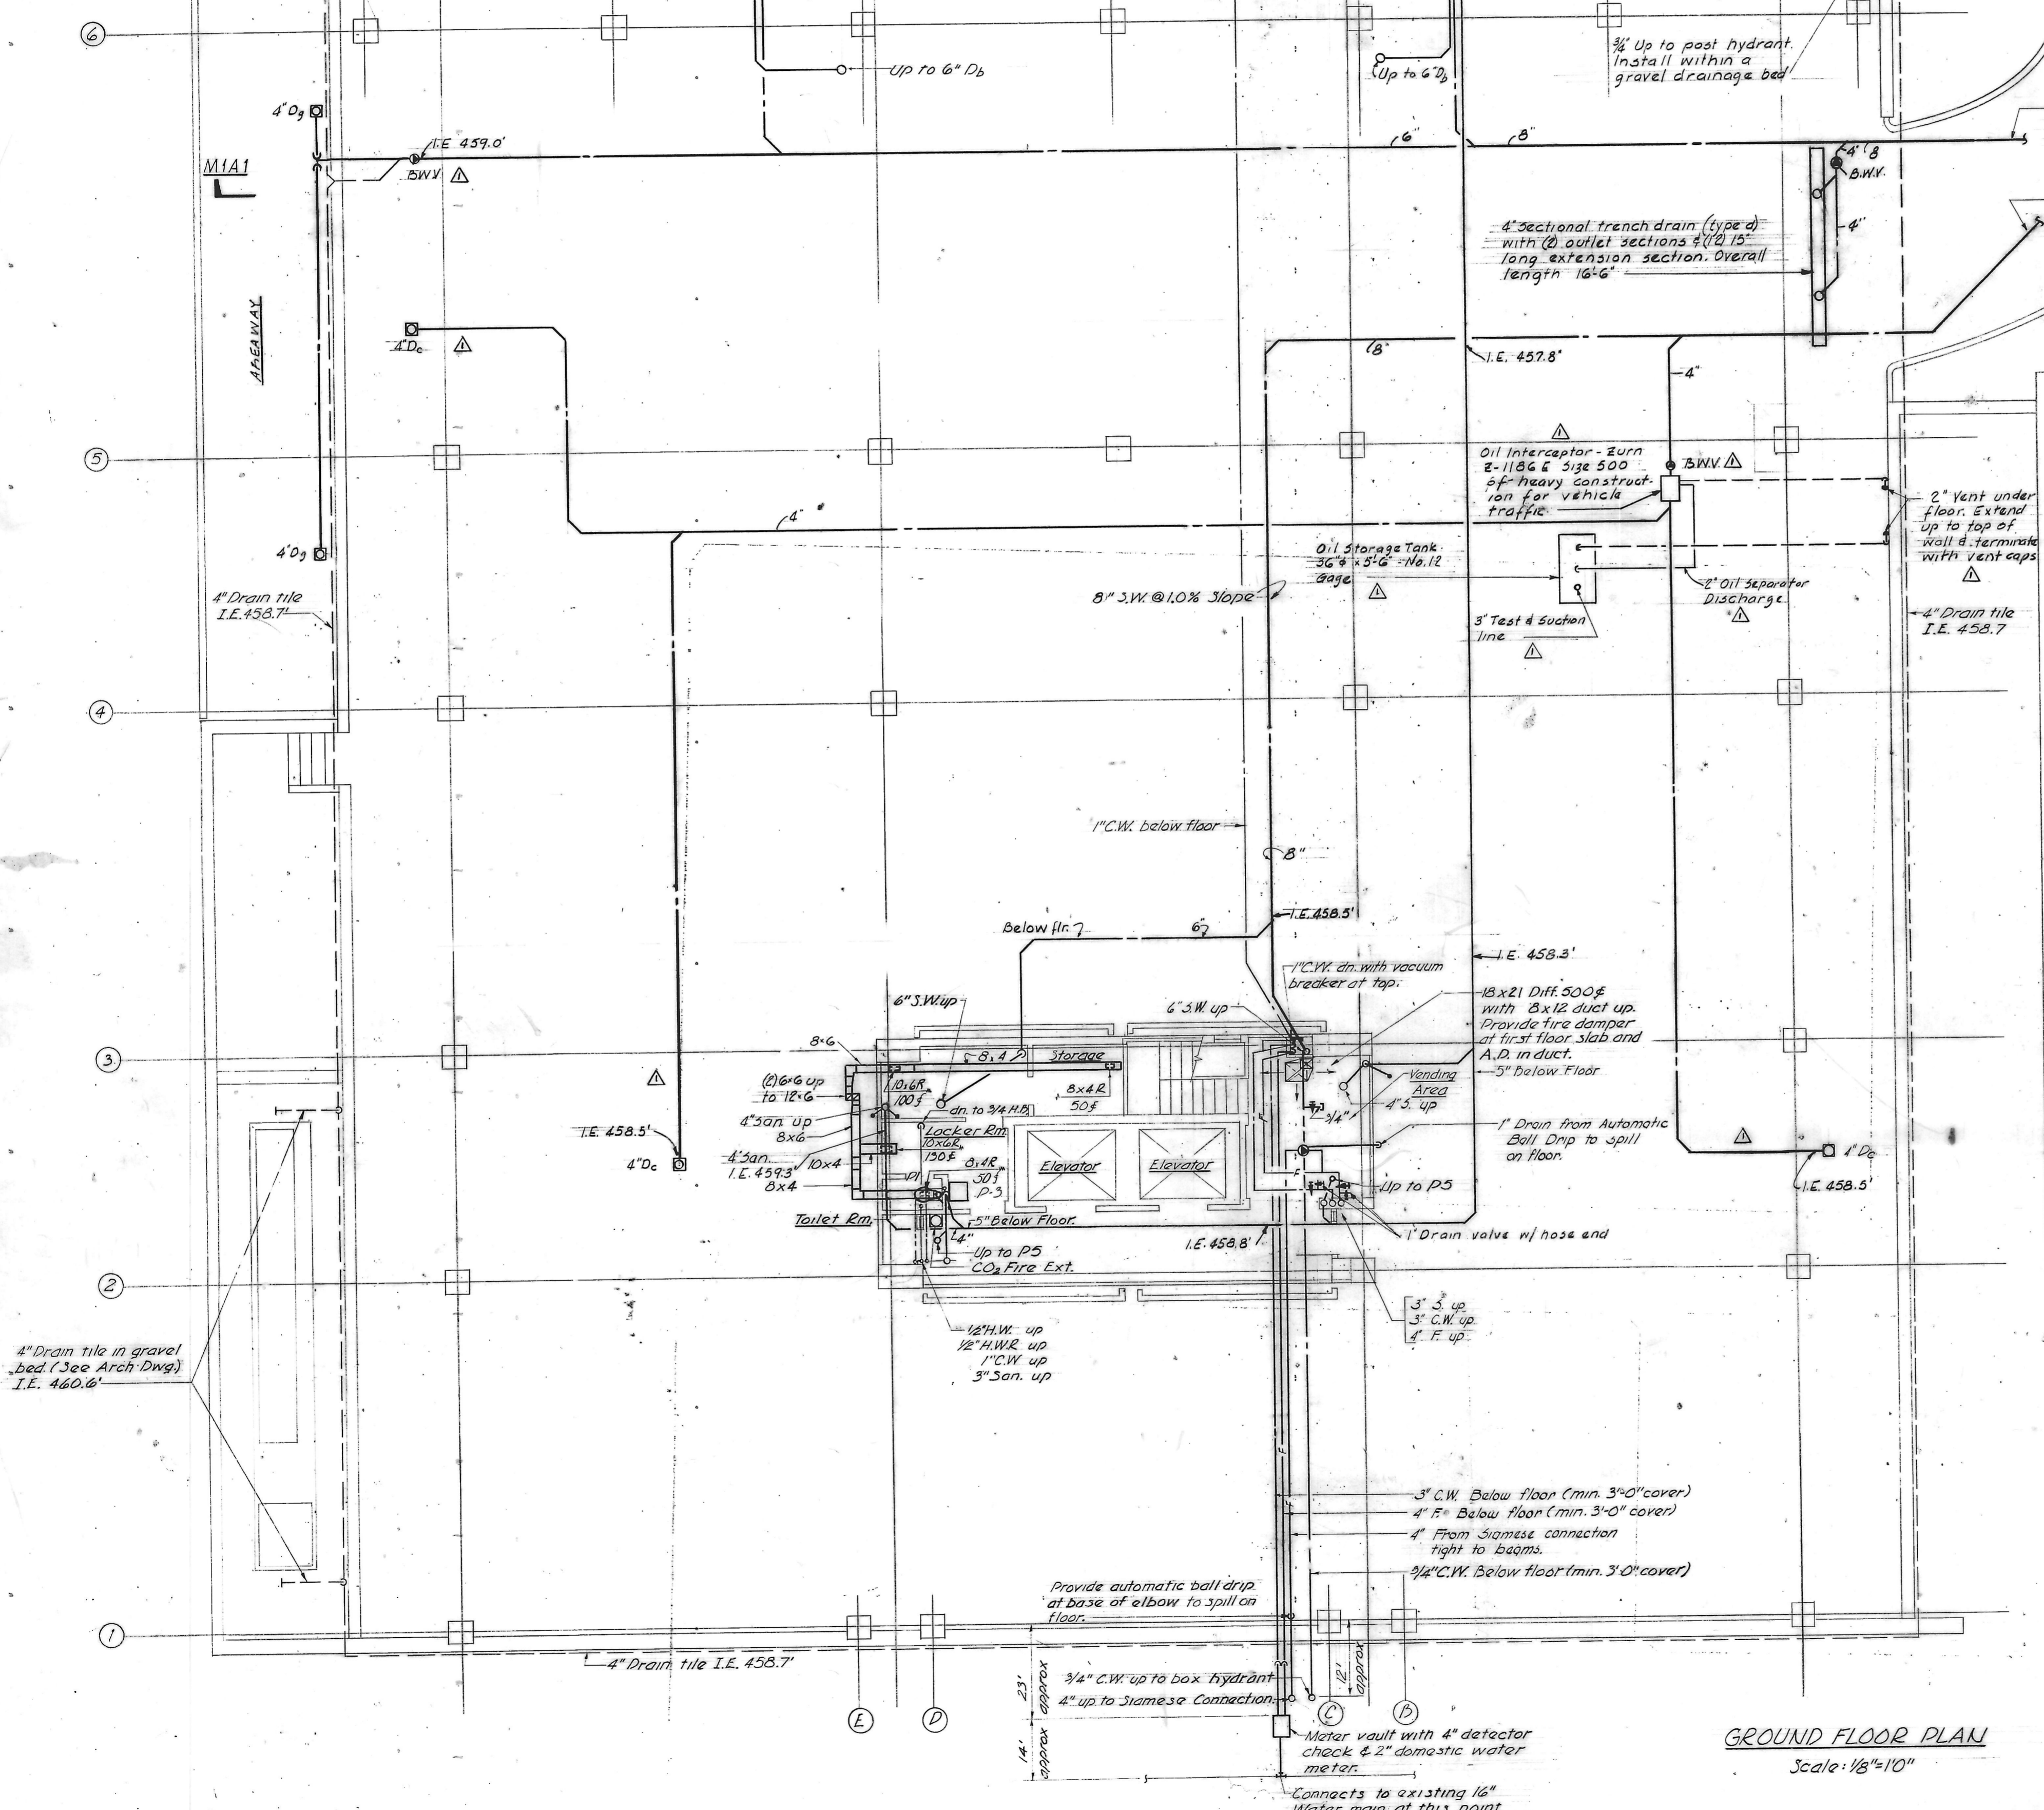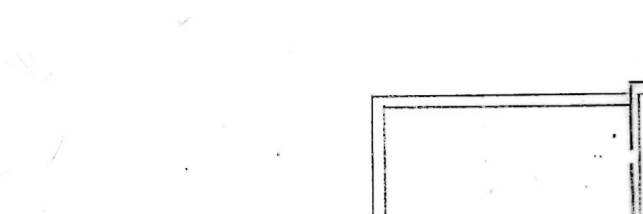


GROUND FLOOR PLAN
Scale: 1/8" = 1'-0"

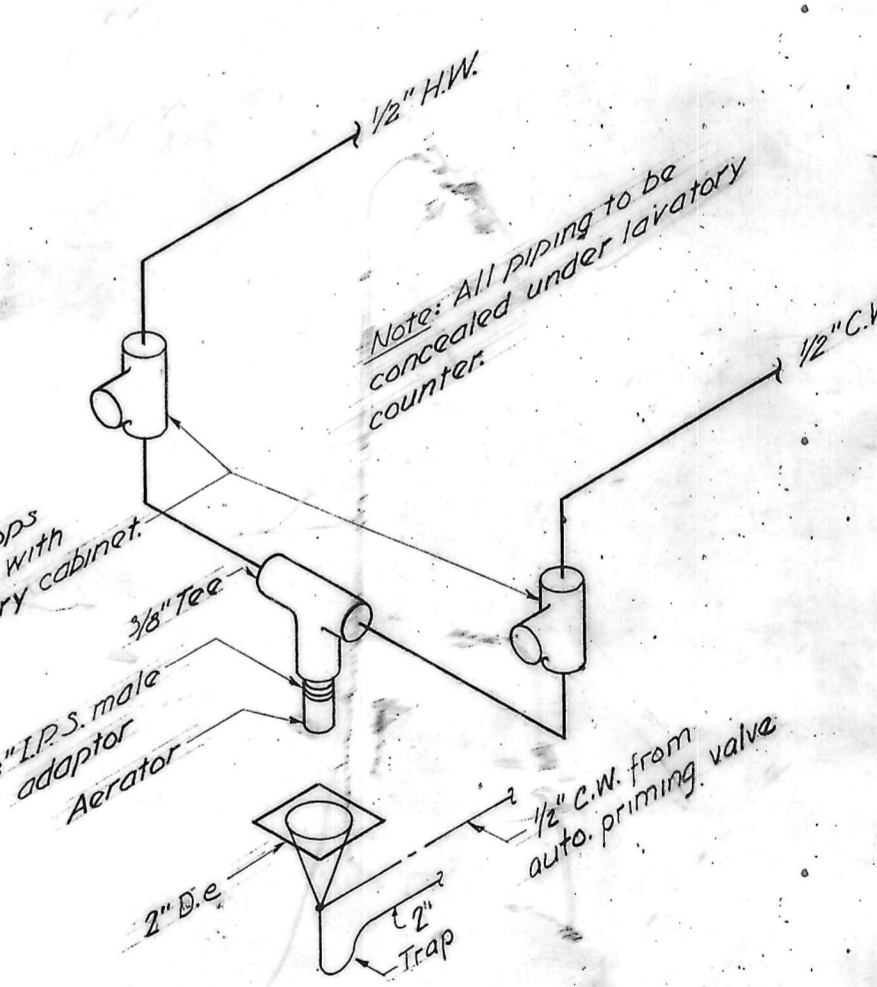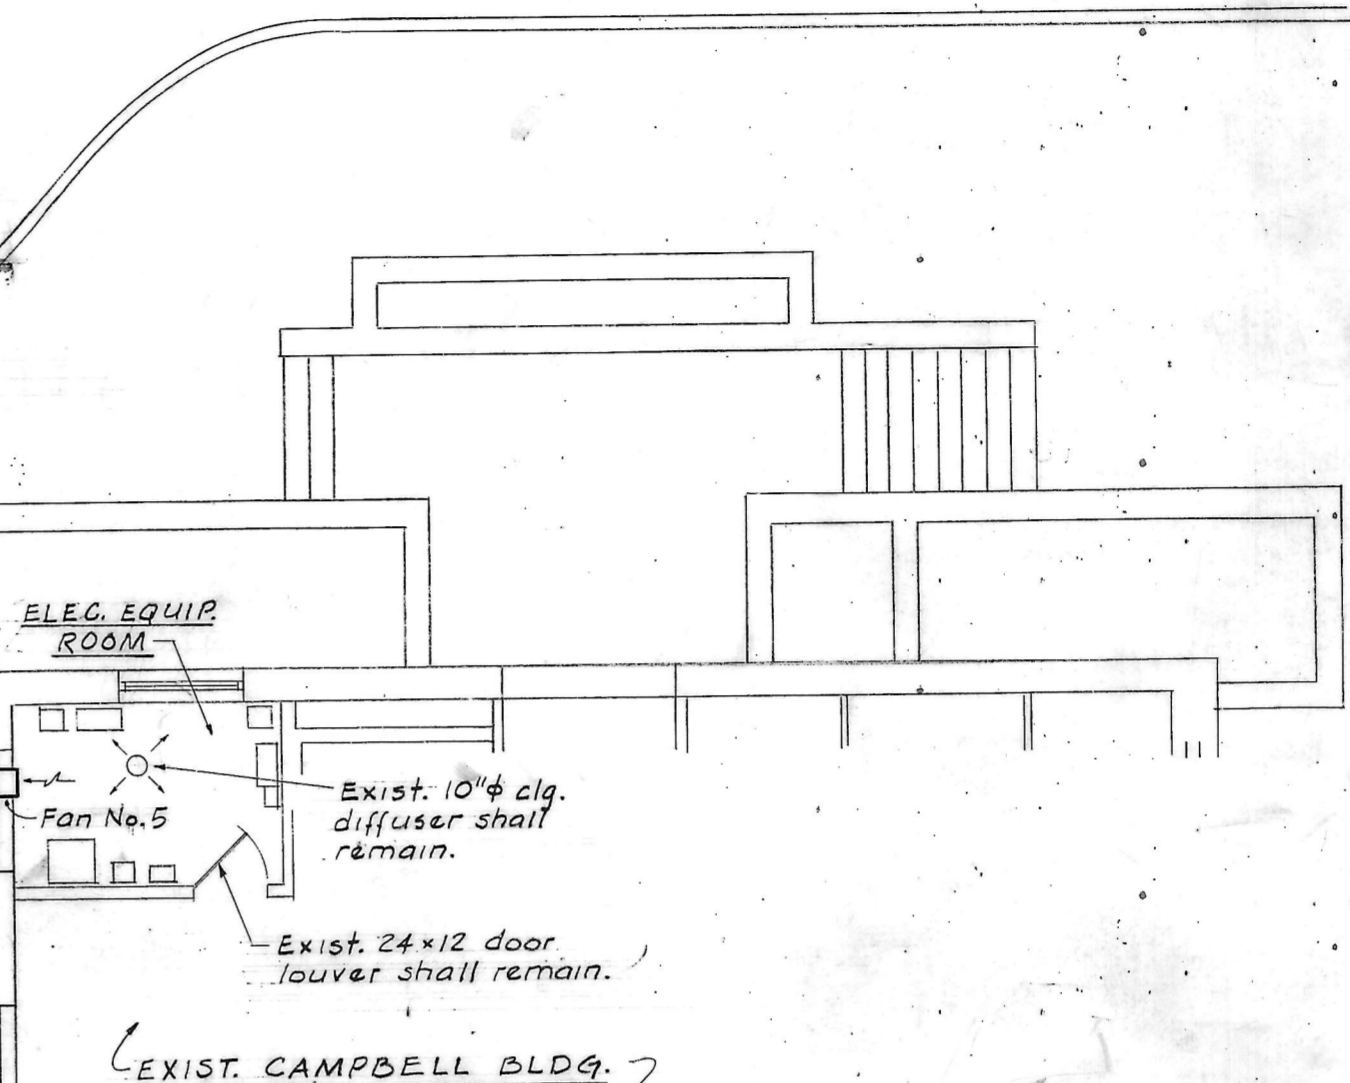

DETAIL OF WATER MIXER (P5)
No Scale

Note: Provide one mixer under each lavatory counter in Men's and Women's Toilet. See Arch. Dwg. A-18 for mounting position.

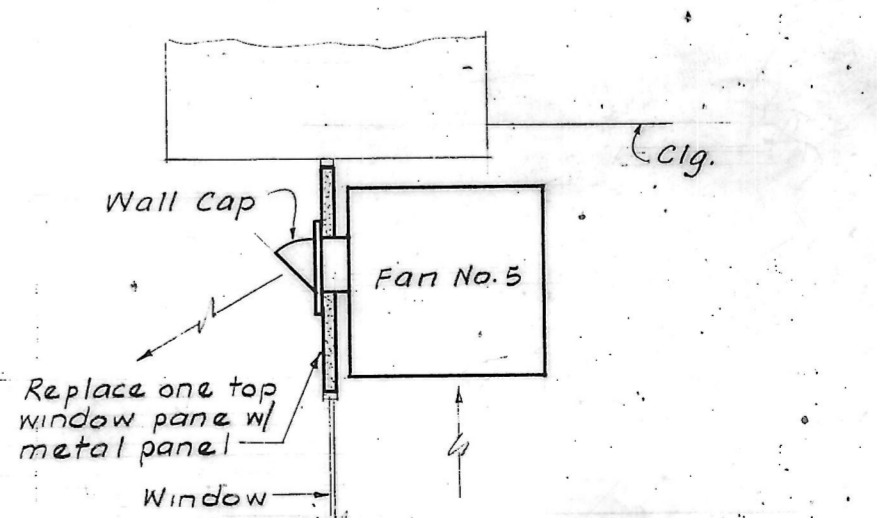

SECTION MIP9
Scale: 1" = 1'-0"

GROUND FLOOR PLAN

JOB NO. 6522
 SCALE A9 NOTED
 DATE SEPT. 27, 1966
 LAST REV.

M-1

MICROFILMED