



FOURTH FLOOR PLAN - ALEX. BROWN & SONS
Scale: 1/8" = 1'-0"

NOTE: 1. All diffusers serving interior spaces shall be 12x12 size with 6" neck.
2. All R.A. grilles shall have sound treatment per letter to Custom Mach. Contractors dated July 11, 1967.

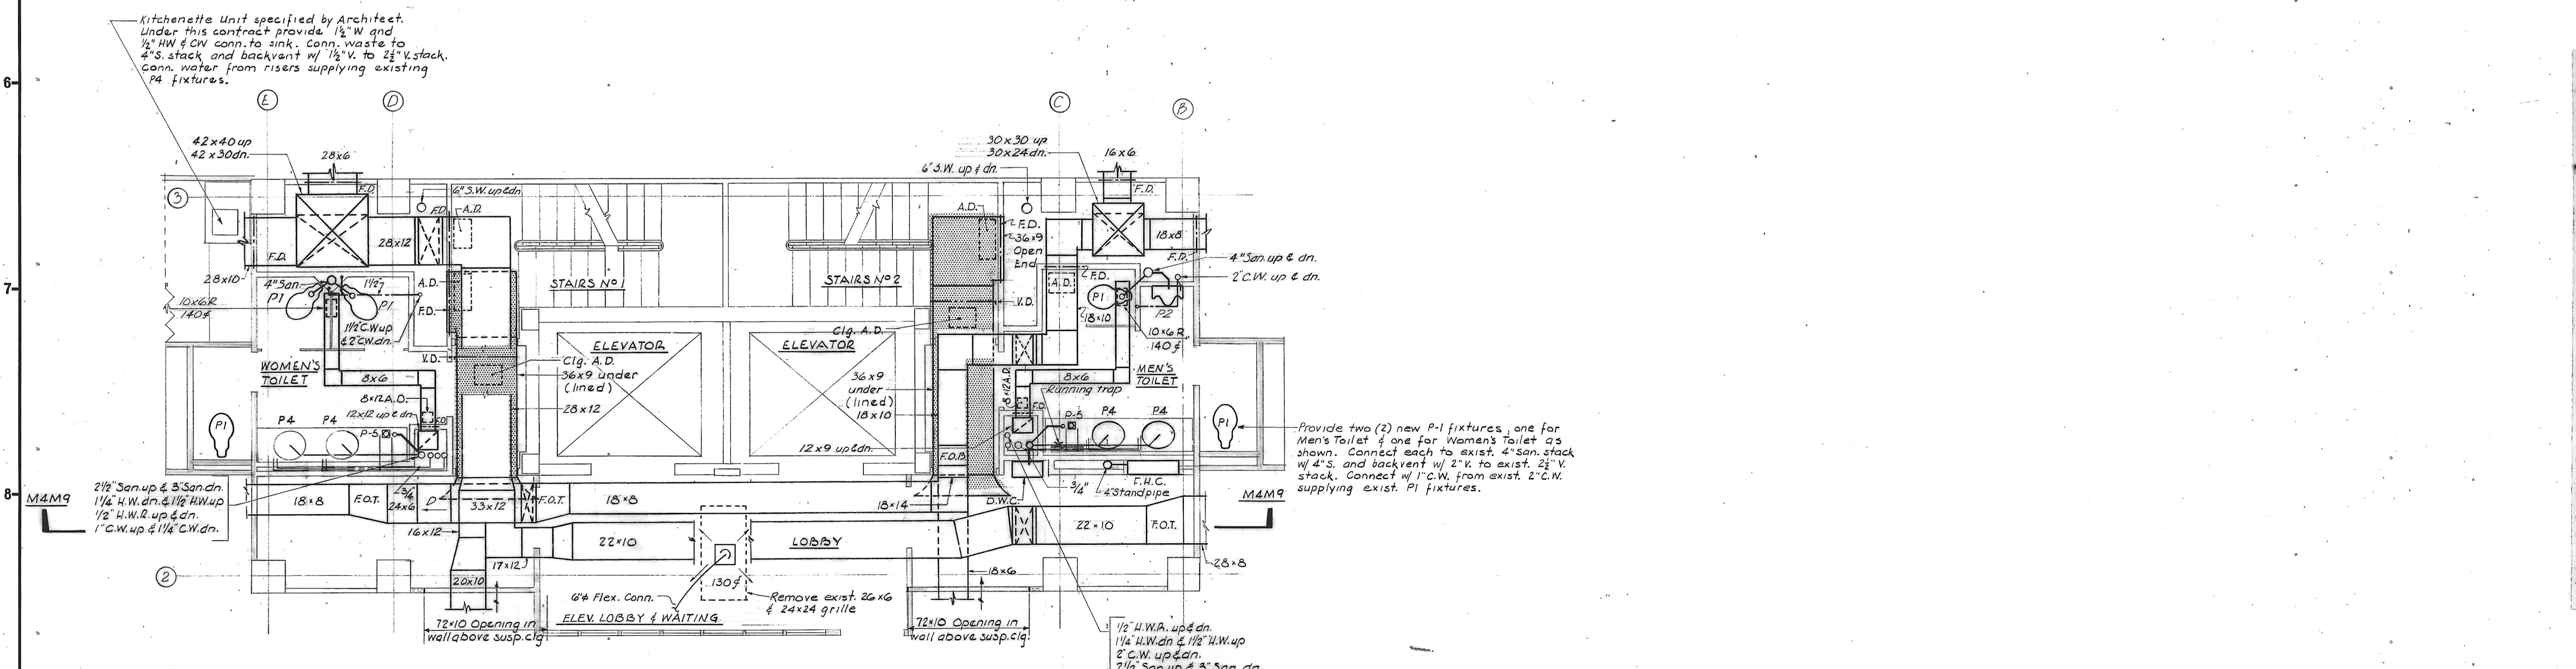

FOURTH FLOOR UTILITY CORE PLAN
Scale: 1/4" = 1'-0"

NOTES
1. All shaded ductwork this drawing shall be lined with 1" acoustic duct lining.
2. For exact location of perimeter diffusers see Arch. Drawings.

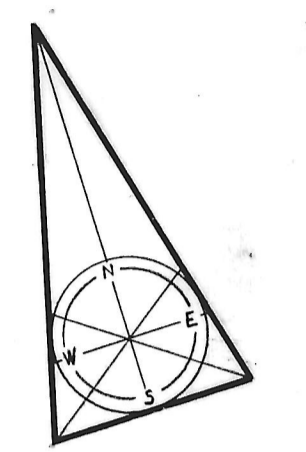

REVISIONS

NO.	DATE	ITEM	REF.
1	4-10-68	ALEX. BROWN & SONS	

FIRM: H. ADAMS
DESIGNED BY: GHZ
DRAWN BY: ACP
CHECKED BY: AEW
APPROVED BY: KVB

SEAL: H.A. JOB NO. N-16
STATE OF MARYLAND
REGISTERED PROFESSIONAL ENGINEER

STRUCTURAL ENGINEERING
VAN RENSSELAER P. SAN
1701 ST. PAUL ST. BALTO, MD. 21204

MECHANICAL-ELECTRICAL ENGINEERING
HENRY ADAMS, INC.
2815 ST. PAUL ST. BALTO, MD. 21218

CHRISTIE, NILES & ANDREWS
27 N. Pitters Lane
Towson, Maryland 21286
1647 31st Street N.W.
Washington, D.C. 20007

ARCHITECTS

OFFICE BUILDING
FOR
NOTTINGHAM FARMS INC.

102 W. PENNSYLVANIA AVE.
TOWSON, MARYLAND 21204

FOURTH FLOOR PLAN

JOB NO.	6522
SCALE	AS NOTED
DATE	SEPT. 27, 1966
LAST REV.	APRIL 10, 1968

M-5

MICROFILMED