


CURRENT RATING	TYPE	2 POLE - WIRE NO GROUND		2 POLE - 3 WIRE GROUNDING		1 POLE 4 WIRE GROUNDING
		125V	250V	125V	250V	125/250V
15A	STRAIGHT BLADE					
	TWIST LOCK					
20A	STRAIGHT BLADE					
	TWIST LOCK					
30A	STRAIGHT BLADE					
	TWIST LOCK					
50A	STRAIGHT BLADE					
	TWIST LOCK					
60A	STRAIGHT BLADE					
	TWIST LOCK					



ELECTRICAL LEGEND

SYMBOLS		ABBREVIATIONS	
	JUNCTION BOX (J-BOX)	A	AMPERES
	EQUIPMENT INTERCONNECTION BY E.C.	V	VOLTS
	ELECTRICAL ROUGH-IN	W	WATTS
	DUPLEX ELECTRICAL OUTLET (DEO)	PH	PHASE
	FLUORESCENT LIGHT FIXTURE	AFF	ABOVE FINISHED FLOOR
	BREAKER PANELBOARD	DN	DOWN FROM ABOVE
	SWITCH AS NOTED	HP	HORSE POWER
	FLOOR BOX (FL. BOX)	KW	KILOWATTS
	DATA LINE CONNECTION	K.E.C.	KITCHEN EQUIPMENT CONTRACTOR
		E.C.	ELECTRICAL CONTRACTOR
		CONV.	CONVENIENCE OUTLET 120V 1PH 20.0A

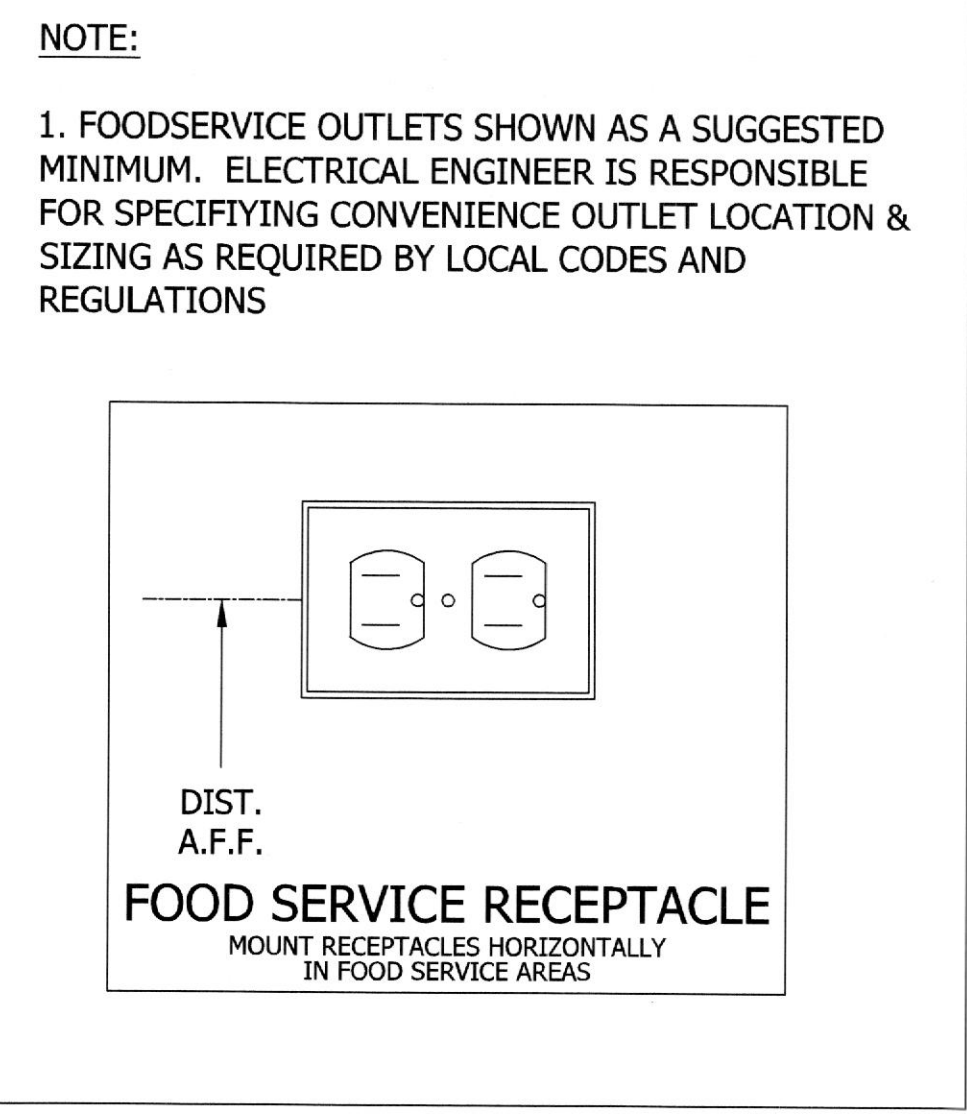

ELECTRICAL EQUIPMENT ROUGH-IN SCHEDULE

ITEM NO	QTY	EQUIPMENT CATEGORY	PLUG	DIRECT	VOLTS	PHASE	CYCLE	AMPS	KW	HP	NEMA	ELECTRICAL AFF (IN)	ELEC REMARKS
P1.1	1	WALK-IN COOLER		X	115	1	60	1.8				DN	SEE MANUFACTURE SHOP DRAWINGS
P1A	2	WALK-IN COOLER EVAPORATOR		X	115	1	60	1.8				DN	SEE MANUFACTURE SHOP DRAWINGS
P1A.1	1	WALK-IN COOLER CONDENSER		X	208-230	3	60	9.7		1.5		DN	SEE MANUFACTURER DRAWING FOR DETAILS
P1B	1	WALK-IN FREEZER EVAPORATOR		X	208-230	1	60	5.0				DN	SEE MANUFACTURE SHOP DRAWINGS
P1B.1	1	WALK-IN FREEZER CONDENSER		X	208-230	3	60	6.3		2		DN	SEE MANUFACTURER DRAWING FOR DETAILS
P10	1	MIXER, BENCH		X	120	1	60	11.0		3/4	5-15P	18	
P10A	1	SLICER, FOOD		X	115	1	60	7.0		1/2	5-15P	18	
P13	36	WINE CABINET			115	1	60	4.0	0.5	1/4	5-15P	18	
P22	3	REFRIGERATOR, UNDERCOUNTER, LOW PROFILE			115	1	60	4.0	0.5	1/4	5-15P	18	
P23	2	CUTTER/MIXER, VERTICAL & VEG. PREP, COMBO		X	120	1	60	9.0		1/2	5-15P	48	
P27	1	BAG IN BOX		X	120	1	60	8.0		1/3	5-15P	84	

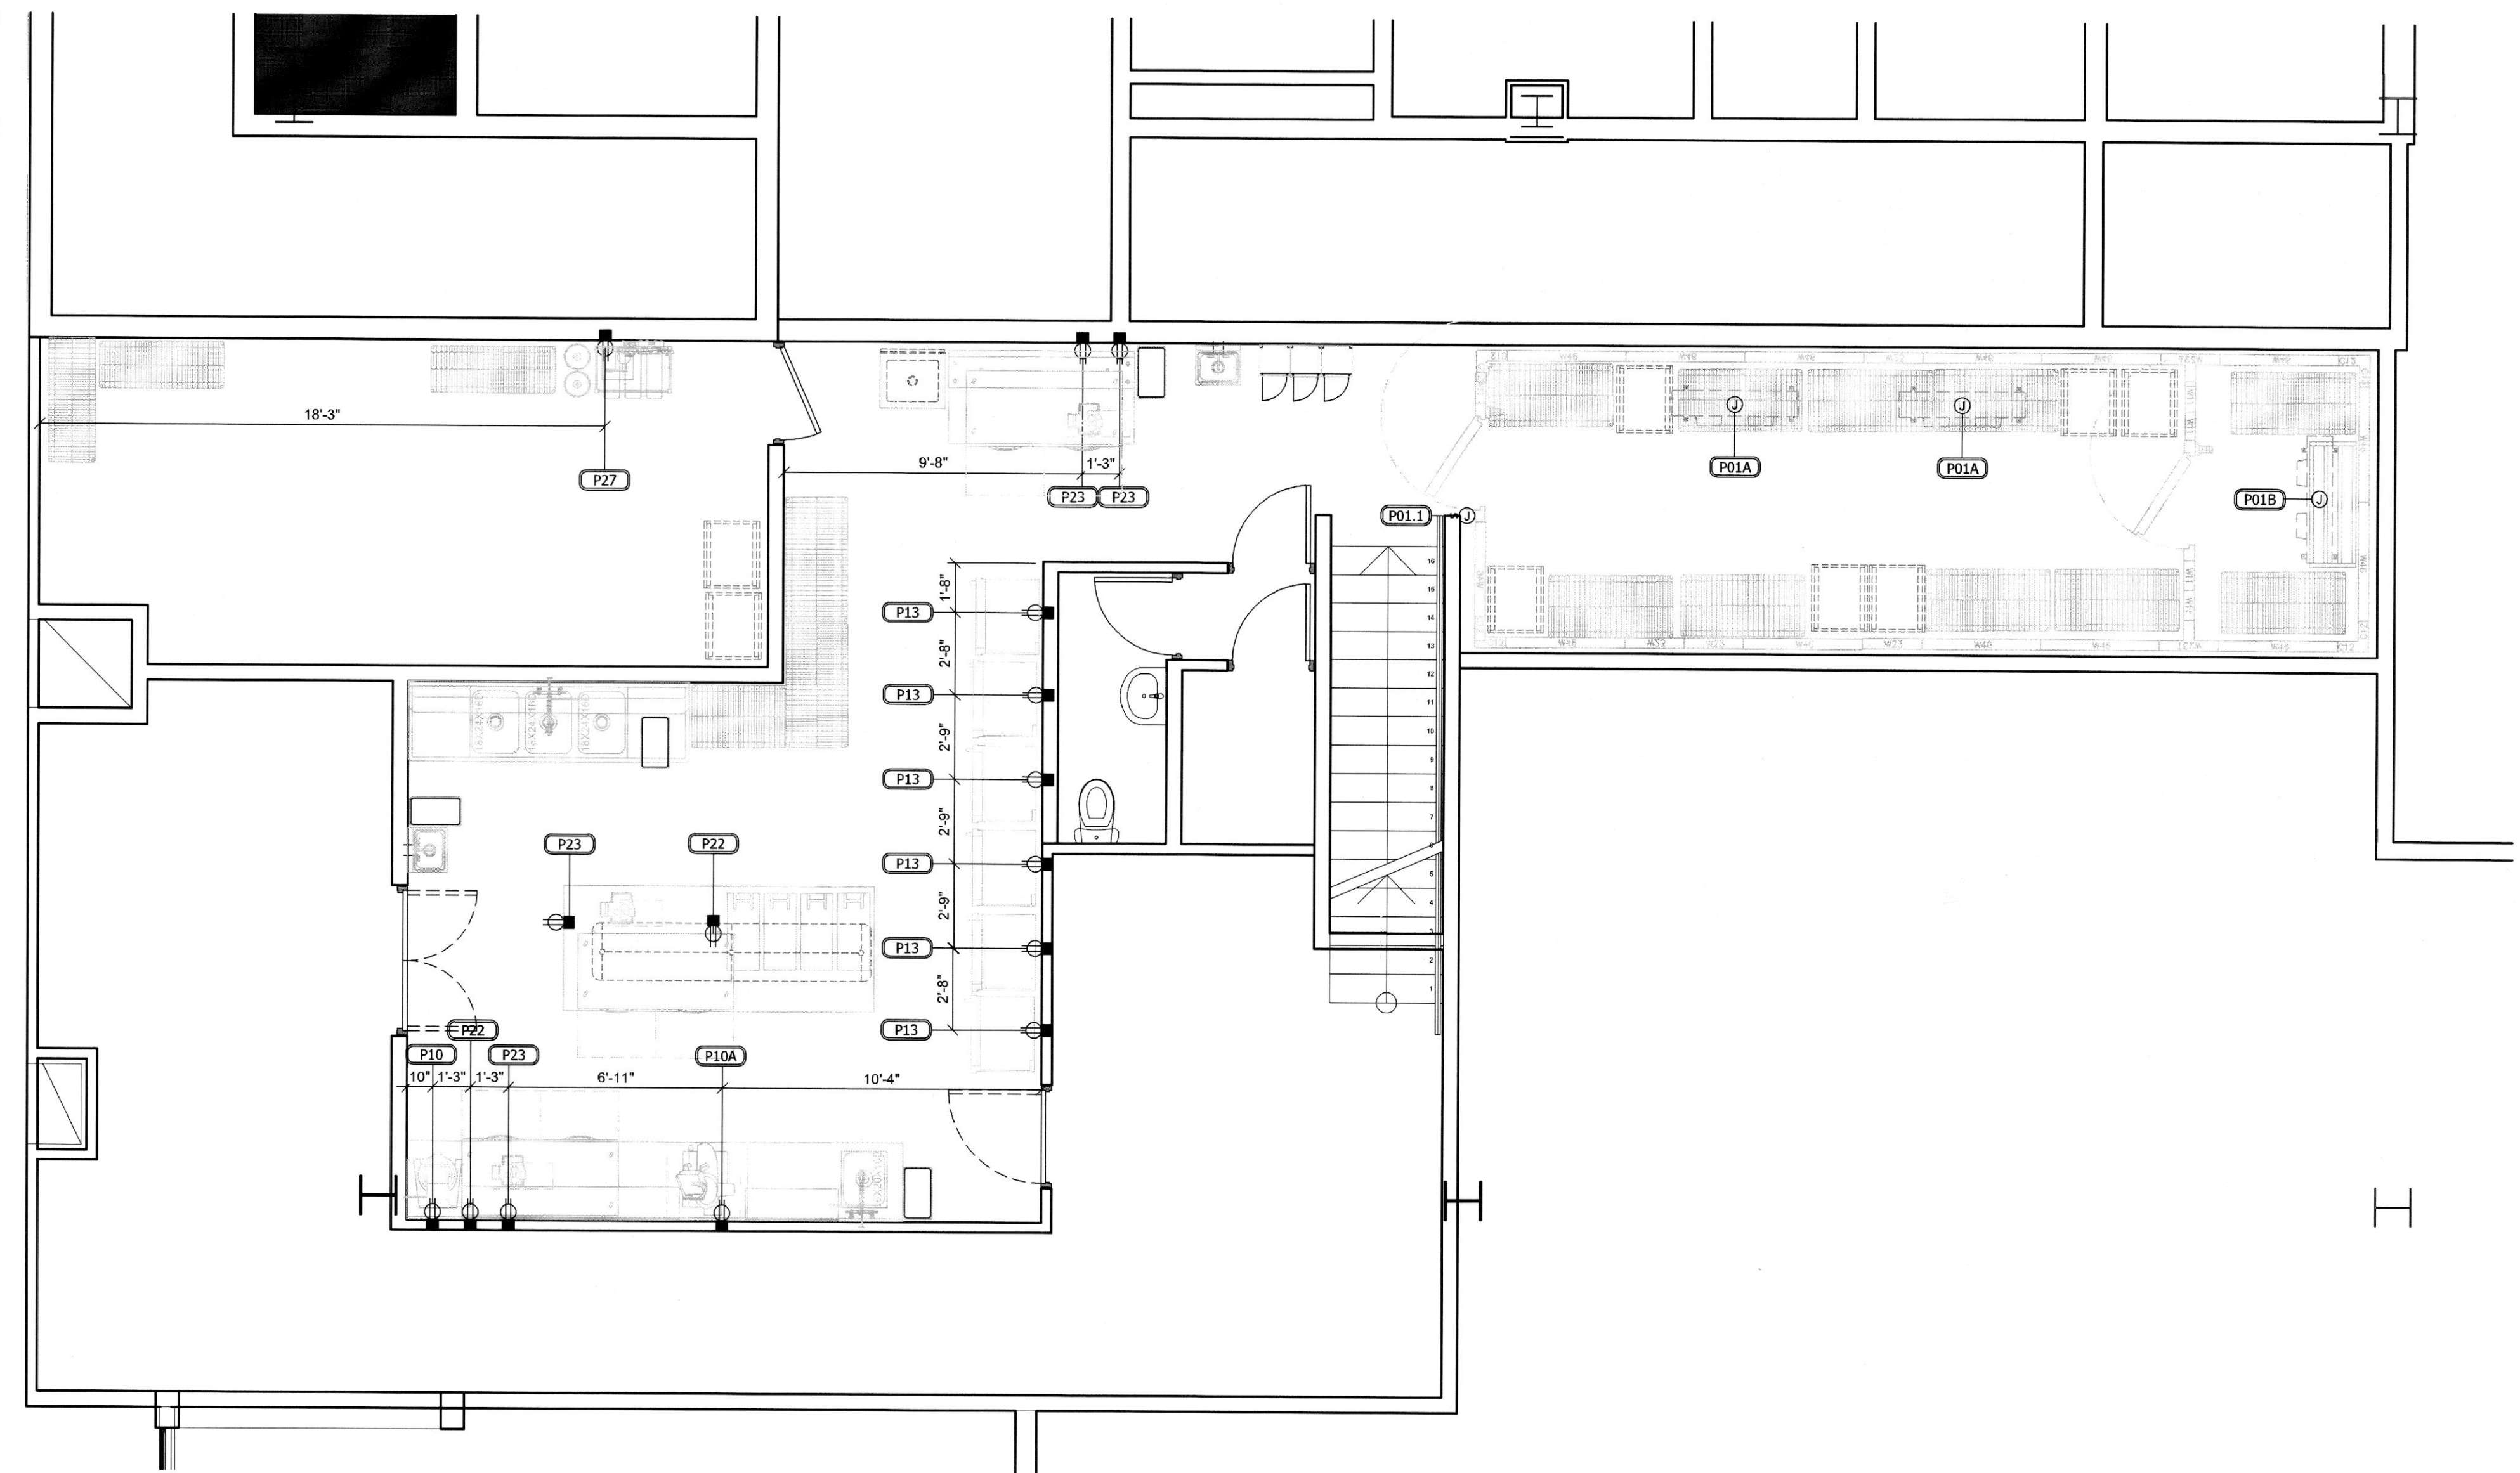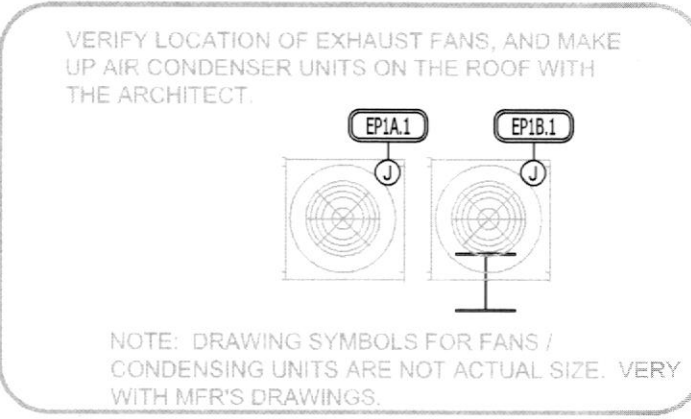

1 MEZZANINE ELECTRICAL ROUGH-IN PLAN & SCHEDULE Scale: 1/4" = 1' 0"

REVISIONS

NUMBER	DATE	DESCRIPTION
1	10/19/18	PER HEALTH DEPARTMENT COMMENTS
2	10/24/18	PER HEALTH DEPARTMENT COMMENTS