


LEGEND			
SYMBOLS	ABBREVIATIONS		
(K)	REFRIGERATION CONNECTION	FS	FLOOR SINK
(CG)	2X2X48 STAINLESS STEEL CORNER GUARD	FT	FLOOR TROUGH
(FP)	FIRE PULL STATION - BY VENDOR	(K)	K-CLASS FIRE EXTINGUISHER - BY OTHERS

SYMBOLS	
---	SODA LINE RUNS / CONDUIT BY OTHERS (BY SODA VENDOR)
---	BEER LINE RUNS / CONDUIT BY OTHERS (BY KITCHEN EQUIPMENT CONTRACTOR)
---	REFRIGERATION LINES (BY KITCHEN EQUIPMENT CONTRACTOR)

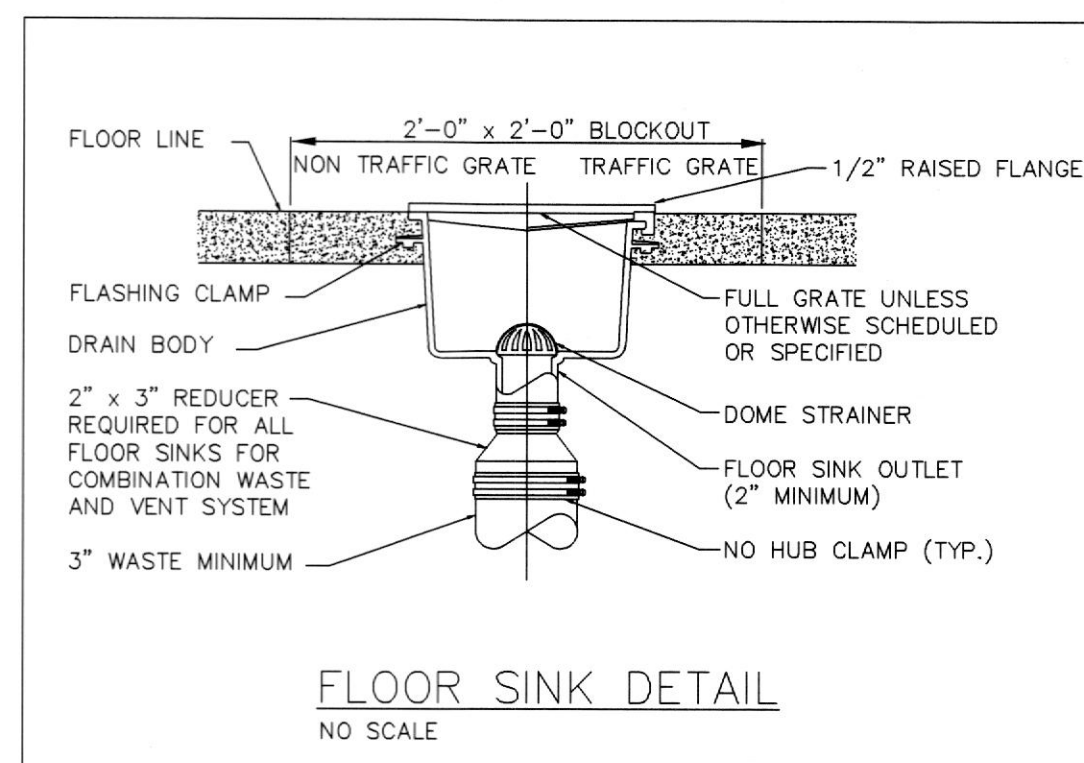


VERIFY LOCATION OF EXHAUST FANS, AND MAKE UP AIR CONDENSER UNITS ON THE ROOF WITH THE ARCHITECT.

NOTE: DRAWING SYMBOLS FOR FANS ARE NOT ACTUAL SIZE. VERY WITH MFR'S DRAWINGS.

City of Houston Texas

18076069
REVIEWED FOR COMPLIANCE

Performance of this review does not relieve the applicant from full responsibility to comply with all applicable codes, ordinances and regulations 10/29/18

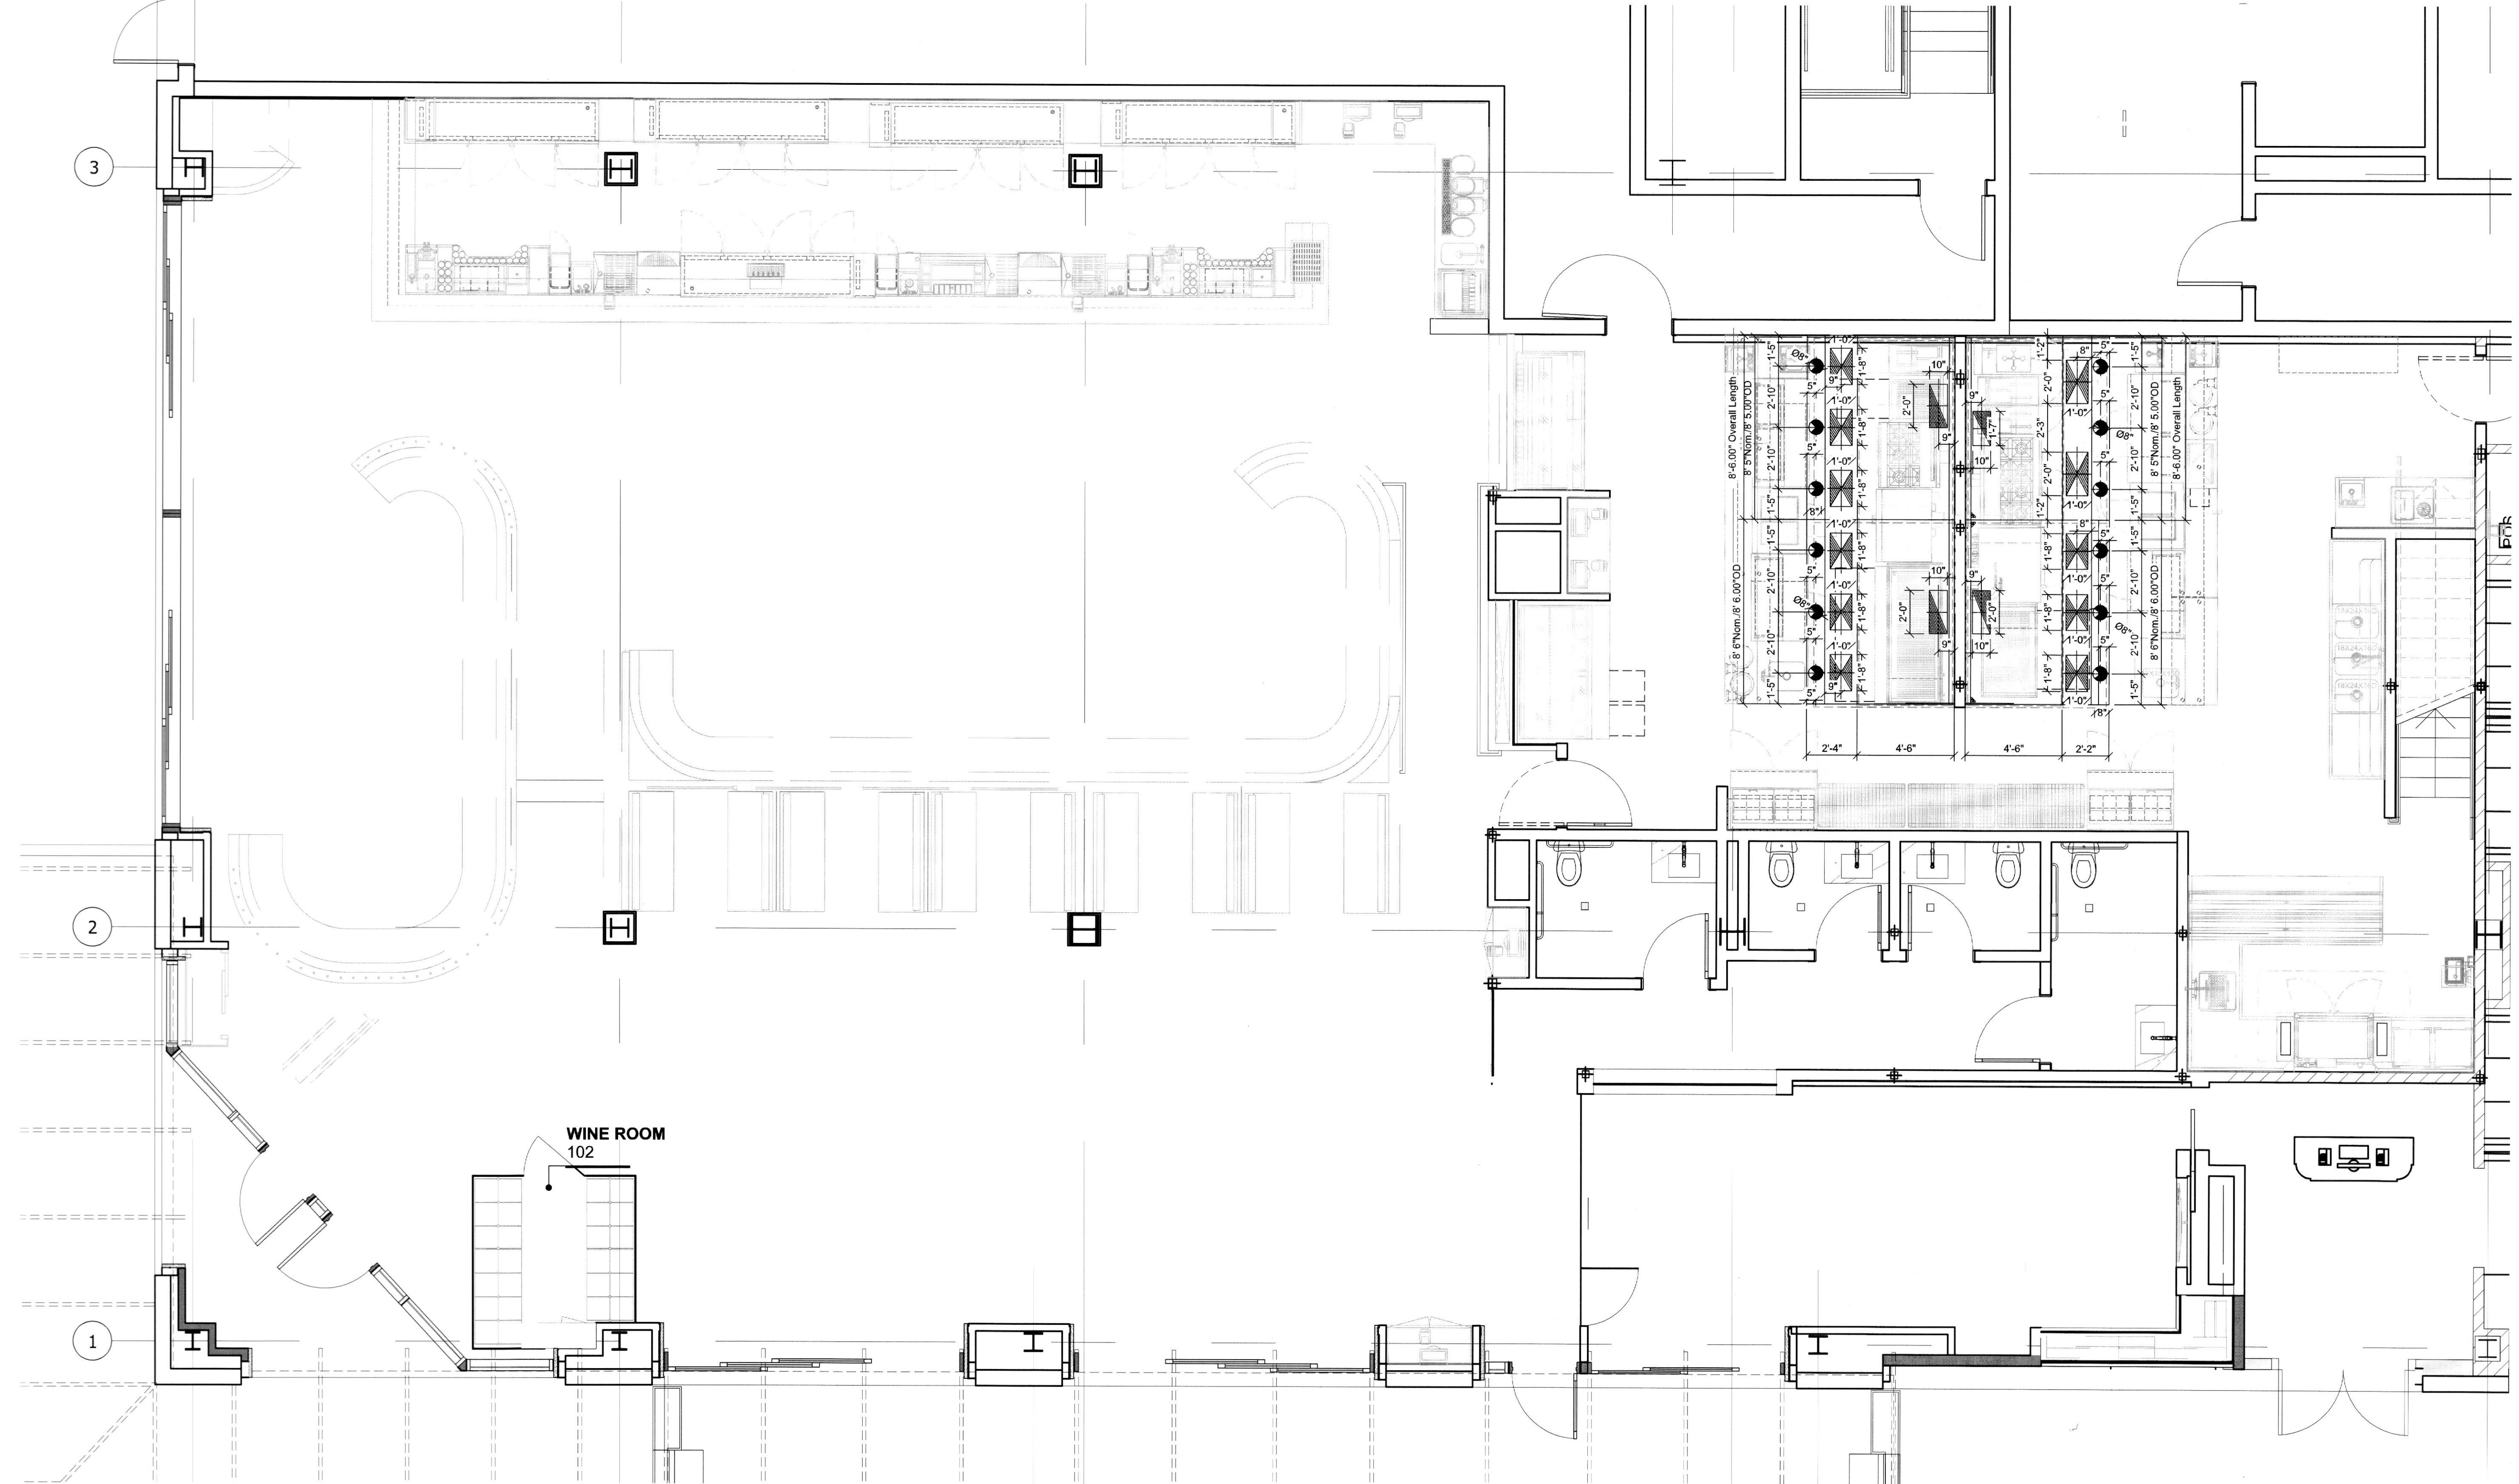

1 OUZO KITCHEN AND BAR VENTILATION PLAN
Scale: 1/4" = 1' 0"

JOHNSON-LANCASTER AND ASSOCIATES, INC.
FOOD SERVICE EQUIPMENT SPECIALIST

13031 US Highway 19 N Clearwater, FL 33764 (727) 796-6822

NUMBER	DATE	DESCRIPTION	REVISIONS
1	10/19/18	PER HEALTH DEPARTMENT COMMENTS	
2	10/24/18	PER HEALTH DEPARTMENT COMMENTS	

OUZO RESTAURANT & LOCH BAR
HOUSTON, TEXAS

DATE:	06/28/2017
SCALE:	1/4" = 1'-0"
DRAWN BY:	JR
DESIGNED BY:	JR
PAPER SIZE:	24x36
SLAB PENETRATION PLAN	
SHEET:	FS-7.0