


ELECTRICAL PACKAGE - Job#3265879

Table with columns: NO., TAG, PACKAGE #, LOCATION, SWITCHES, QUANTITY, OPTION, FANS CONTROLLED, FAN TAG, TYPE, N.P., VOLT, FLA.




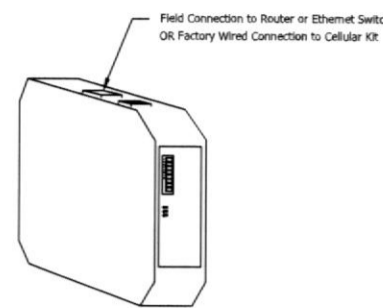


CASLink Monitor and Control

- Hood control panel to support communications to cloud-based Building Management System.
- Hood Control Panel to allow cloud-based Building Management System to monitor real time parameters such as: HOODS IN THE COOKING ETC.
- Hood Control Panel to allow cloud-based Building Management System to control parameters defined as CONTROL in the panel.
- Hood control panel to allow remote changes to system settings such as: VFD frequencies, I/O channels, temperatures set points, fan and motor schedules, etc.

MONITORING AND CONTROL POINTS LIST

Table with columns: DCV Packages, Function, I/O Packages, Function, I/O Packages, Function.

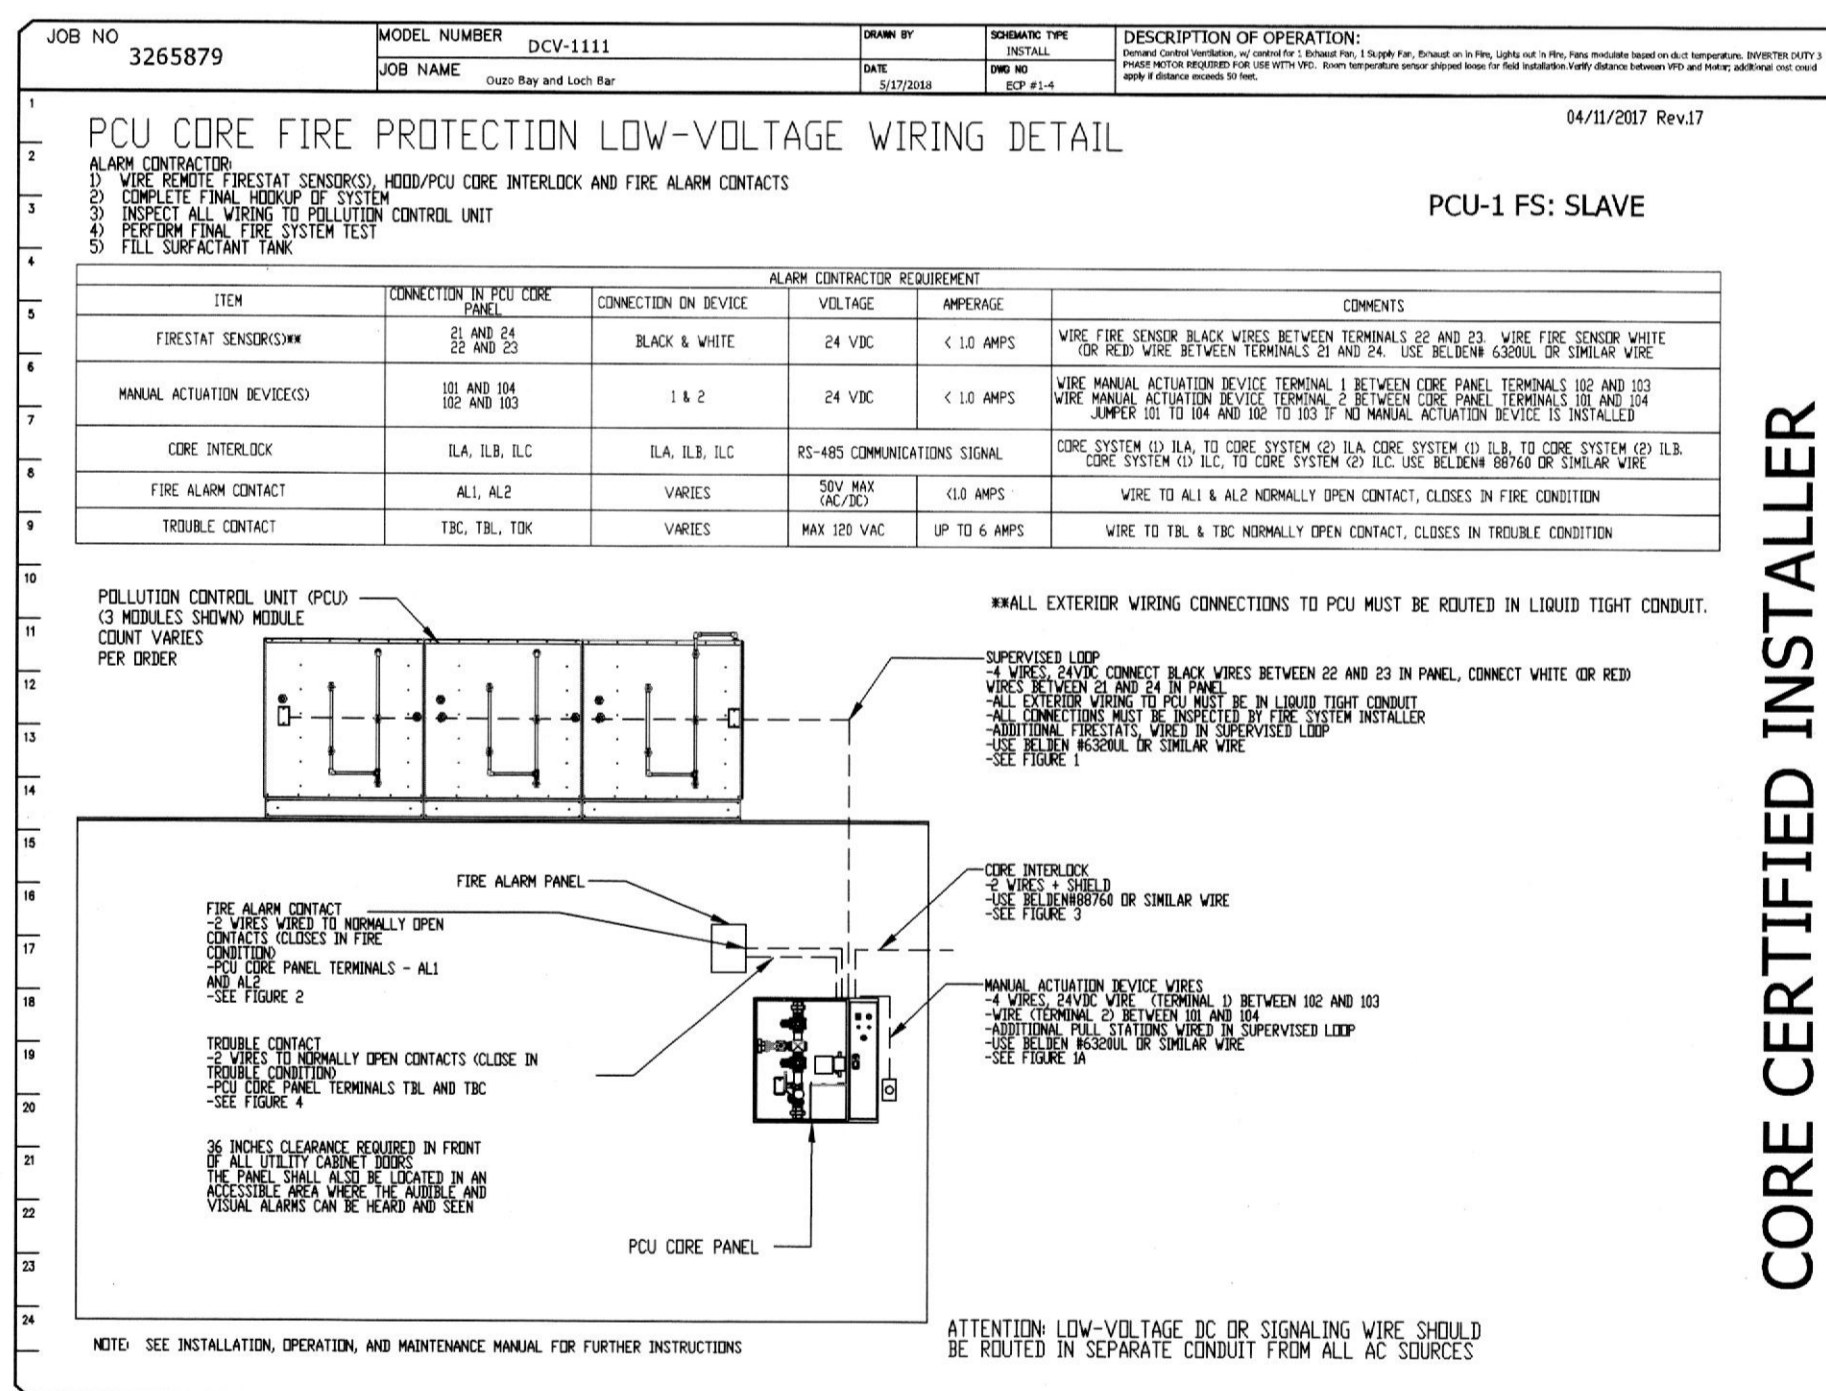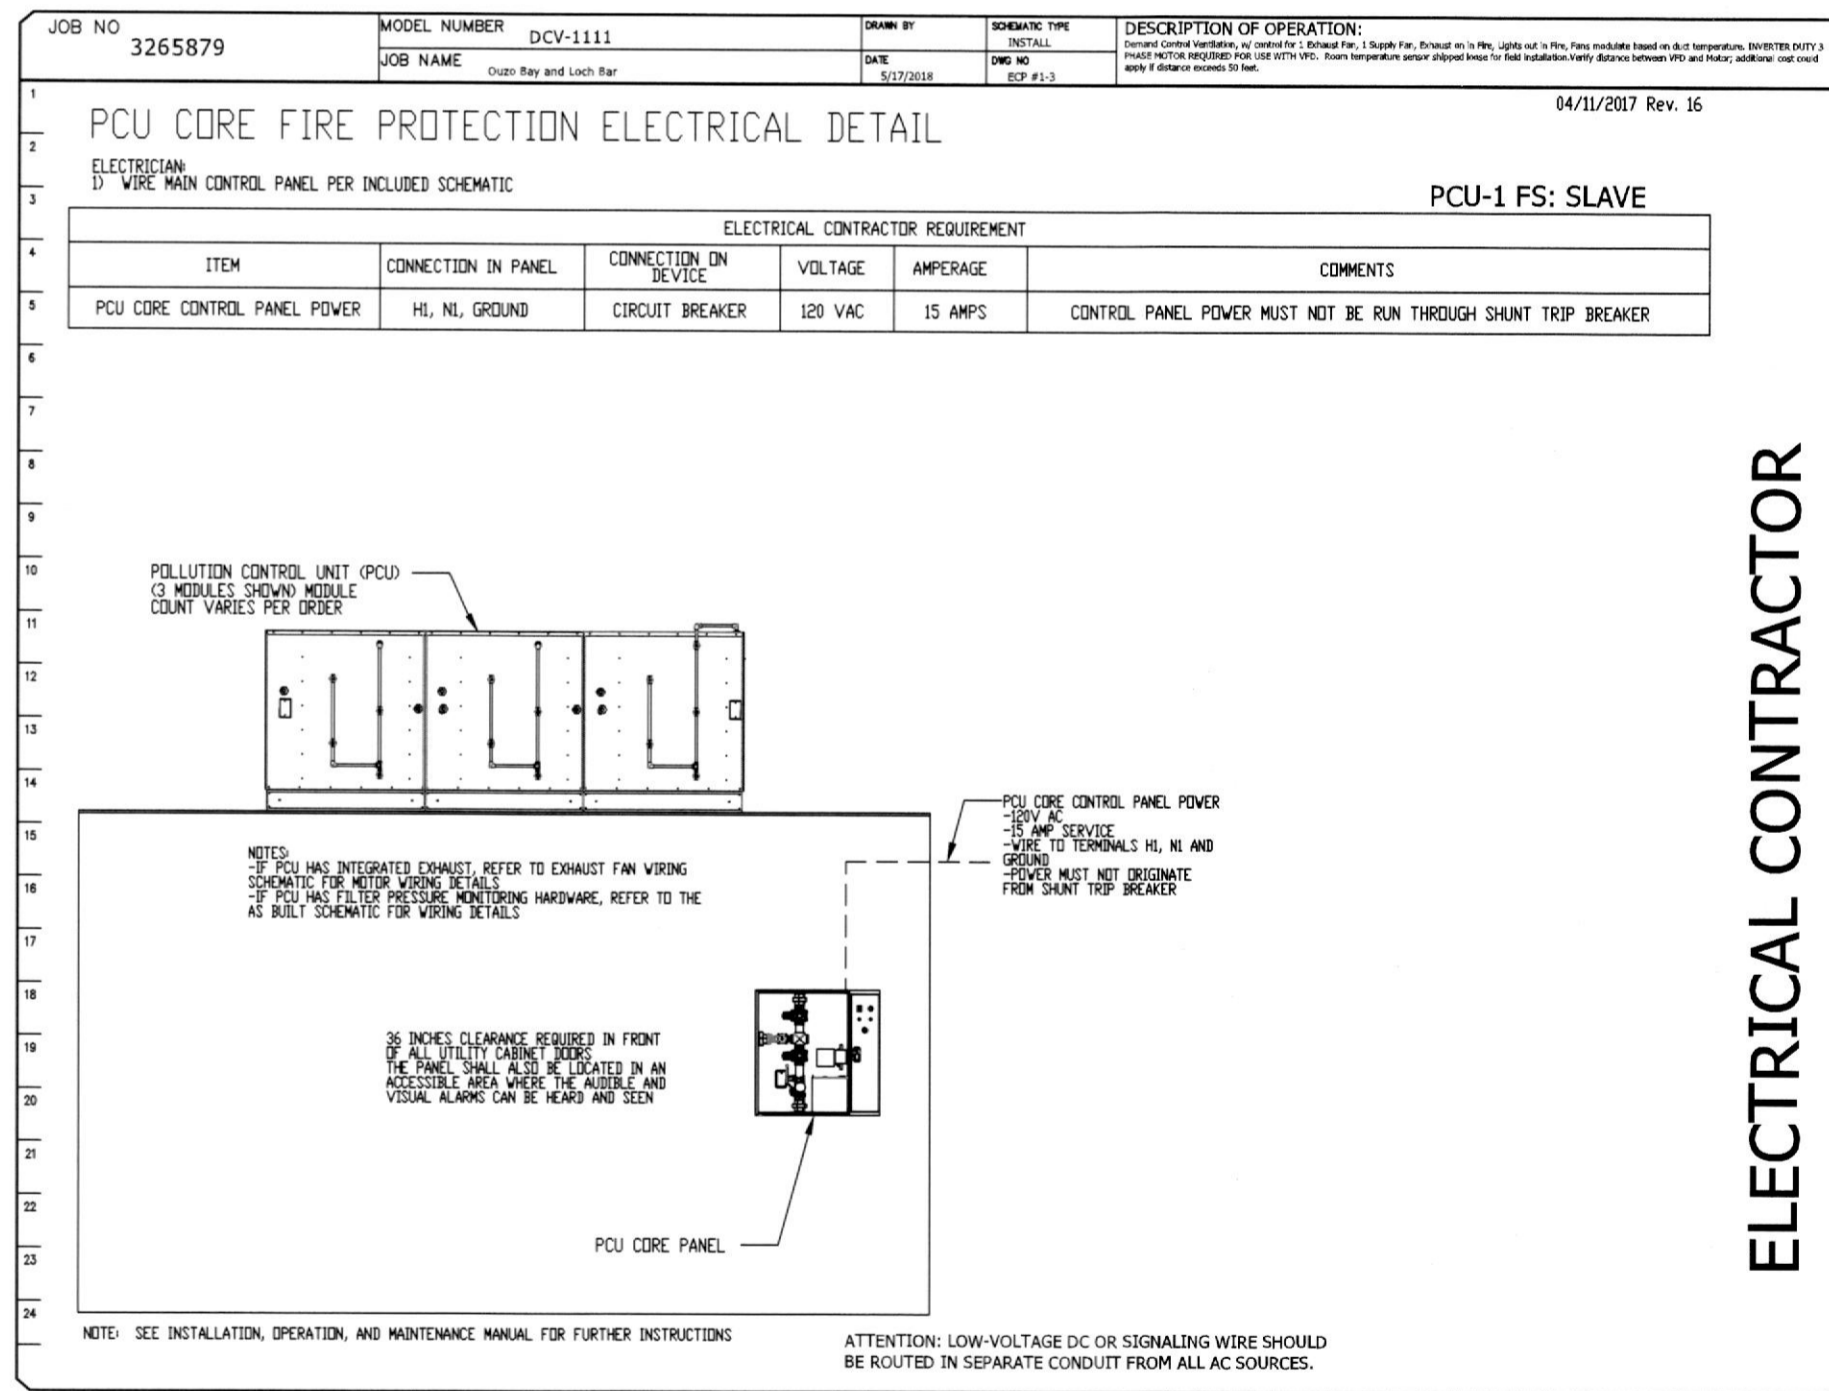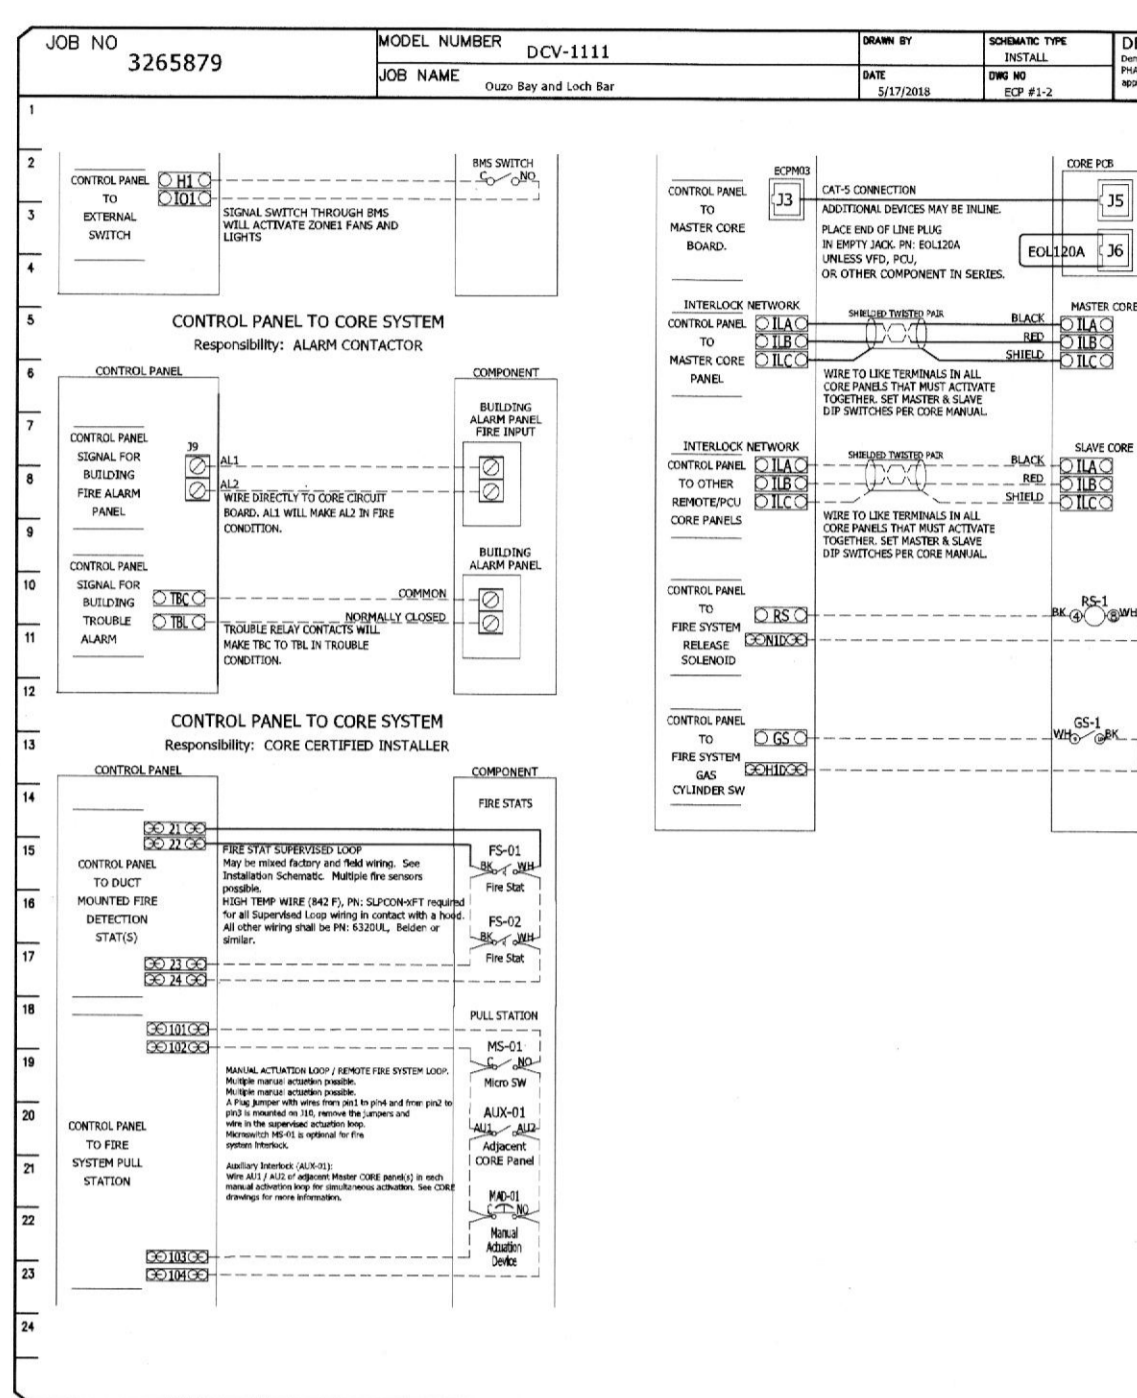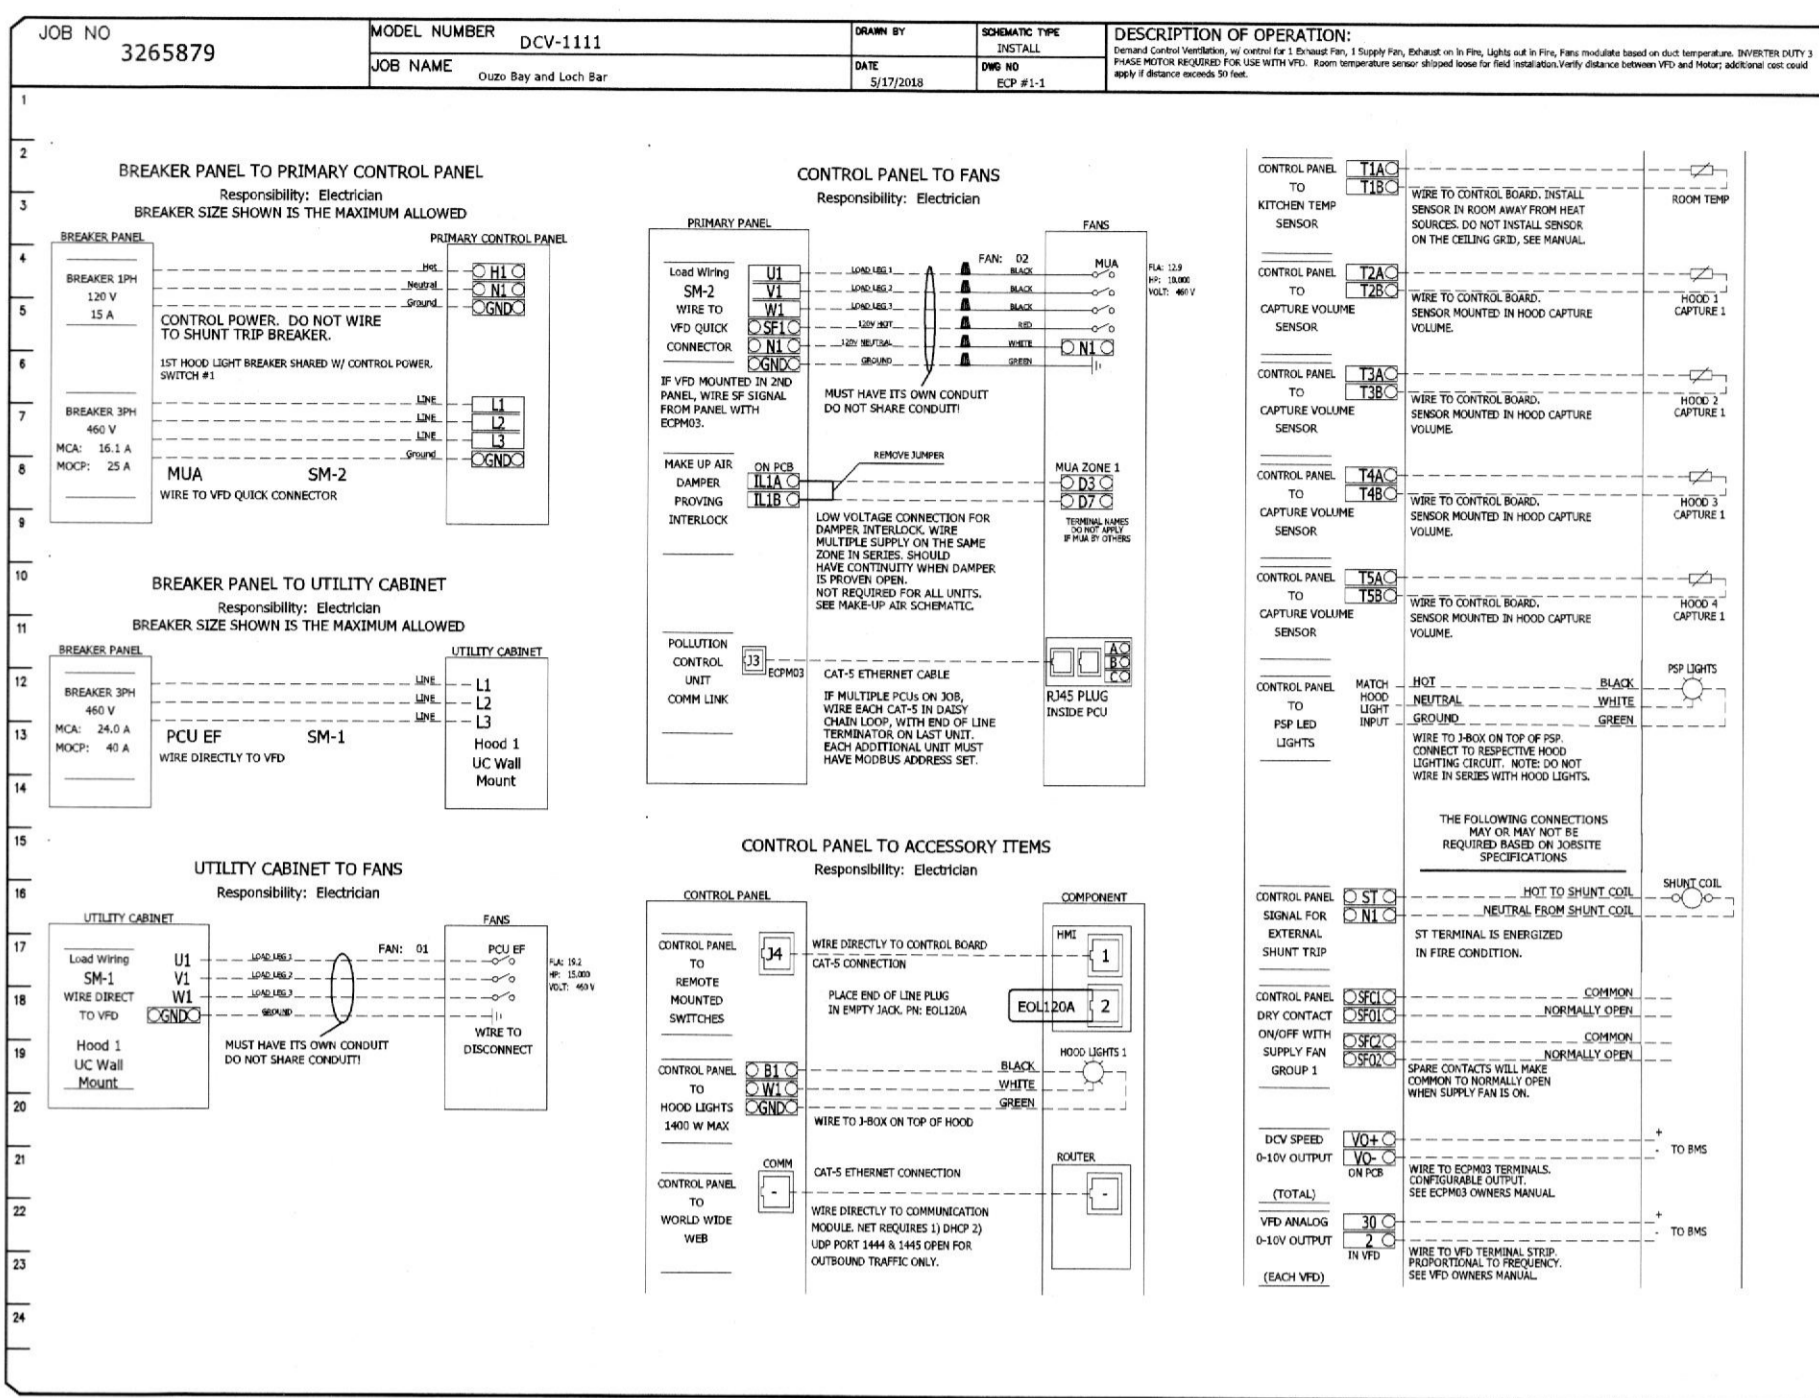

ELECTRICAL CONTRACTOR

CORE CERTIFIED INSTALLER

City of Houston Texas logo and seal, with text: 18076069, REVIEWED FOR COMPLIANCE, Performer of this review does not relieve the applicant from full responsibility to comply with applicable codes, ordinances and regulations. 10/29/18

CAPTIVE Houston Office

Project information: Ouzo Bay and Loch Bar, HOUSTON, TX, 77002. DATE: 5/17/2018, DWG.#: 3265879, DRAWN BY: [Name], SCALE: 3/4" = 1'-0", MASTER DRAWING, SHEET NO. 4

JOHNSON-LANCASTER AND ASSOCIATES, INC. FOOD SERVICE EQUIPMENT SPECIALIST. 13031 US Highway 19 N Clearwater, FL 33764 (727) 796-5622

REVISIONS table with columns: NUMBER, DATE, DESCRIPTION.

OZO RESTAURANT & LOCH BAR HOUSTON, TEXAS