

REFLECTED CEILING PLAN NOTES

1. ALL LAY-IN ACOUSTIC CEILINGS ARE --- ABOVE FINISHED FLOOR, UNLESS OTHERWISE NOTED.
2. ALL GYPSUM SOFFITS AND CEILINGS ARE ---- ABOVE FINISHED FLOOR, UNLESS OTHERWISE NOTED.
3. MOUNT ALL SPRINKLER HEADS, ELECTRICAL DEVICES, LIGHT FIXTURES, ETC. CENTERED IN 2'X2' ACOUSTIC CEILING PANELS, UNLESS OTHERWISE NOTED.
4. CENTER ACOUSTIC CEILING PANELS WITHIN FIELDS AS INDICATED ON REFLECTED CEILING PLANS, PROVIDING NUMBER OF PANELS SHOWN, UNLESS OTHERWISE NOTED.
5. WINDOW TREATMENT AT ALL EXTERIOR CLEAR GLASS LOCATIONS.
6. CEILING MOUNTED EQUIPMENT OMITTED FOR CLARITY. REFER TO MECHANICAL, ELECTRICAL AND PLUMBING DRAWINGS FOR CEILING MOUNTED EQUIPMENT.

Chiang O'Brien ARCHITECTS

PROGRESS PRINT
NOT FOR CONSTRUCTION OR BIDDING

WARNING: It is a violation of New York State Law for any person, unless acting under the direction of a licensed Architect, to alter this document in any way. If a document bearing the seal of an Architect is altered, the altering Architect shall affix to such document his seal and the notation "altered by" followed by his signature, the date of such alteration, and a specific description of the alteration.

FINISH LEGEND


	EXTERIOR - METAL SOFFIT PANEL		EXTERIOR - METAL COMPOSITE PANEL
	2' X 2' ACOUSTICAL PANEL CEILING (ACP-1)		GYPSUM BOARD CEILING
	1 HOUR FIRE RATED CEILING		GYPSUM BOARD SOFFIT
	2 HOUR FIRE RATED CEILING		EXTERIOR - PLASTER CEILING
	2' X 6' ACOUSTICAL PANEL CEILING (ACP-1)		ACOUSTICAL PANEL CEILING (ACP-2)
			RADIAL ACOUSTICAL CEILING PANEL (ACP-3)
			WOOD VENEER PANEL @ LARGE CONFERENCE ROOM (ACP-4)

LIGHT FIXTURE LEGEND

	LINEAR PENDANT LIGHT FIXTURE		SOFFIT MOUNTED LINEAR LIGHT FIXTURES
	LINEAR SURFACE MOUNTED LIGHT FIXTURE		RECESSED COVE LIGHT FIXTURE
	LAY-IN DIRECT/INDIRECT LIGHT FIXTURES		RECESSED CAN LIGHT FIXTURE
	LINEAR LED COVE		PENDANT LIGHT FIXTURE
	SURFACE MOUNTED LIGHT FIXTURES		WALL WASHER LIGHT FIXTURE

REVISION #	REVISION DATE

50% Construction Documents
University Health Services Facility
Cornell University
Ithaca, New York

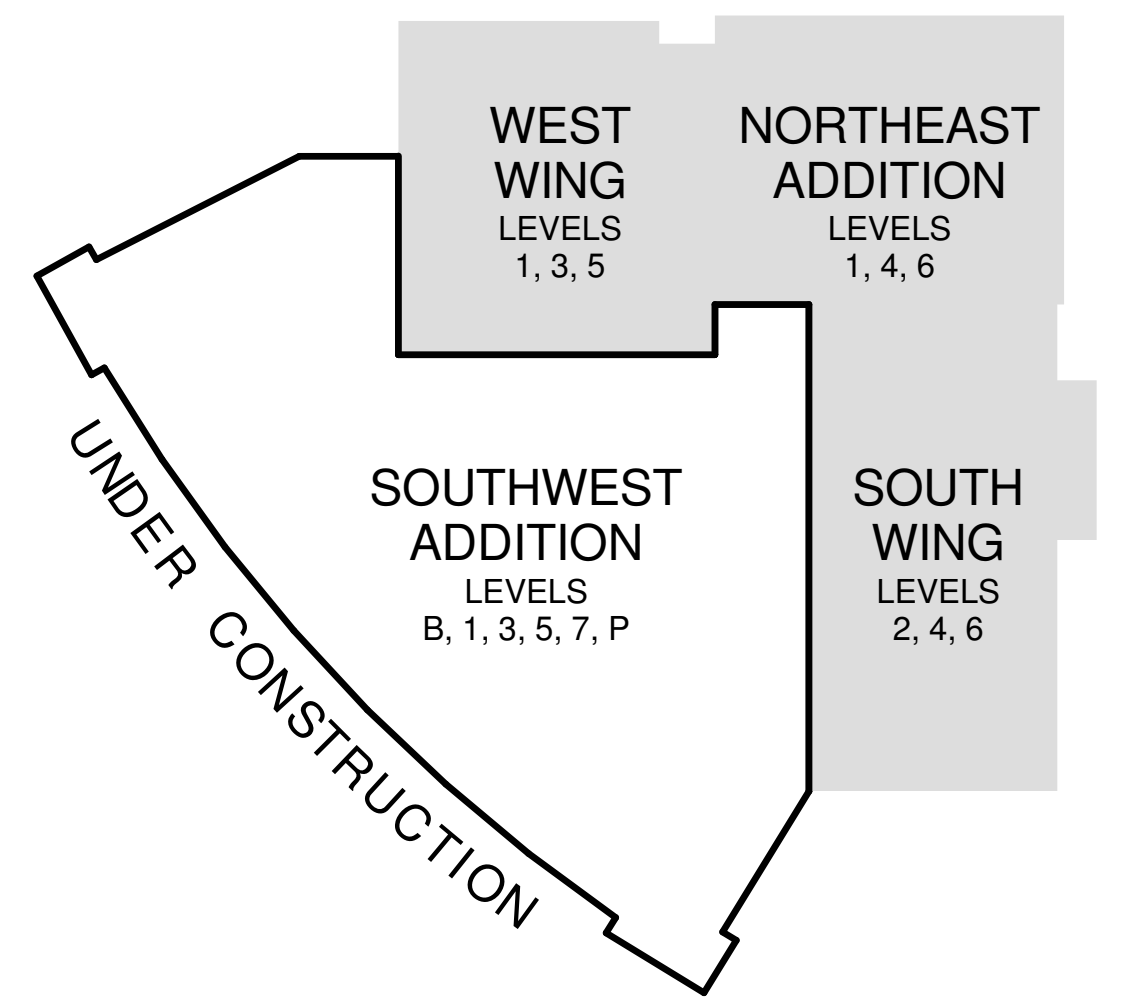

DATE	1 JULY 2014
PROJECT #	1303
BUILDING #	2704
DRAWN BY	RV
SCALE	1/8" = 1'-0"

BASEMENT LEVEL REFLECTED CEILING PLAN
Phase 1 A150