

**1 PART PLAN - LIGHTING 5**  
 E102 SCALE: 1/4"=1'-0"

**DRAWING NOTES:**


1. ALL ELECTRICAL ITEMS IN THIS AREA ARE EXISTING TO REMAIN UNLESS SHOWN OR OTHERWISE NOTED.
2. REPLACE EXISTING VACANCY SWITCH WITH NEW SNAP SWITCH.
3. RELOCATED 3WAY SWITCH RECONNECT TO EXISTING LIGHTS AS REQUIRED.
4. RECONNECT TO EXISTING BRANCH CIRCUIT PRIOR TO DEMOLITION.
5. REWORK AND ADJUST LOCATIONS OF EXISTING EGRESS EMERGENCY LIGHTING AND EXIT SIGNS WITH UPDATED ARCHITECTURAL LAYOUT.

**LIGHTING FIXTURE SCHEDULE**

TYPE	LAMPS	INPUT WATTS	MOUNTING	DESCRIPTION	VOLTS	CATALOG NO.
A	LED 1000 LUMENS 3500K	14.2W	CEILING RECESSED	6" LED DOWNLIGHT WITH WHITE MATTE FINISH. SUITABLE FOR WET LOCATION.	120V	LITHONIA # REALC06-MW-ESL-1000L-35K-65SC-LP6LN
⊗	LED	1.0W	UNIVERSAL (TOP, END BACK)	LED EMERGENCY EXIT SIGN WITH WHITE HOUSING AND INTEGRAL BATTERY / CHARGER REFER TO FLOOR PLANS FOR MOUNTING AND LOCAL CODES FOR COLOR OF LETTERS. SEE NOTE 2 BELOW.	120/277V	LITHONIA LOM SERIES
⊕	2-1.5W LED	1.4W	SURFACE WALL OR CEILING	6 VOLT LED EMERGENCY BATTERY LIGHT WITH TWIN LAMPS, WHITE THERMOPLASTIC HOUSING AND INTEGRAL LEAD CALCIUM BATTERY AND CHARGER. SEE NOTE 2 BELOW	120/277V	LITHONIA # QUANTUM SERIES ELM2LED

**NOTE:**


1. ALL LIGHTING FIXTURES SHALL BE APPROVED BY THE OWNER AND ARCHITECT PRIOR TO ORDERING.
2. MATCH EXISTING FIXTURES INSTALLED UNDER BASE PROJECT.

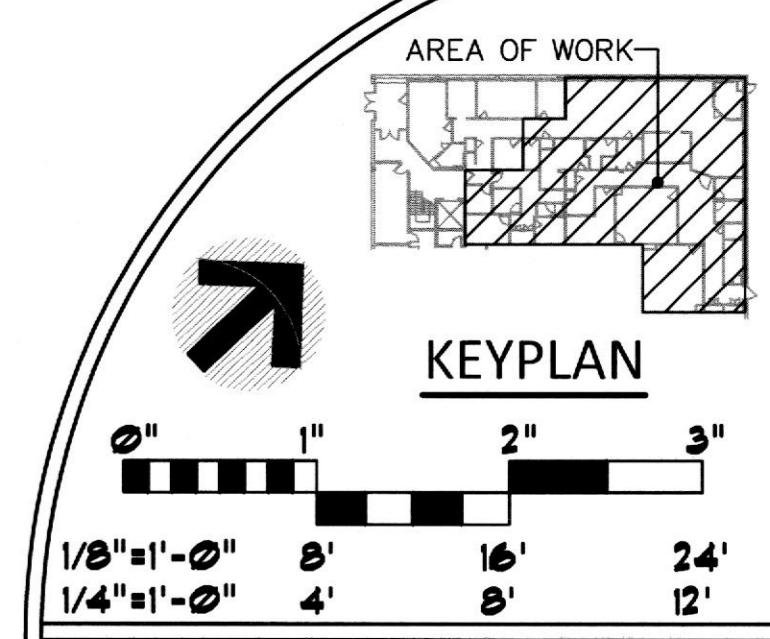

**LIGHTING PART PLAN**

REVISIONS		DRAWING NO.
REV#	DATE	DESCRIPTION
-	10/20/17	PERMIT SET
SHEET OF 5		E102.00
DATE DRAWN BY		10/20/17 JCW
JOB NUMBER ORDERED BY		112-41 MSW

ISSUED FOR  
BUILDING PERMIT

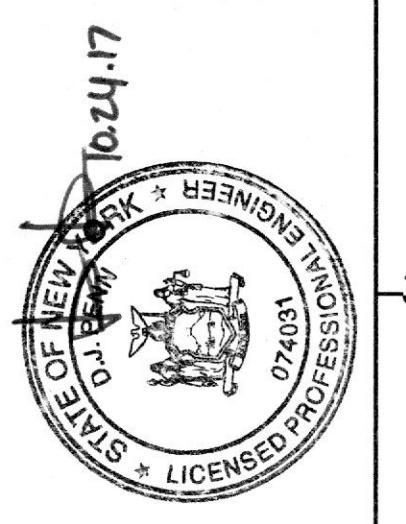

DPCE  
DON RYAN CONSULTING ENGINEER  
1301 SCLAMAN BLVD.  
WESTLAKE, NY 10992  
0817-410-2858 F 817-251-8411

TENANT RENOVATIONS FOR:  
**LIFELINE ACCESS CENTER**  
1733 Eastchester Road  
Bronx, NY 10461



**InSync**  
ARCHITECTURAL DESIGNS, INC.  
1219 Old Pylesville Road Whiteford, MD 21160  
Office 410-452-8006 Fax 410-452-8046

