

FLOOR PLAN - POWER  
SCALE: 1/4"=1'-0"

PROTECTIVE BOLLARD  
SEE DETAIL (TYP)  
EMERGENCY DIESEL GENERATOR  
LOCATED IN PARKING LOT.  
REFER TO RISER DIAGRAM AND  
SPECIFICATIONS. COORDINATE  
EXACT LOCATION WITH BUILDING  
OWNER

NURSE CALL SYSTEM			
TYPE	LOCATION	DESCRIPTION/VOLTAGE	CAT. #
EP	PATIENT PREP/ PATIENT RECOVERY SINGLE GANG BACK BOX 48" AFF	HAND HELD CALL CHORD WITH RESET BUTTON AT WALL. SEPARATE EMERGENCY CALL ACTIVATED BY REMOVAL OF PENDANT CHORD FROM WALL PANEL (PREFERRED), OR SEPARATE WALL BUTTON PROVIDE CEILING MOUNTED INDICATION LIGHT IMMEDIATELY OUTSIDE CUBICLE CURTAIN TRACK AT EACH RECOVER/PREP POSITION.	EXPEDITOR NCCB SERIES
EP	PATIENT TOILET/ PATIENT DRESSING THO GANG BACK BOX ROTATED 90° 48" AFF	WALL MOUNTED CALL SWITCH ACTIVATED BY PULL ON CHORD. PULL MUST NOT BE GANCELED BY SECOND OR REPEATED PULL ON CHORD. PROVIDE RESET BUTTON ABOVE CHORD ATTACHMENT, OR SIMILAR SEPARATE RESET PROVISION. PROVIDE WALL OR CEILING MOUNTED INDICATION LIGHT/TONE DEVICE OUTSIDE DOOR. LOCATE TO MAXIMIZE STAFF VISIBILITY/NOTIFICATION.	EXPEDITOR NCCB SERIES
EP	PROCEDURE ROOM SINGLE GANG BACK BOX 48" AFF	EMERGENCY CALL ("CODE BLUE"), WALL MOUNTED CALL BUTTON WITH HINGED "ELBOW PLATE" TO FACILITATE EMERGENCY ACTIVATION. PUSH ONCE TO INITIATE CALL, PUSH SECOND TIME TO CANCEL (ALL OFF). PROVIDE WALL OR CEILING MOUNTED INDICATION LIGHT/TONE DEVICE OUTSIDE OF DOOR IDENTIFYING TYPE OF CALL, LOCATED TO MAXIMIZE STAFF VISIBILITY/NOTIFICATION.	EXPEDITOR P-1C SERIES
EP	NURSE CONTROL/ SITE MANAGER/ NURSE CONSULTANT/ STAFF LAUNGE BACK BOX FURNISHED BY EXPEDITOR INSTALLED BY ELECT. CONTR. 48" AFF	5 KEY ROOM STATUS PANEL WITH TONE, SHOWS WHICH ROOMS ARE OCCUPIED, STAFF LOCATION, WHICH PATIENTS ARE NEXT, WHERE ASSISTANCE IS NEEDED OR WHERE A SPECIAL PROCEDURE IS REQUIRED.	EXPEDITOR P-6C SERIES
EP	BUSINESS BACK BOX FURNISHED BY EXPEDITOR INSTALLED BY ELECT. CONTR. 48" AFF	5 KEY ROOM STATUS PANEL WITH TONE, SHOWS WHICH ROOMS ARE OCCUPIED, STAFF LOCATION, WHICH PATIENTS ARE NEXT, WHERE ASSISTANCE IS NEEDED OR WHERE A SPECIAL PROCEDURE IS REQUIRED.	EXPEDITOR P-6C SERIES
EP	PROCEDURE ROOM THO GANG BACK BOX 12" AFF BELOW CB DEVICE	KICK PLATE	EXPEDITOR KP-1 SERIES
EP	COMPUTER ROOM	CENTRAL PROCESSING UNIT (CPU); CONTROLS ALL LIGHT PANEL FUNCTIONS. REQUIRES (1) SINGLE LINE (R-J-1C) TELEPHONE JACK AND (1) DEDICATED POWER OUTLET.	EXPEDITOR

**DRAWING NOTES**

- MOUNT ON ROOF NEAR MECHANICAL UNIT FOR MAINTENANCE
- PROVIDE A FLUSH MOUNTED REMOTE GENERATOR ANNUNCIATOR PANEL. COORDINATE LOCATION WITH CABINETS.
- PROVIDE "HOSPITAL" GRADE RECEPTACLES IN ALL "PATIENT CARE" AREAS PER NEC 517.
- PROVIDE 1" EMPTY CONDUIT FROM TV SHELF DOWN TO BASE CABINET BELOW FOR VCR CABLING. COORDINATE MOUNTING HEIGHTS WITH ARCHITECTURAL ELEVATIONS.
- PROVIDE A FLUSH MOUNTED JUNCTION BOX WITH 3/4" CONDUIT TO CEILING PLENUM SPACE FOR LOW VOLTAGE EQUIPMENT WIRING. VERIFY LOCATION.
- EXPEDITOR NURSE CALL SYSTEM DEVICE LOCATION. CONTRACTOR SHALL FURNISH AND INSTALL COMPLETE NURSE CALL SYSTEM. PROVIDE CONDUIT FROM EACH OUTLET LOCATION TO CEILING SPACE ABOVE. COORDINATE ALL WORK WITH OWNER'S VENDOR, EXPEDITOR SYSTEMS (1-800-943-4651). REFER TO SCHEDULE ON THIS SHEET. COORDINATE ALL LOCATIONS WITH OWNER.
- MOUNT "IN USE" SIGN OVER DOOR AND INTERLOCK WITH DOOR CONTACT SWITCH SO THAT SIGN ENERGIZES WHEN DOOR IS CLOSED. DOOR SWITCH TO BE EDWARDS #503A.
- MOUNT RECEPTACLE BELOW SINK TO SERVE INFA-RED AUTOMATIC FACET.
- CONTROL WIRING AND DEVICES FURNISHED AND INSTALLED BY AUTOMATIC TEMPERATURE CONTROL (ATC) CONTRACTOR
- 4"x8"x3/4" FIRE RETARDANT PLYWOOD BACKBOARD FOR COMPUTER EQUIPMENT, NURSE CALL SYSTEM AND TELEPHONE SERVICE
- COORDINATE MOUNTINGS OF SIGN WITH SIGN VENDOR AND OWNER


NEW PANEL EP 10,000 A.I.C. FLUSH			
DESCRIPTION	B	C	DESCRIPTION
ACCU-1	20	1	2 20 RECEPTACLES
AHU-1	45	5	4 20 RECEPTACLES
ACCU-2	20	11	10 20 RECEPTACLES
AHU-2	45	13	14 20 RECEPTACLES
BATTERY CHARGER	20	17	18 20 RECEPTACLES
GENERATOR HTR.	20	19	20 20 RECEPTACLES
LIGHTING	20	21	22 20 RECEPTACLES
LIGHTING	20	23	24 20 RECEPTACLES
LIGHTING	20	25	26 20 RECEPTACLES
LIGHTING	20	27	28 20 RECEPTACLES
GENERATOR CONTROL	20	29	30 20 NURSE CALL
MOD'S	20	31	32 20 FACP
EXHAUST FAN	20	33	34 20 FACP
SPACE	20	35	36 20 SPACE
SPACE	-	37	38 - SPACE
SPACE	-	39	40 - SPACE
SPACE	-	41	42 - SPACE

\* PROVIDE LOCK CLIP ON CIRCUIT BREAKER

** PANEL ME 10,000 A.I.C. SURFACE			
DESCRIPTION	B	C	DESCRIPTION
EXIST. GAS RTU-1	45	3	45 EXIST. GAS RTU-2
FCU-1 (HEAT)	35	9	HP-1 (A/C)
DUCT HEATER	30	15	30 DUCT HEATER
SPACE	20	19	20 DUCT HEATER
SPACE	20	21	22 20 DUCT HEATER
SPACE	-	23	24 - SPACE
SPACE	-	25	26 - SPACE
SPACE	-	27	28 - SPACE
SPACE	-	29	30 - SPACE
SPACE	-	31	32 - SPACE
SPACE	-	33	34 - SPACE
SPACE	-	35	36 - SPACE
SPACE	-	37	38 - SPACE
SPACE	-	39	40 - SPACE
SPACE	-	41	42 - SPACE

EX. PANEL LP			
DESCRIPTION	B	C	DESCRIPTION
LIGHTING	20	1	2 20 RECEPTACLES
LIGHTING	20	3	4 20 DISHWASHER
LIGHTING	20	5	6 20 REFRIGERATOR
LIGHTING	20	7	8 20 RECEPTACLES
RECEPTACLES	20	9	10 20 RECEPTACLES
RECEPTACLES	20	13	14 20 RECEPTACLES
COPIER	20	15	16 20 RECEPTACLES
RECEPTACLES	20	17	18 20 RECEPTACLES
WATER HEATER	30	19	20 20 RECEPTACLE-TELE.
WALL HEATERS	30	23	24 20 EXTERIOR SIGN
UNIT HEATER	20	25	26 20 WALL HEATERS
SPACE	20	31	32 20 UNIT HEATER
SPACE	20	33	34 20 BASEBOARD HEAT
SPACE	20	35	36 20 SPACE
SPACE	20	37	38 20 EXTERIOR SIGN
PANEL ME	50	39	40 25 PANEL EP
	41	42	

\* PROVIDE LOCK CLIP ON CIRCUIT BREAKER

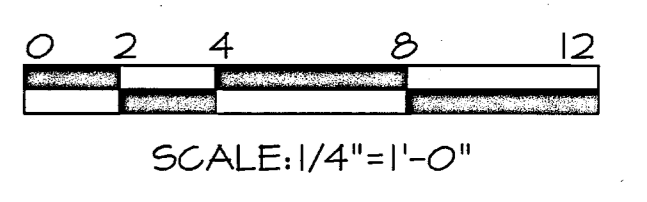

REV#	DATE	DESCRIPTION

**dp**  
DON PENN  
CONSULTING ENGINEERS  
3950 HIGHWAY 380, SUITE 101  
GRAPEVINE, TEXAS 75051  
817-410-2855 FAX 817-251-8411

**F**  
FREDRICK WARD ASSOCIATES, INC.  
P.O. Box 727, 5 South Main Street, Bel Air, Maryland 21014-0727  
Phone: 410-879-2090 or 410-838-7900 Fax: 410-893-1243  
Columbia, Maryland Warrenton, Virginia

TENANT RENOVATIONS FOR  
**RMS LIFE LINE**  
WALL STREET AND WESLEY AVENUE  
NORWOOD, OHIO

DATE	9/26/01	DRAWING NO.	E2
SCALE	AS NOTED	SHEET 2 OF 4	2011215.00
DESIGNED BY	MJJB	DATE	2011215.00
DRAWN BY	MJJB	JLR#	1-100b