


FLOOR PLAN - LIGHTING
SCALE: 1/4"=1'-0"

ONE SWITCH CONTROLS ONE TRACK HEAD. VERIFY LOCATION WITH OWNER


ONE SWITCH CONTROLS ONE TRACK HEAD. VERIFY LOCATION WITH OWNER

GENERAL NOTES

1. ALL LIGHTING FIXTURES ARE TYPE 'A' UNLESS OTHERWISE NOTED.
2. CONNECT EXIT SIGNS, EMERGENCY BATTERY UNITS AND NIGHT LIGHTS (NL) TO THE UNSWITCHED PORTION OF THE LIGHTING CIRCUIT SERVING THAT RESPECTIVE AREA.

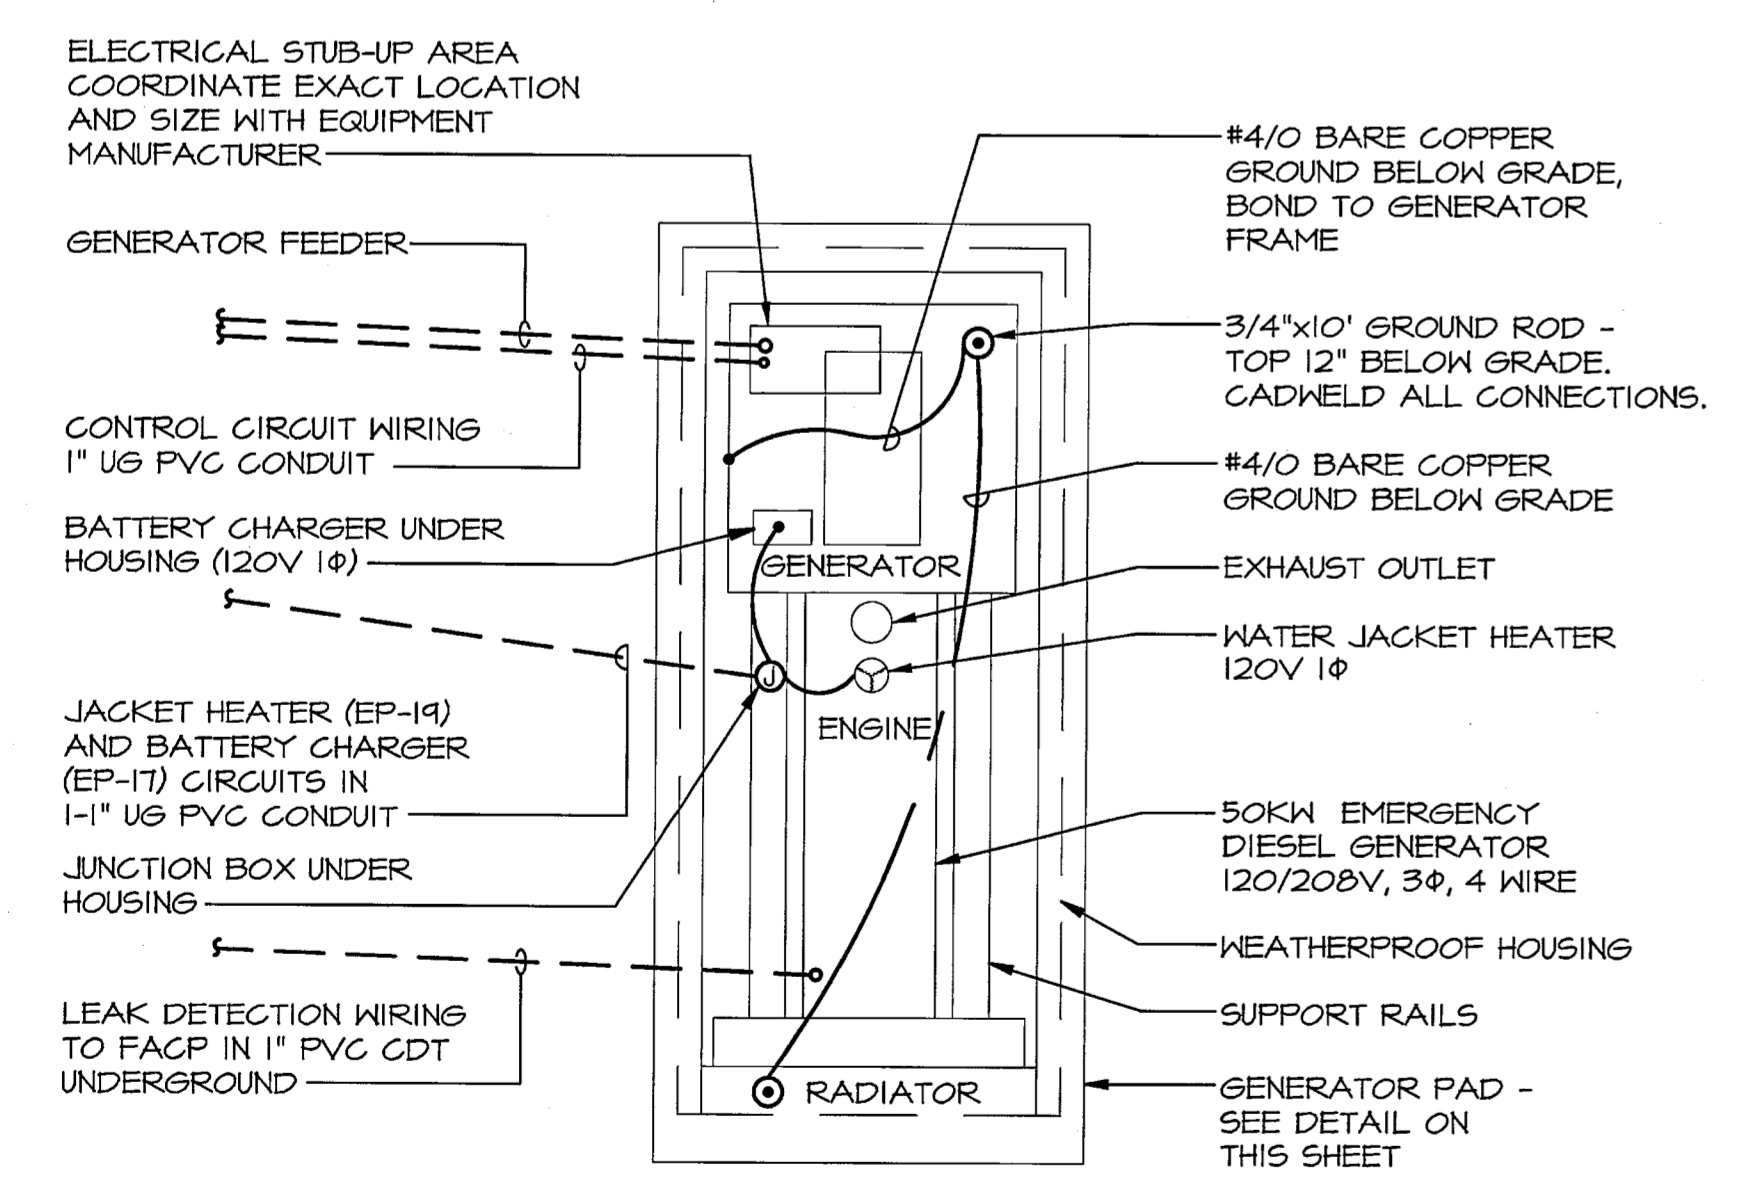


DETAIL - GENERATOR CONNECTIONS
NO SCALE

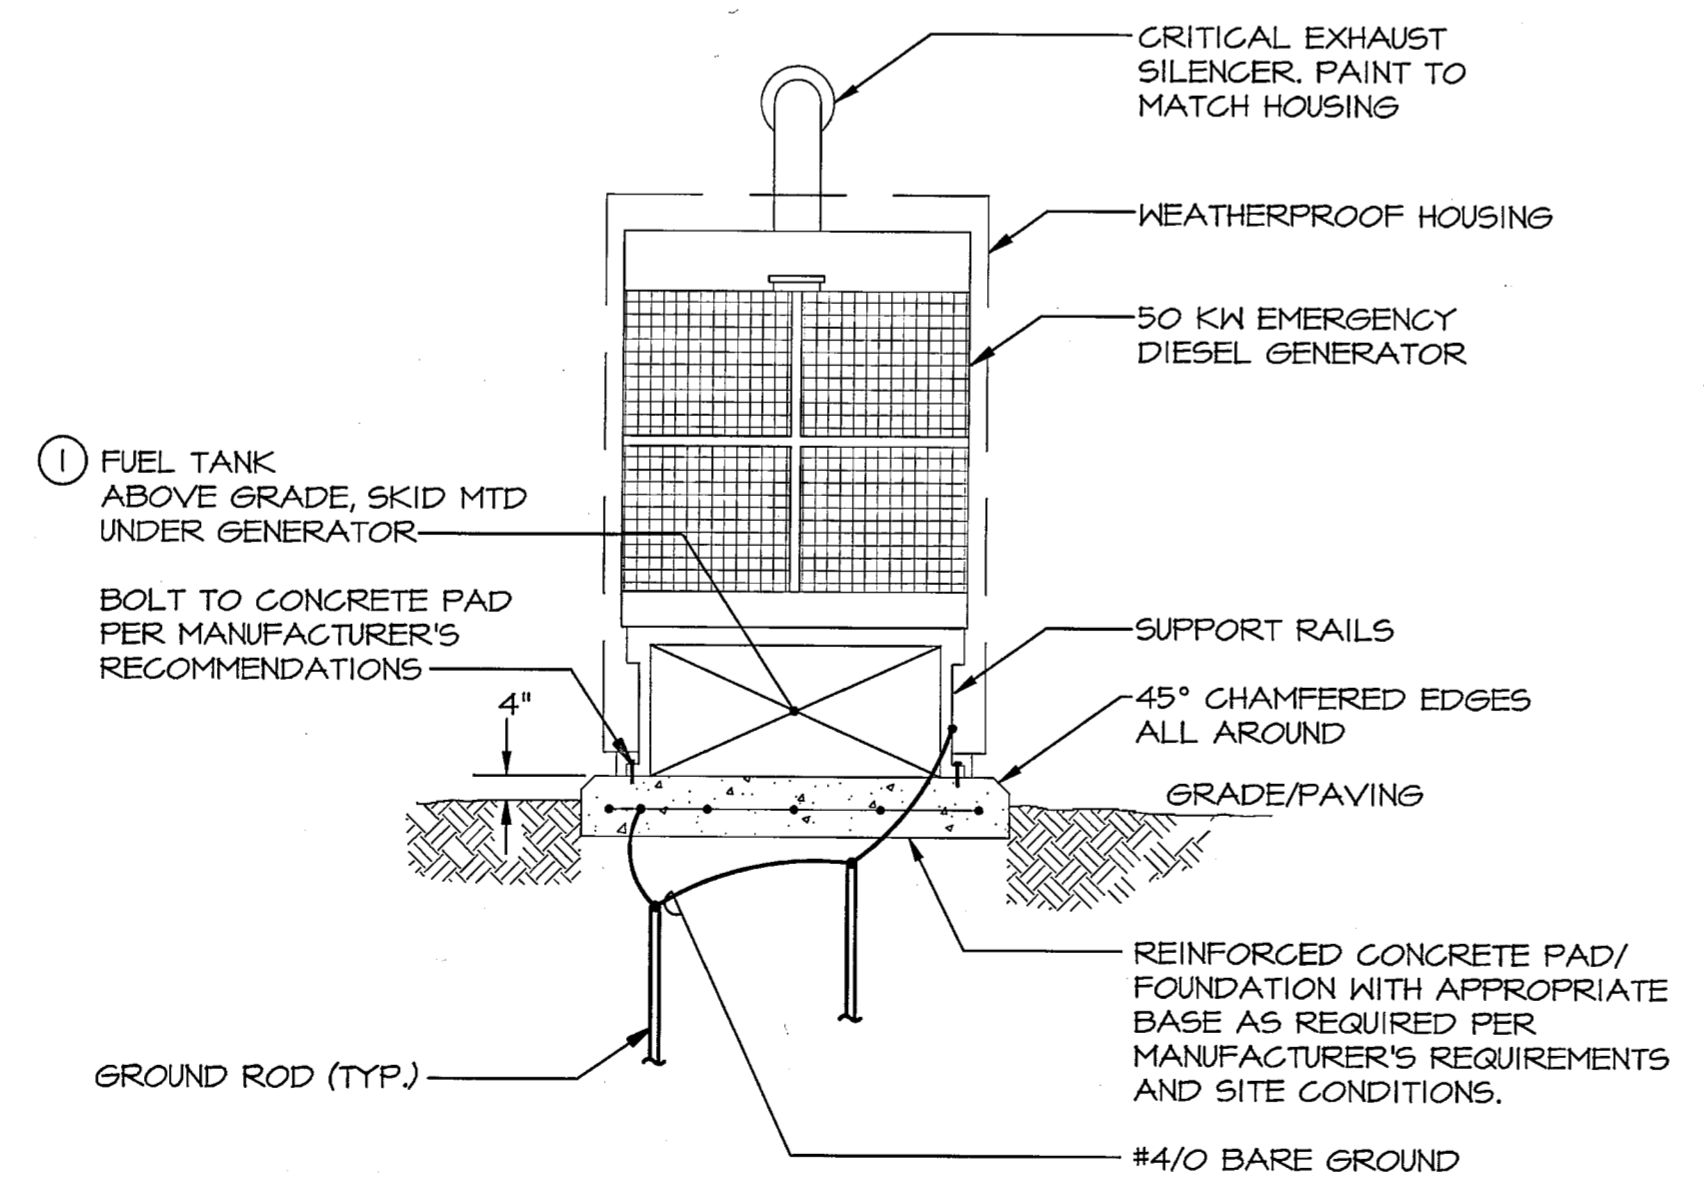

DETAIL - GENERATOR PAD
NO SCALE

GENERATOR NOTES

1. LEAK DETECTION MONITORING SYSTEM WITHIN SUB-BASE TANK FURNISHED WITH GENERATOR. ELECTRICAL CONTRACTOR SHALL EXTEND CONTROL WIRING TO THE FIRE ALARM CONTROL PANEL. A LEAK SHALL SIGNAL A TROUBLE LIGHT WITHIN THE FIRE ALARM CONTROL PANEL.

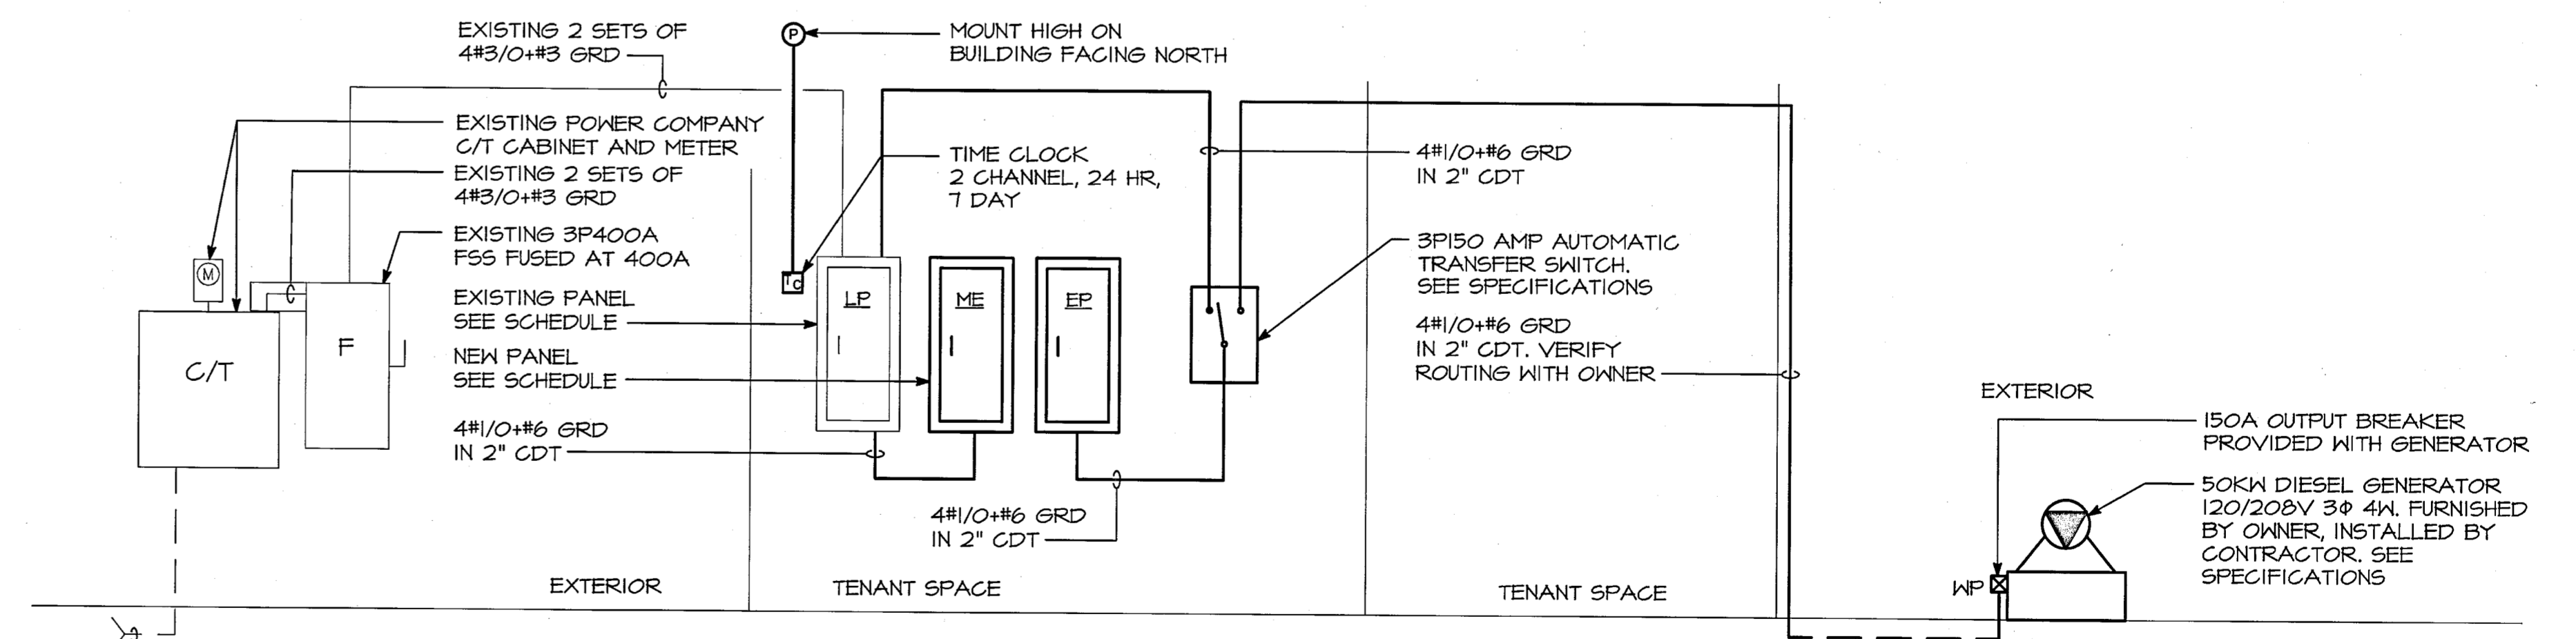

POWER RISER DIAGRAM
NO SCALE

* ITEMS SHOWN LIGHT ARE EXISTING AND ITEMS SHOWN BOLD ARE NEW.

REV#	DATE	DESCRIPTION

DP DON PENN CONSULTING ENGINEERS
3950 HIGHWAY 380, SUITE 101
GRAPEVINE, TEXAS 76051
817-410-2858 FAX 817-251-8411

FREDRICK WARD ASSOCIATES, INC.
P.O. Box 727, 5 South Main Street Bel Air, Maryland 21014-0727
Phone: 410-879-2090 or 410-838-7900 Fax: 410-893-1243
Columbia, Maryland Warrenton, Virginia

TENANT RENOVATIONS FOR:
RMS LIFE LINE
WALL STREET AND WESLEY AVENUE
NORWOOD, OHIO

DATE: 9/26/01
SCALE: AS NOTED
DESIGNED BY: M.L.B.
DRAWN BY: M.L.B.
SHEET 3 OF 4
2011215.00
JLR# 1-100b