



**POWER RISER DIAGRAM**  
NO SCALE

\* ELECTRICAL CONTRACTOR SHALL PROVIDE A PLAQUE OR DIRECTORY AT EACH SERVICE DISCONNECT LOCATION DENOTING ALL OTHER SERVICES AND FEEDERS SUPPLYING THAT TENANT AND THE AREA SERVED BY EACH. NEC 230-2(e)

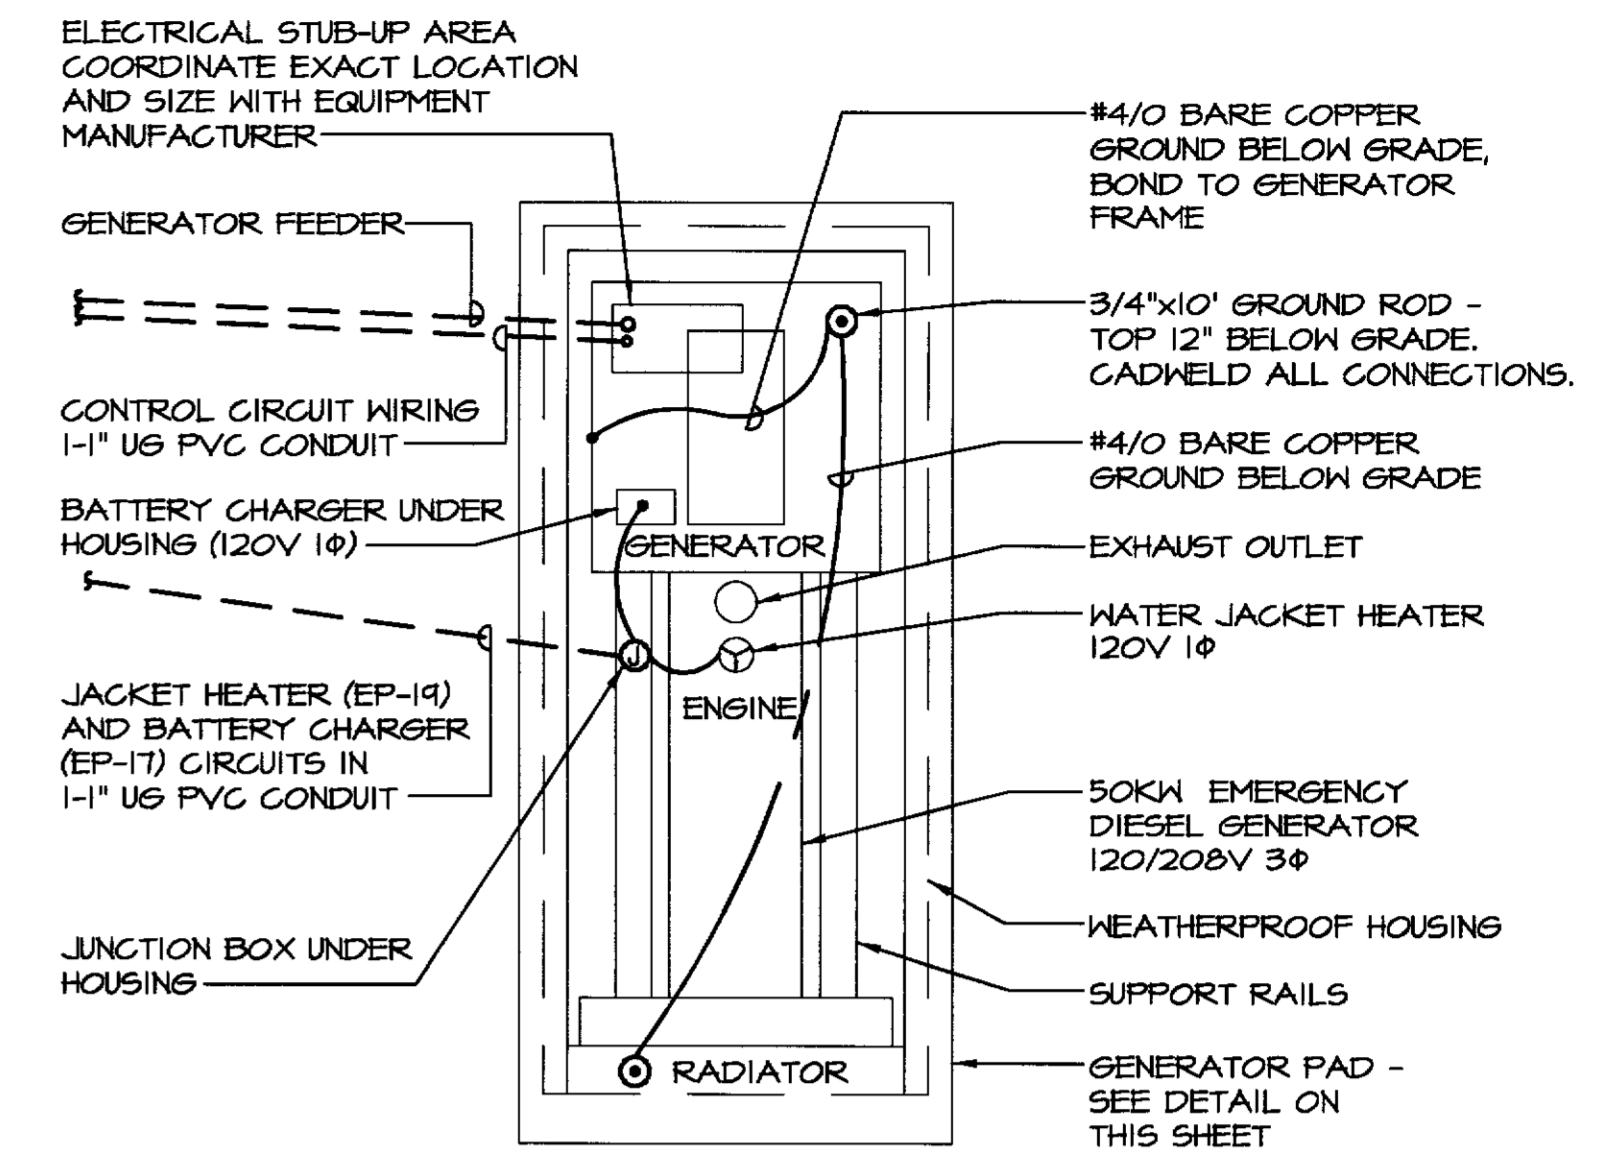

**DETAIL - GENERATOR CONNECTIONS**  
NO SCALE

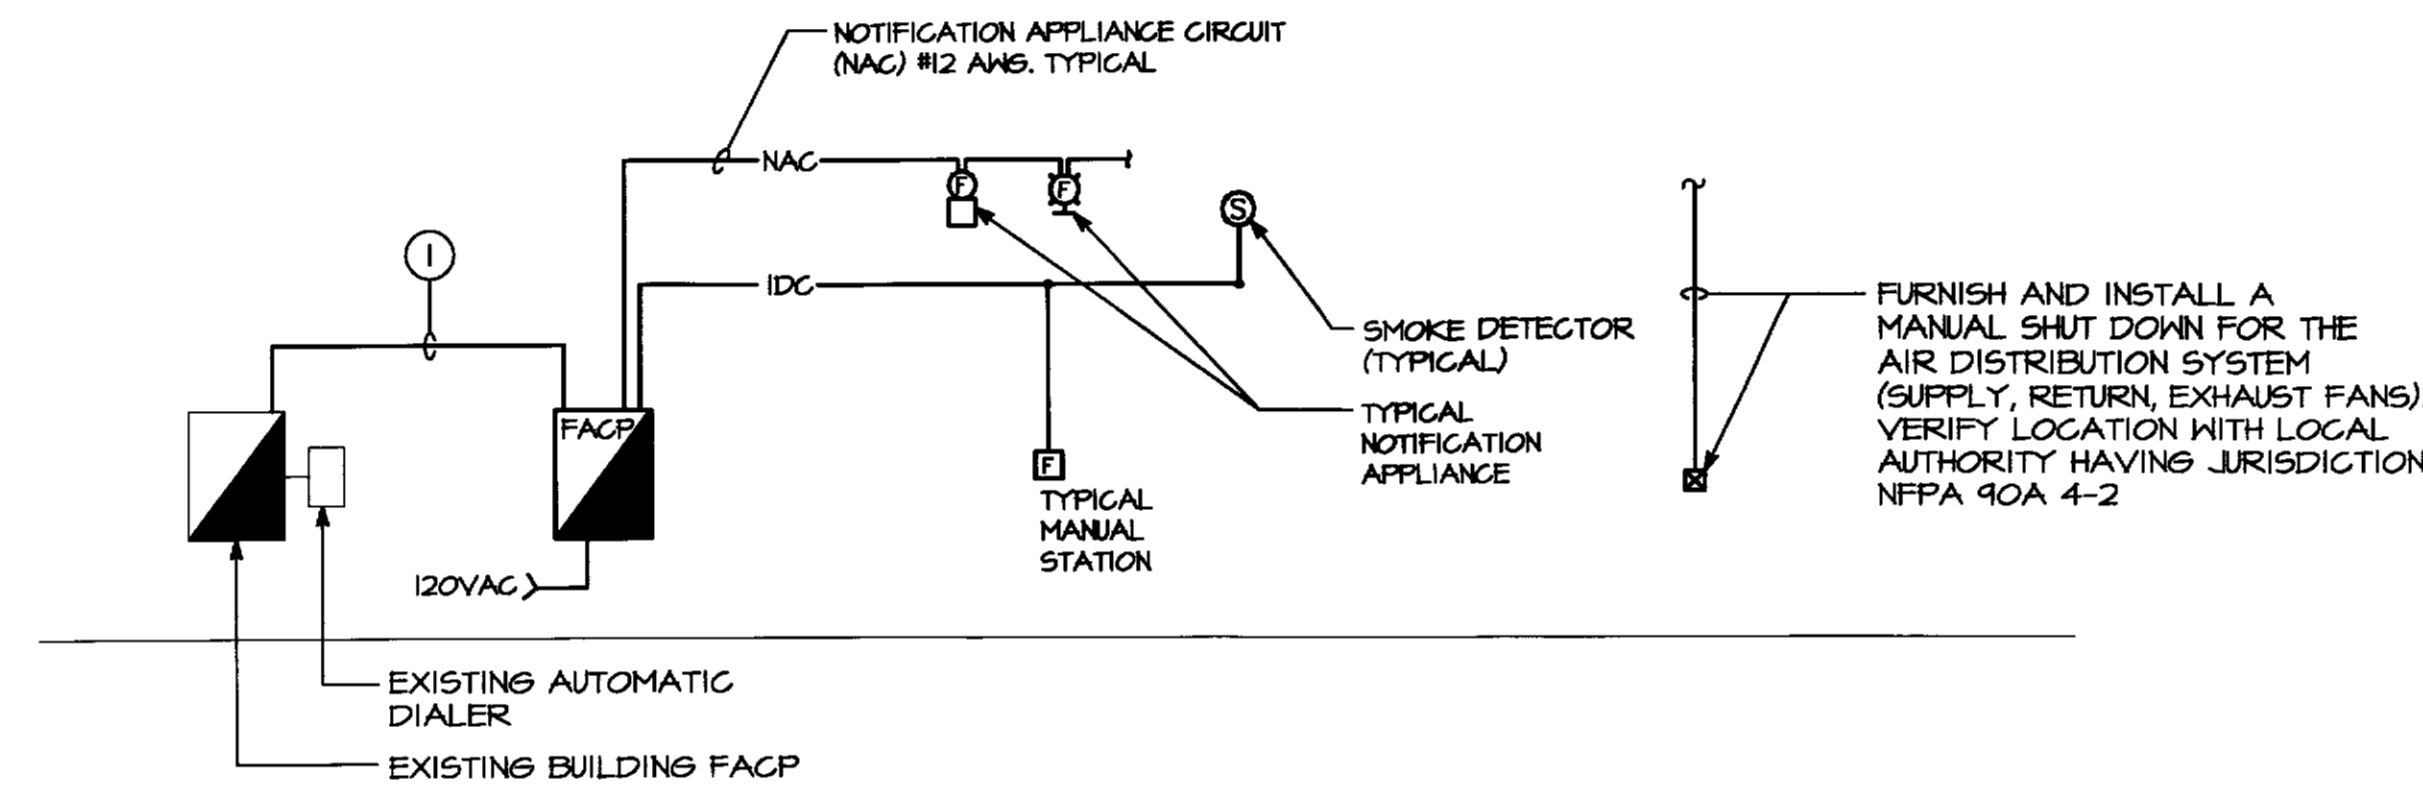


**FIRE ALARM RISER**

NO SCALE  
\* REFER TO THE FLOOR PLANS FOR LOCATIONS AND QUANTITIES

**FIRE ALARM NOTES**

- ① CONNECT TO THE EXISTING SYSTEM PER MANUFACTURER'S RECOMMENDATIONS. MAKE ALL MODIFICATIONS AND ADDITIONS AS NECESSARY TO THE EXISTING SYSTEM.

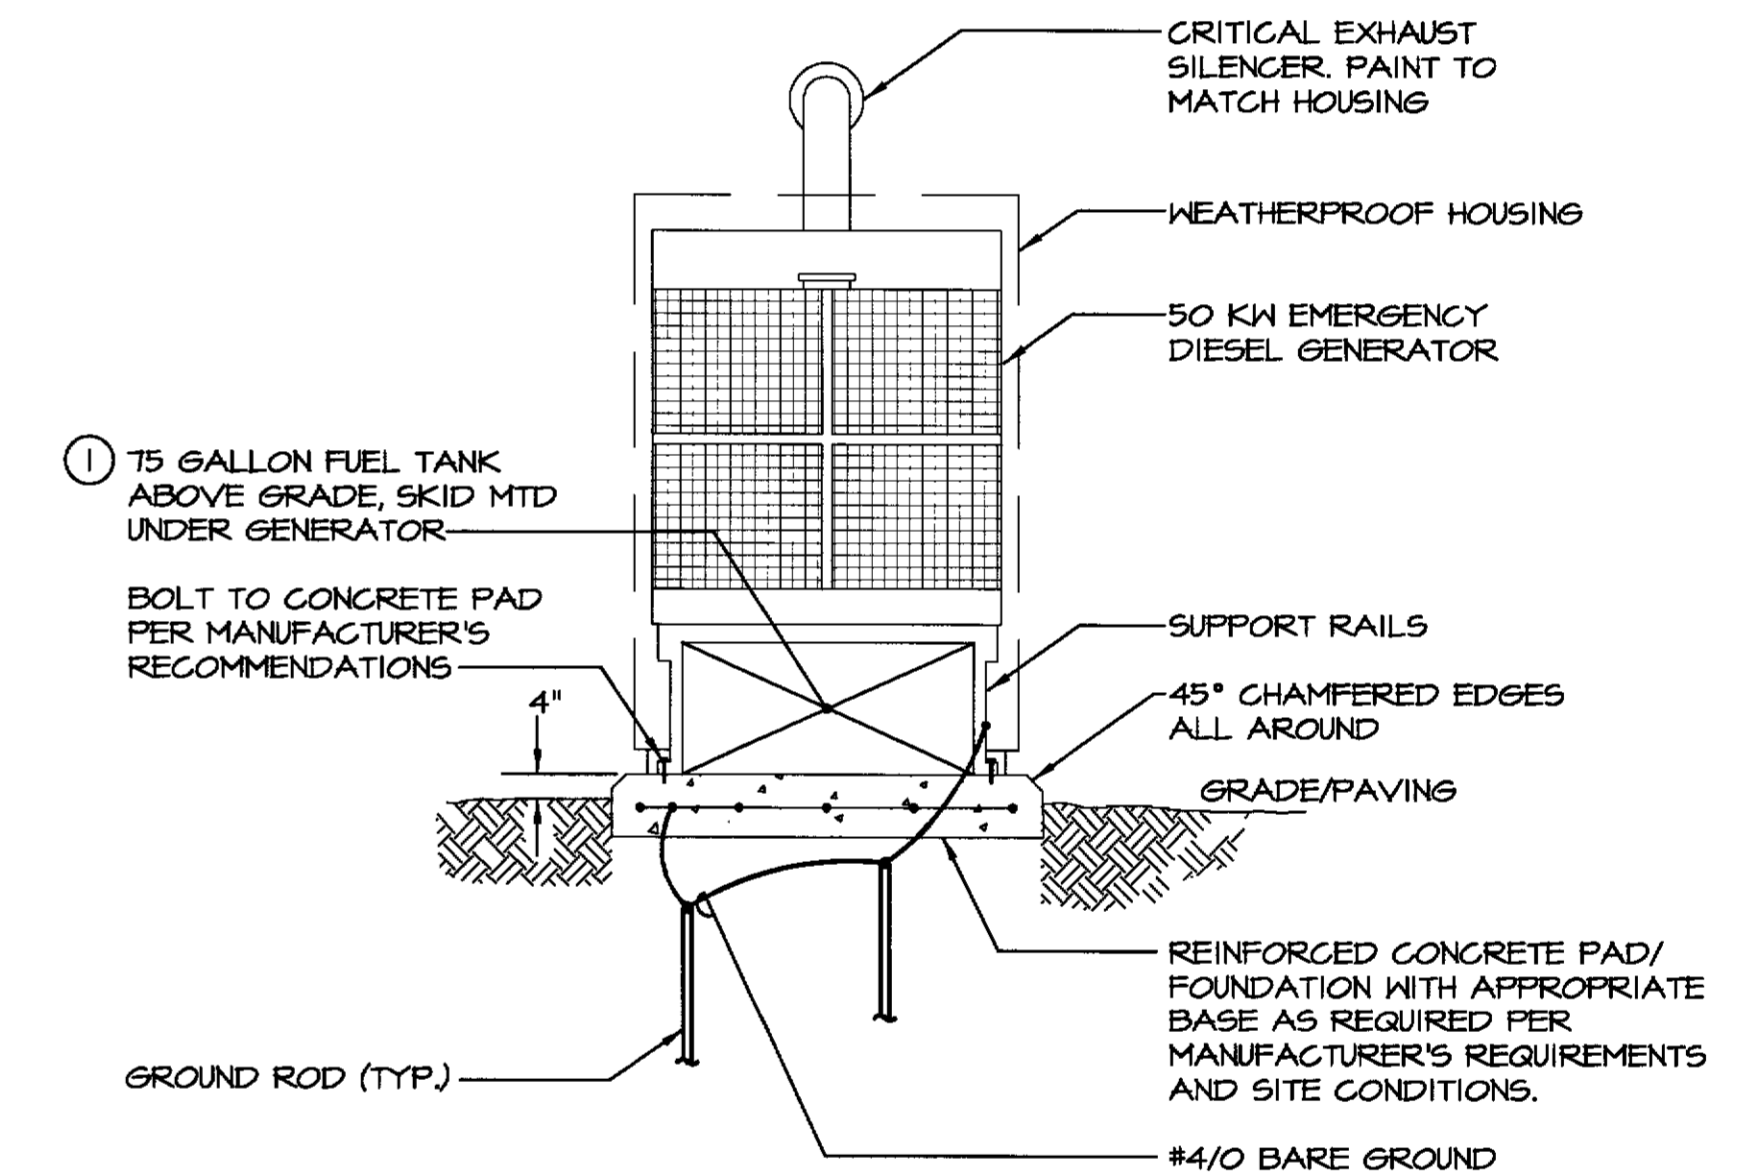

**DETAIL - GENERATOR PAD**  
NO SCALE

**GENERATOR NOTES**

- ① PROVIDE LEAK DETECTION MONITORING SYSTEM WITHIN SUB-BASE TANK AND EXTEND CONTROL WIRING TO THE FIRE ALARM CONTROL PANEL. A LEAK SHALL SIGNAL A TROUBLE LIGHT WITHIN THE FIRE ALARM CONTROL PANEL.

REV#	DATE	REVISION DESCRIPTION

**dp DON PENN CONSULTING ENGINEERS**  
3950 HIGHWAY 380, SUITE 101  
GRAPEVINE, TEXAS 76051  
817-410-2866 FAX 817-261-8411

**FREDRICK WARD ASSOCIATES, INC.**  
ENGINEERS ARCHITECTS SURVEYORS  
P.O. Box 727, 5 South Main Street Bel Air, Maryland 21014-0727  
Phone: 410-879-2090 or 410-838-7900 Fax: 410-893-1243  
Columbia, Maryland Warrenton, Virginia

TENANT RENOVATIONS FOR:  
**RMS LIFE LINE**  
RIVERSIDE, CALIFORNIA

DATE 9/11/01	DRAWING NO. <b>E3</b>
SCALE AS NOTED	SHEET 3 OF 4
DESIGNED BY MJB	THIS IS TAKEN
DRAWN BY MJB	2011215.00