


QUALICAD USER TEMPLATE PUBLISH - 187641 PLUMBING.DWG MAR_27_2018 - 7:04 AM - JHE GERSON

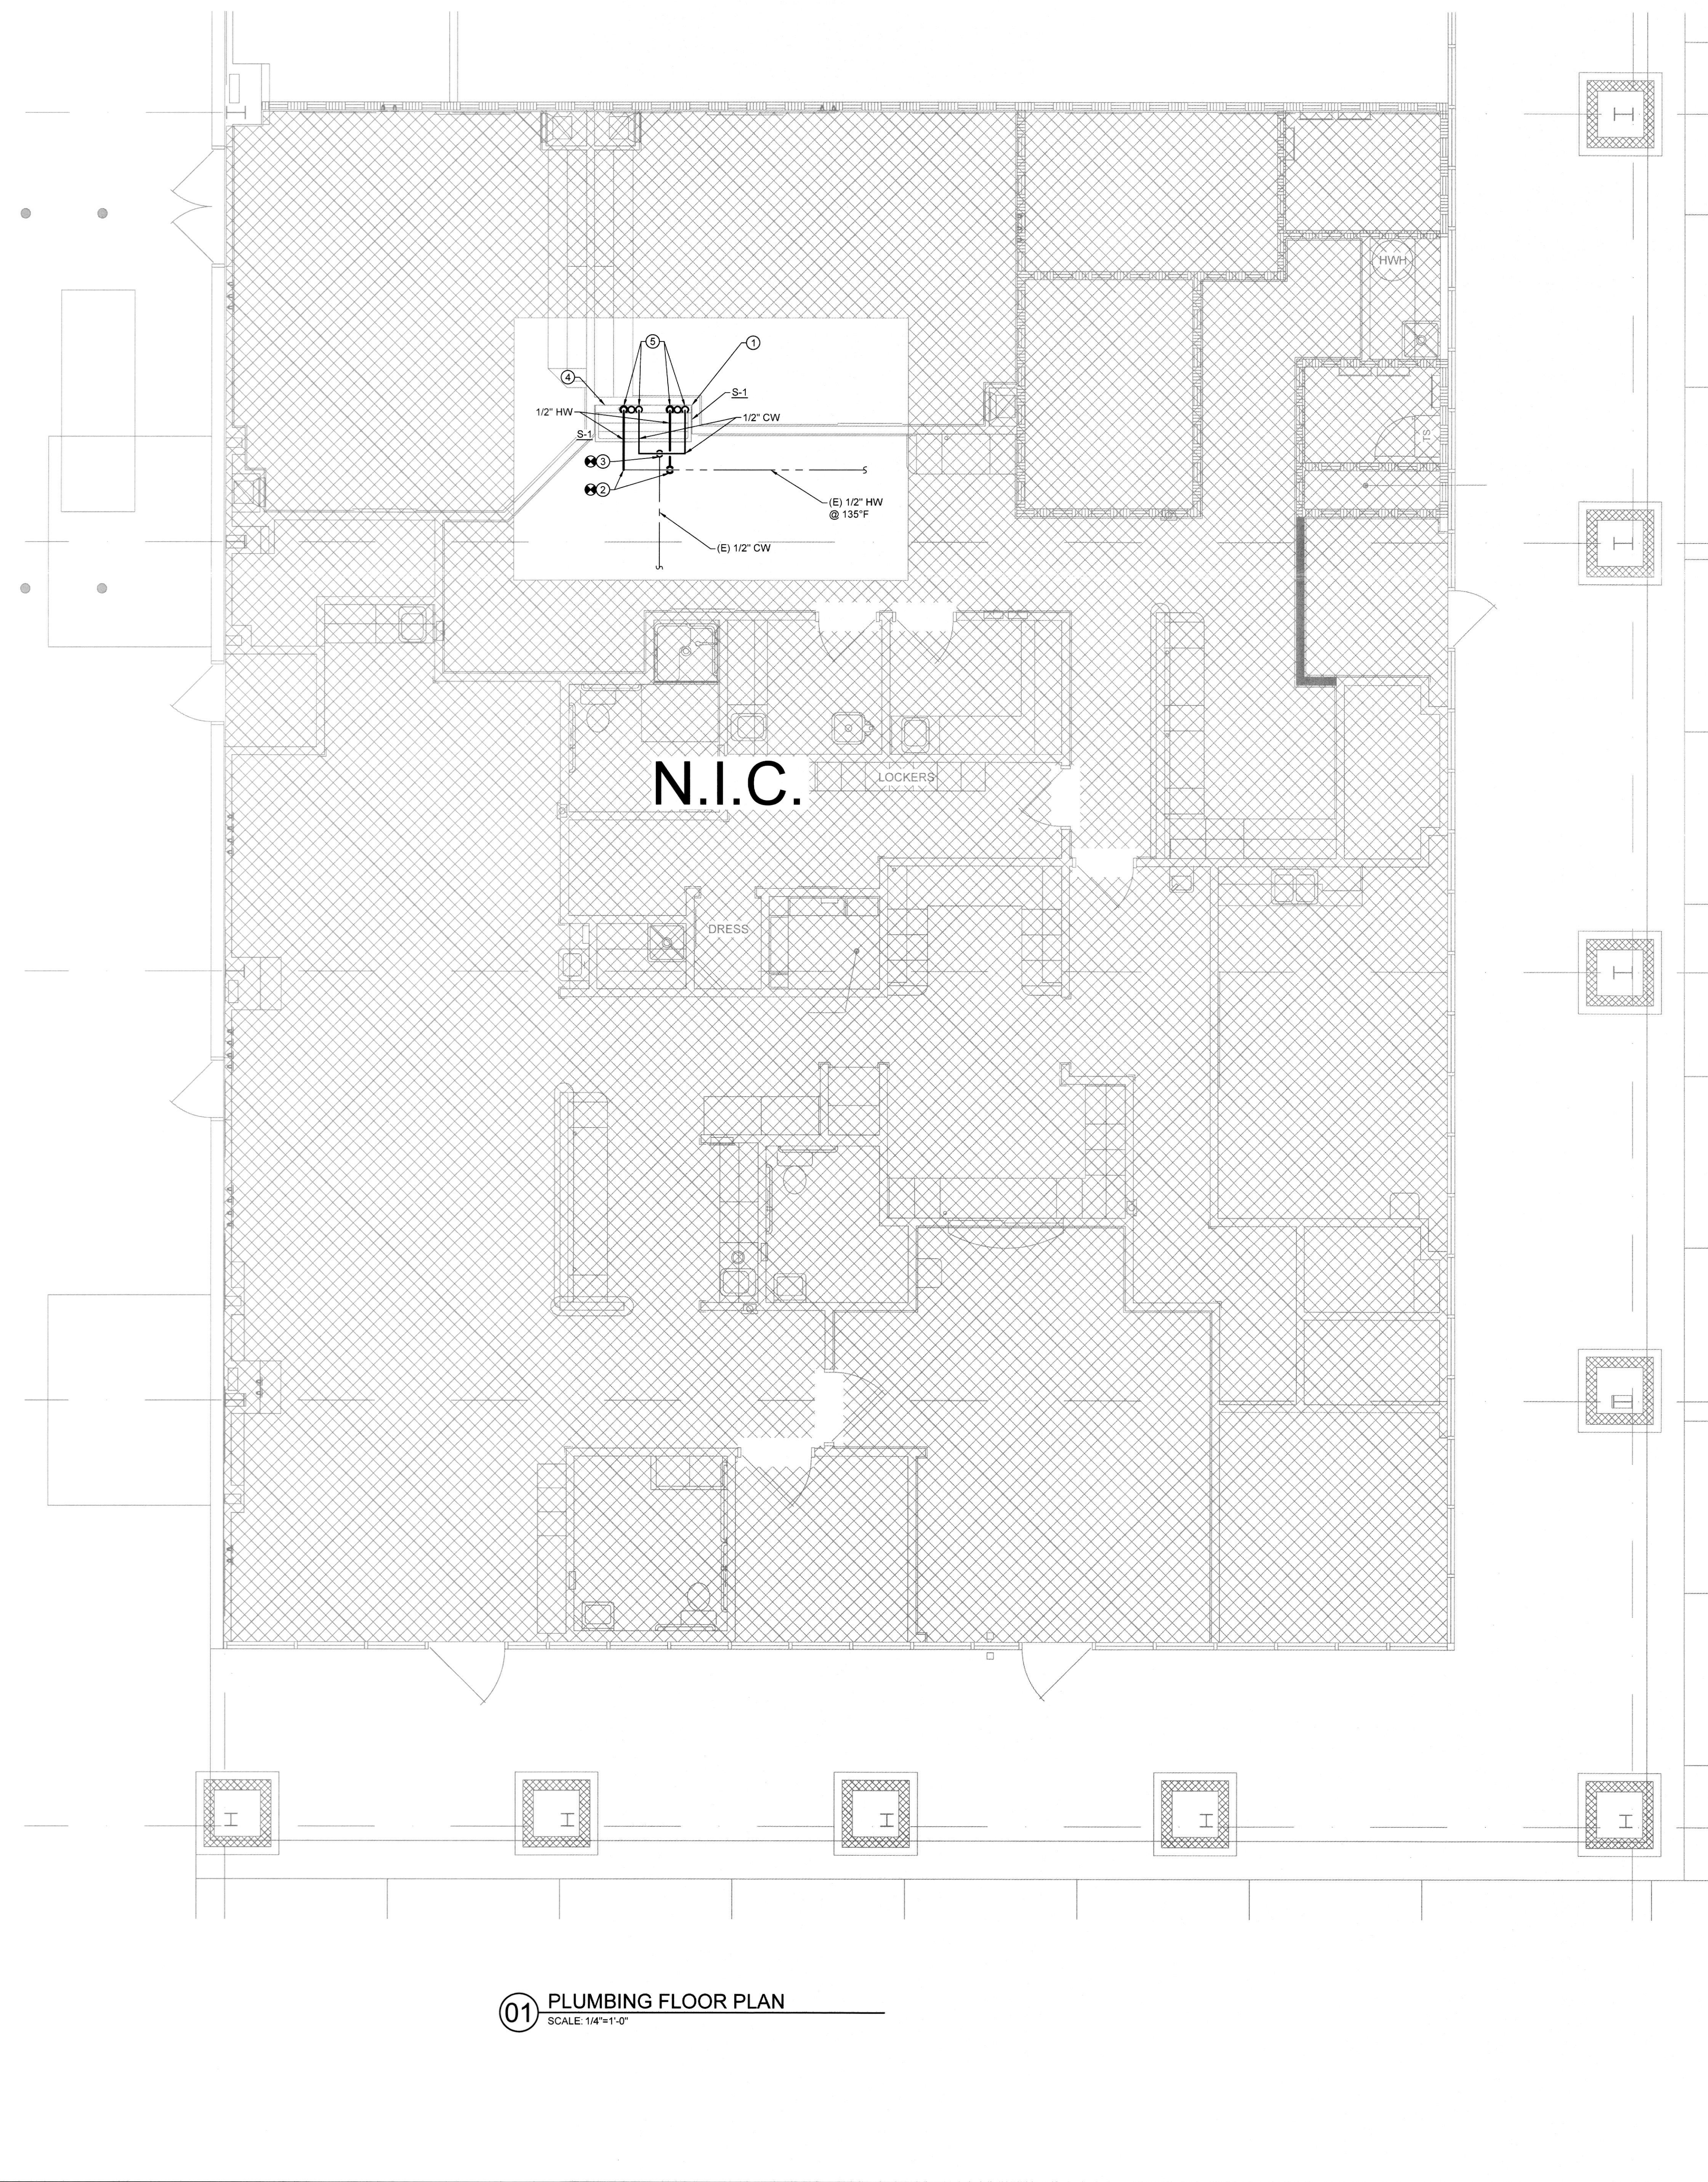

GENERAL PLUMBING NOTES:

- A. REFER TO SHEET P0.00 FOR ADDITIONAL PLUMBING GENERAL NOTES.
- B. REFER TO SHEET P0.00 FOR ADDITIONAL FIRE PROTECTION GENERAL NOTES.
- C. VERIFY ALL DIMENSIONS AT JOBSITE.
- D. CONTRACTOR SHALL REMOVE ALL NECESSARY EXISTING SERVICES SUCH AS WATER, WASTE, VENT AND GAS PIPING SERVING FIXTURES TO BE REMOVED AND/OR CONNECTIONS TO EQUIPMENT TO BE REMOVED. REMOVE ANY AND ALL UNUSED SERVICE LINES ABOVE CEILINGS, IN WALLS OR BELOW FLOORS.
- E. CONTRACTOR SHALL PATCH AND FILL ALL UNUSED EXISTING FLOOR PENETRATIONS.
- F. PLUMBING CONTRACTOR SHALL COMPLY WITH ALL FEDERAL, STATE AND LOCAL CODES AND AUTHORITIES HAVING JURISDICTION, AND MAKE FINAL CONNECTIONS TO FIXTURES AND EQUIPMENT.
- G. INSULATE ALL DOMESTIC WATER PIPING SUBJECTED TO FREEZING TEMPERATURE.
- H. INSULATE HOT WATER LINES WITH 1" MOLDED FIBERGLASS INSULATION.
- I. DO NOT SCALE DRAWINGS. REFER TO ARCHITECTURAL DOCUMENTS FOR EXACT LOCATION OF FIXTURES, EQUIPMENT.
- J. ALL WALL HUNG PLUMBING FIXTURES ARE TO BE SUPPORTED BY MEANS OF A CARRIER AS MANUFACTURED BY J. R. SMITH, JOSAM, OR ZURN.
- K. PLUMBING CONTRACTOR SHALL COORDINATE ALL PIPING AND EQUIPMENT WITH OTHER TRADES PRIOR TO INSTALLATION OF ANY PIPING OR EQUIPMENT.
- L. PLUMBING CONTRACTOR SHALL VERIFY THE EXACT SIZE, LOCATION, DEPTH AND PRESSURE OF ALL EXISTING UTILITY LINES BEFORE COMMENCING WORK.
- M. VENT PIPING TO BE 2" UNLESS OTHERWISE NOTED.
- N. VENT PENETRATIONS THROUGH ROOF TO HAVE CLEARANCE OF 10 FEET, MINIMUM, FROM ANY INTAKE FOR FRESH AIR.
- O. COORDINATE ALL WORK WITH OWNER OR REPRESENTATIVES.
- P. ALL PIPING SHALL BE RUN CONCEALED UNLESS OTHERWISE NOTED.
- Q. PLUMBING CONTRACTOR SHALL FURNISH AND INSTALL ALL GAS PIPING AND MAKE ALL FINAL CONNECTIONS. GAS PIPING SHALL BE SCHEDULE 40 BLACK STEEL PIPE AND BANDED MALLEABLE IRON FITTINGS.
- R. ALL UNDERGROUND WATER LINES SHALL BE TYPE "K" COPPER TUBING WITH 1/2" ARMAFLEX INSULATION.
- S. PROVIDE BACKFLOW PREVENTER AT THE LOCATIONS REQUIRED BY CODE, AND ALL GOVERNING AUTHORITIES.
- T. SANITARY AND WATER SERVICE MAY VARY. SEE SITE PLAN.
- U. REFERENCE ARCHITECTURAL DRAWINGS FOR DIMENSIONS AFFECTING THIS WORK.
- V. ALL WORK SHALL BE SUBJECT TO THE APPROVAL OF THE ARCHITECT.

KEYED NOTES:

- 1. REMOVE EXISTING HAND WASH SINK AND PRESERVE PIPING CONNECTIONS FOR FUTURE FIXTURE.
- 2. CONNECT NEW 1/2" HW PIPING TO EXISTING 1/2" HW PIPING SERVING REMOVED FIXTURE.
- 3. CONNECT NEW 1/2" CW PIPING TO EXISTING 1/2" CW PIPING SERVING REMOVED FIXTURE.
- 4. INSTALL NEW SINK (S-1) AND RECONNECT TO EXISTING SANITARY AND VENT PIPING THAT SERVED REMOVED FIXTURE.
- 5. 1/2" CW AND HW PIPING DOWN IN WALL TO VALVED OUTLET FOR CONNECTION TO NEW SINK FAUCET.

DATE: 03/26/2018
JOB NO: 11247
DRAWN: JAH
CHECKED: VJD




711 N. FIELDER RD.
ARLINGTON, TX 76012
PH: (817) 635-5696
FAX: (817) 635-5699



Lifeline Project Manager
In Sync
Whiteford, MD 21160
1213 Old Pylesville Road
Office 410-452-8006 Fax 410-452-8046

**Vascular Surgery Center
of Central Arkansas**
11771 Maumelle Blvd
North Little Rock, AR 72113

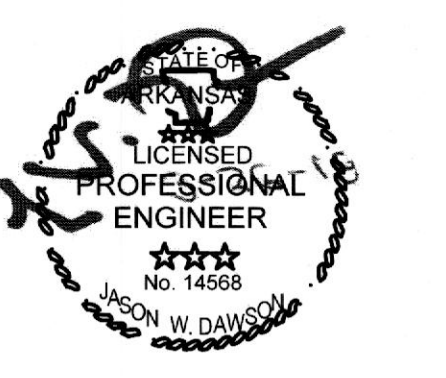

REVISIONS	
ISSUE FOR CONSTRUCTION	3/26/18
B-ISSUE DATE	
C-ISSUE DATE	
D-ISSUE DATE	
E-ISSUE DATE	
F-ISSUE DATE	

PLUMBING FLOOR PLAN

SHEET NUMBER

P1.01

01 PLUMBING FLOOR PLAN
SCALE: 1/4"=1'-0"

DVO PROJECT - 181054