





Date	Appr.	Symbol	Description

Checked by: WTT	Date: 02/27/04
Drawn by: ICT	CADD File Name: 3/2/04/04-000
Approved by: [Signature]	ICT Project No.: 203121
Chief, Proj. Mgmt. Division	Plot date: 02/27/04
Plot scale:	

DEFENSE INFORMATION SCHOOL
FT. MEADE MARYLAND
AHU FLOW SCHEMATIC DIAGRAMS

Sheet reference number:
M-104

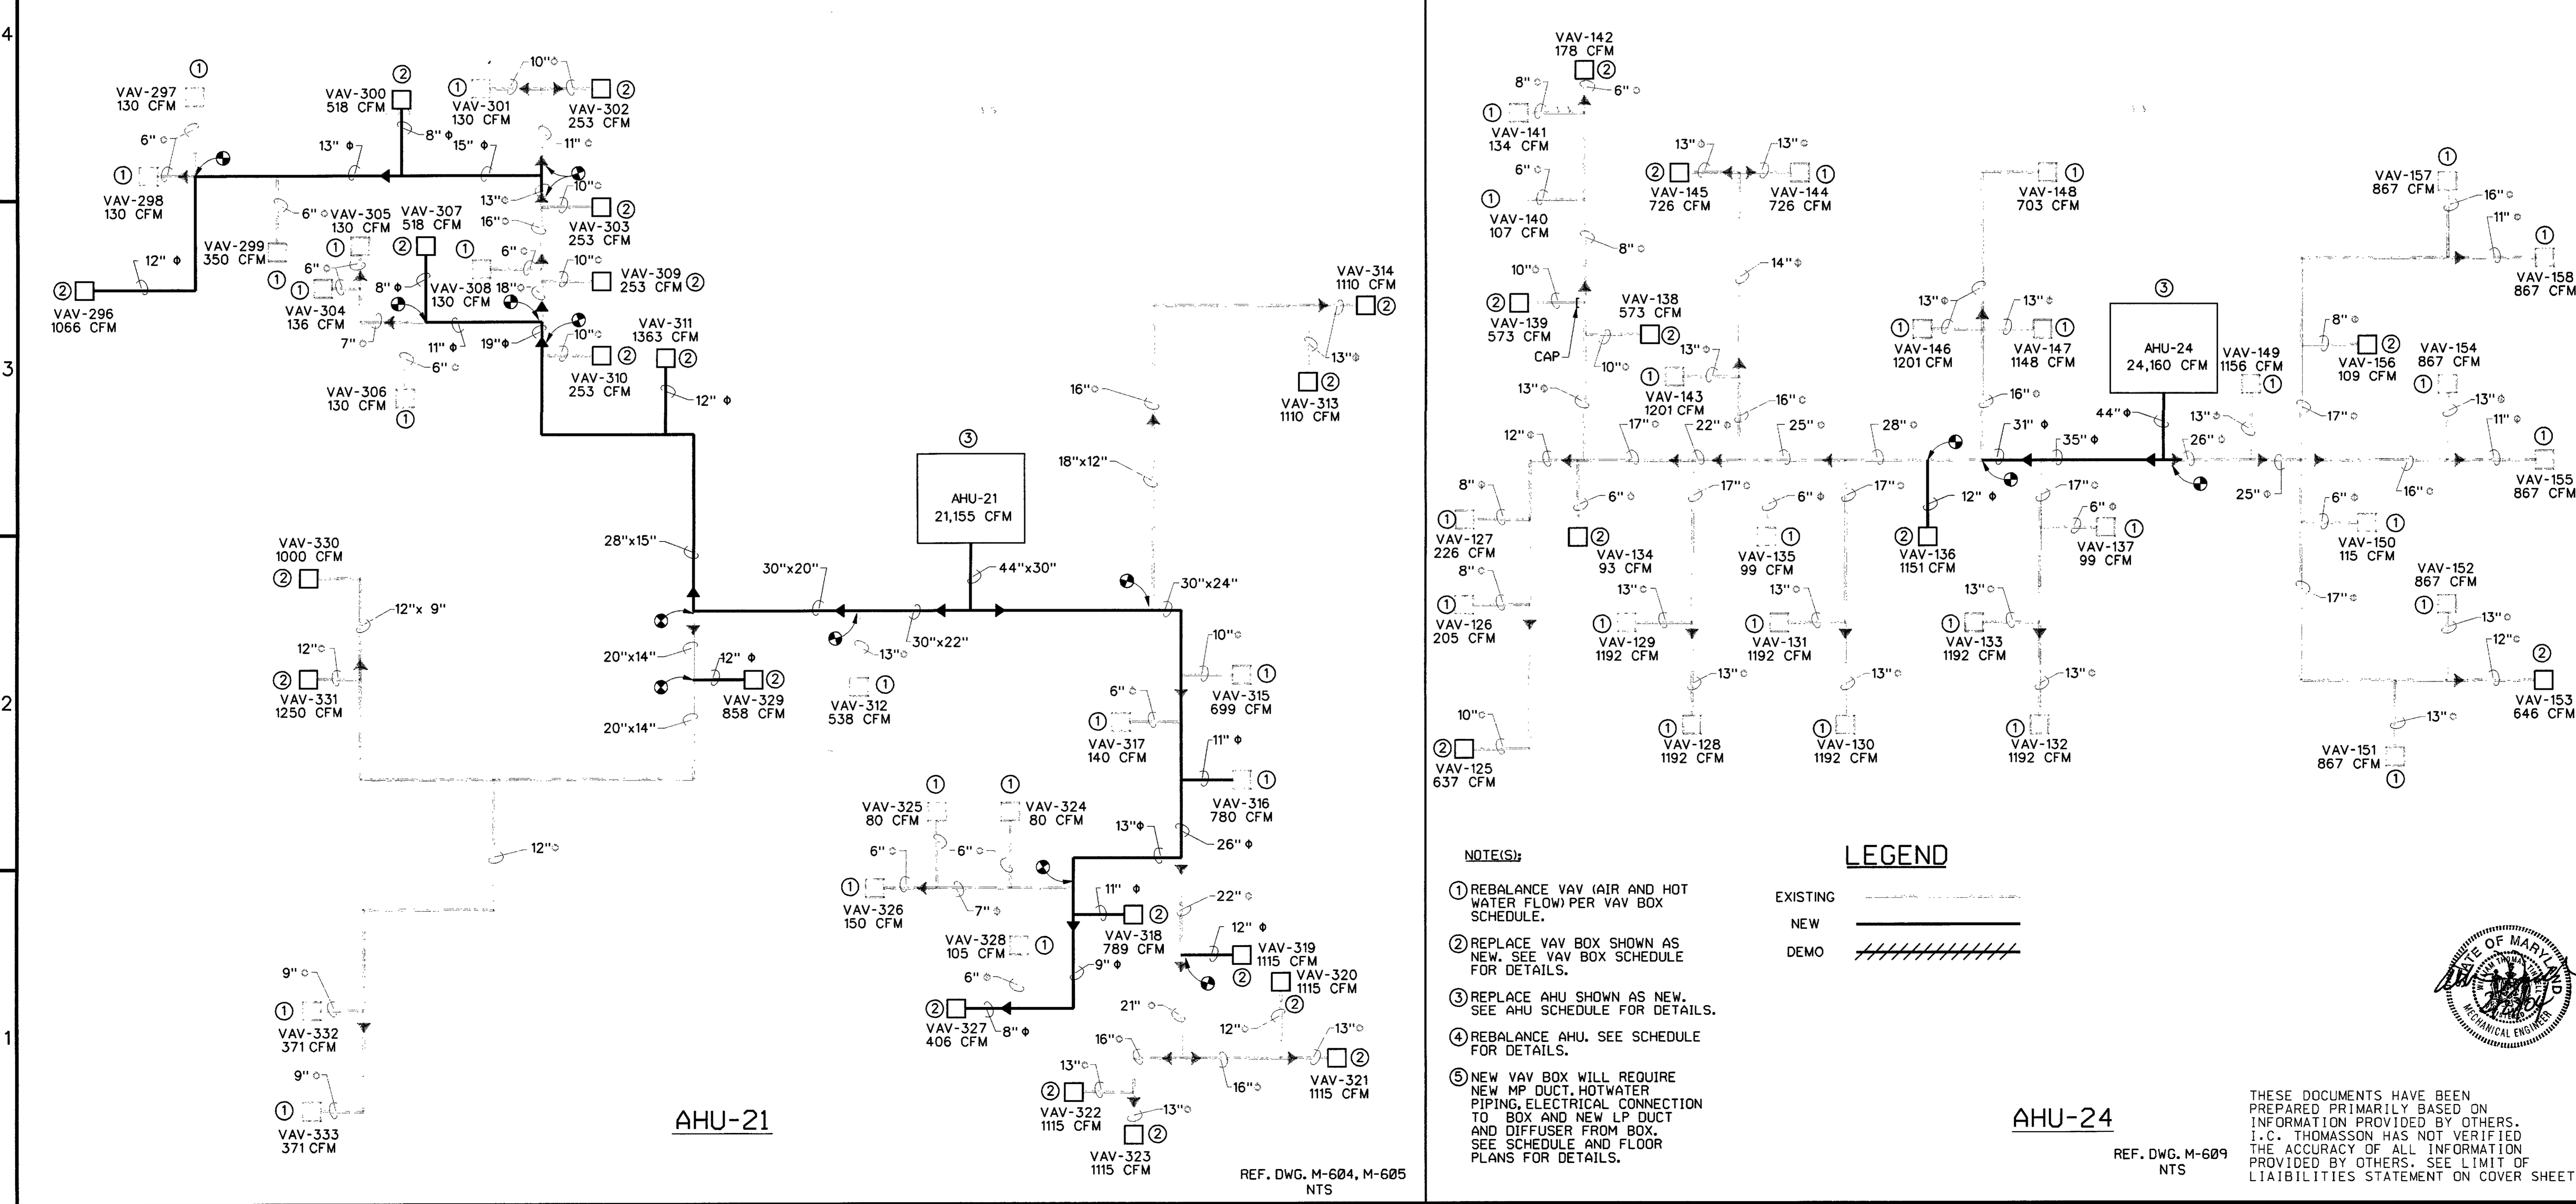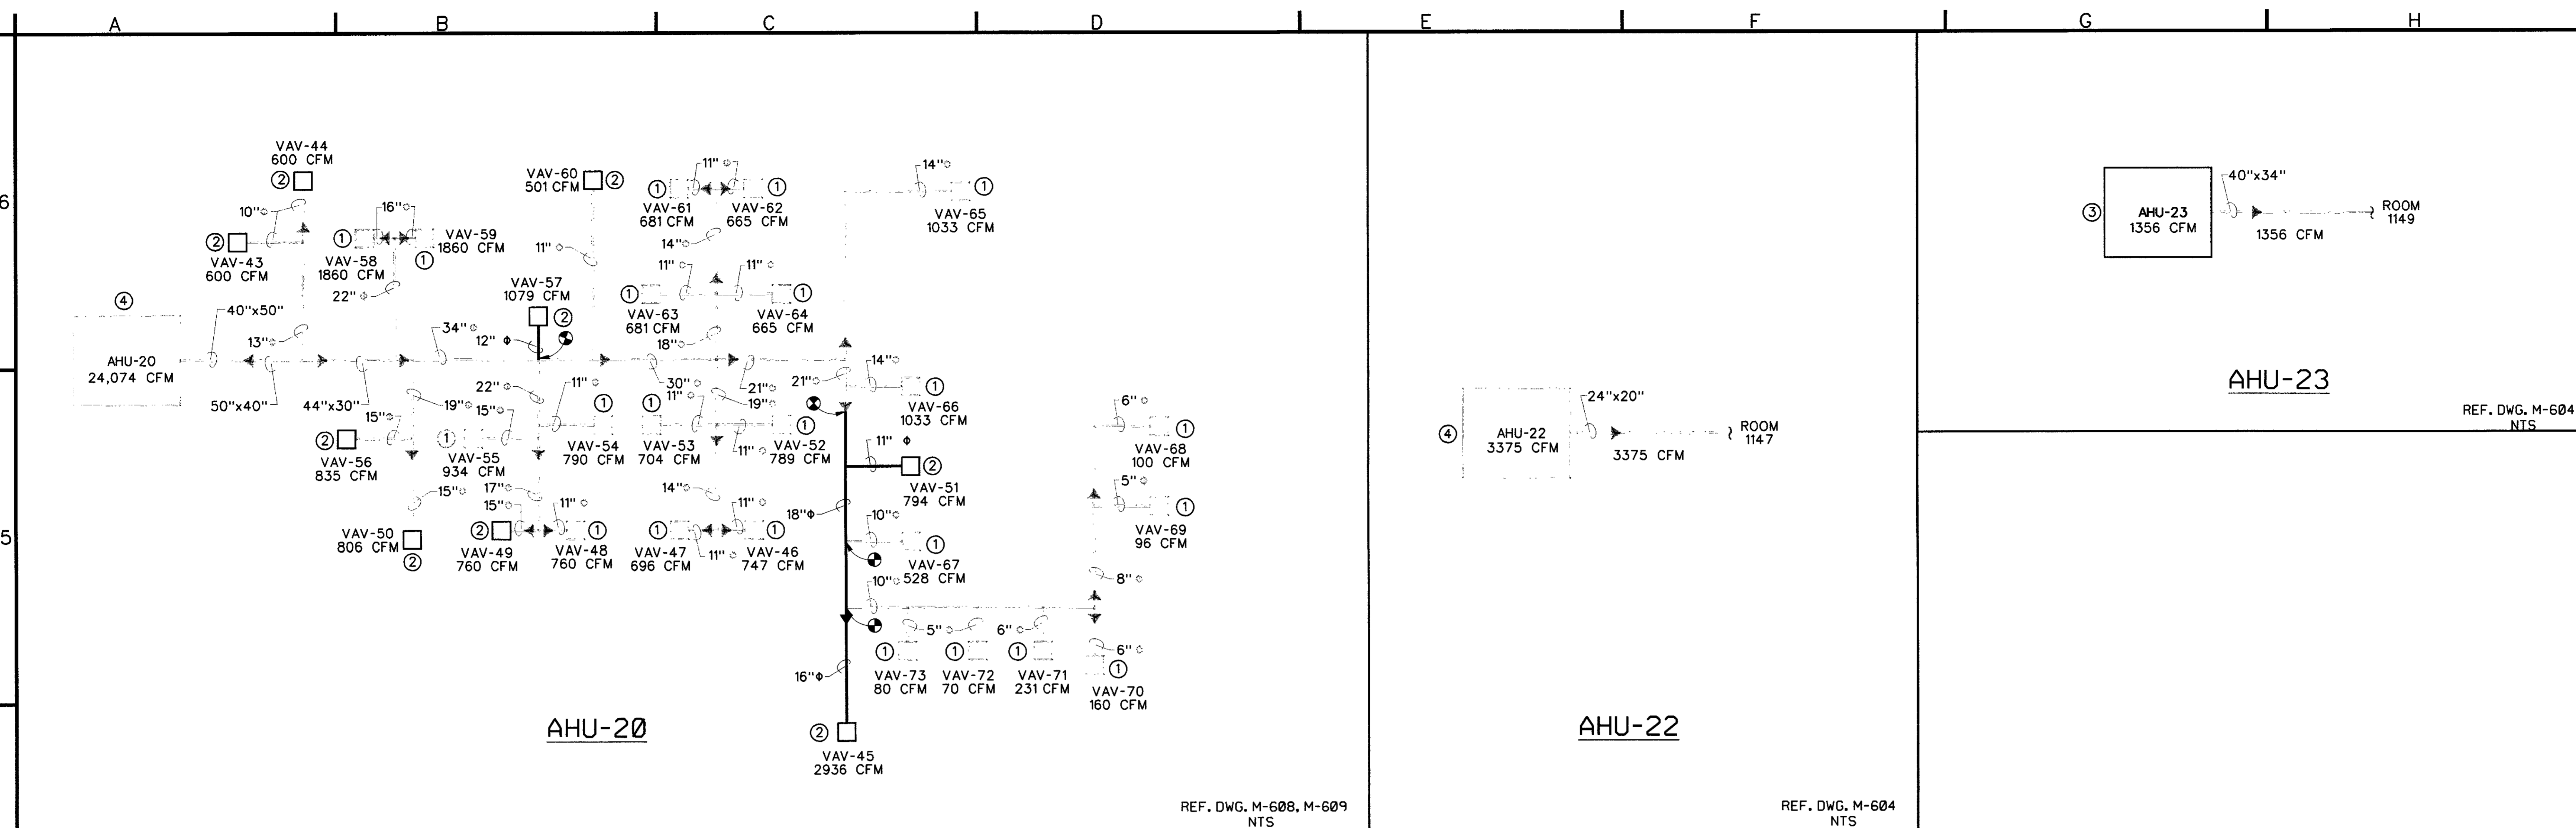


NOTE(S):

- REBALANCE VAV (AIR AND HOT WATER FLOW) PER VAV BOX SCHEDULE.
- REPLACE VAV BOX SHOWN AS NEW. SEE VAV BOX SCHEDULE FOR DETAILS.
- REPLACE AHU SHOWN AS NEW. SEE AHU SCHEDULE FOR DETAILS.
- REBALANCE AHU. SEE SCHEDULE FOR DETAILS.
- NEW VAV BOX WILL REQUIRE NEW MP DUCT, HOTWATER PIPING, ELECTRICAL CONNECTION TO BOX AND NEW LP DUCT AND DIFFUSER FROM BOX. SEE SCHEDULE AND FLOOR PLANS FOR DETAILS.

LEGEND

EXISTING _____
 NEW _____
 DEMO //////////////

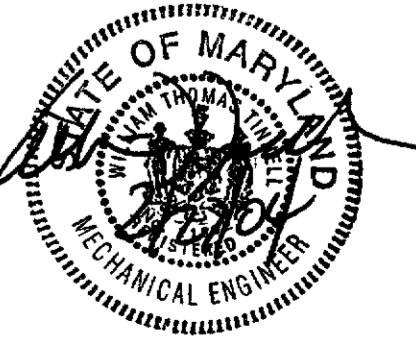

THESE DOCUMENTS HAVE BEEN PREPARED PRIMARILY BASED ON INFORMATION PROVIDED BY OTHERS. J.C. THOMASSON HAS NOT VERIFIED THE ACCURACY OF ALL INFORMATION PROVIDED BY OTHERS. SEE LIMIT OF LIABILITIES STATEMENT ON COVER SHEET.