

Date	Description


Date: 02/27/04	Checked by: WIT
CADD File Name: 312M06.DGN	Drawn by: ICT
ICT Project No. 20321	DAC487-03-D-0006
Plot date: 02/27/04	Approved by: [Signature]
Plot scale:	Sheet, Proj. Mgmt. Division

TASK ORDER #1: FR0004	PAUCAR, KENTUCKY
VOICE: 270-442-8620	312M06.DGN
[Signature]	I.C. Thomasson
[Signature]	ASSOCIATES, INC.
	NASHVILLE, TENNESSEE
	PHONE: (615) 346-3400

**DEFENSE INFORMATION SCHOOL**  
 MARYLAND  
 FT. MEADE  
 1st FLOOR HOT WATER  
 FLOW SCHEMATIC DIAGRAM

Sheet reference number:  
**M-106**

THESE DOCUMENTS HAVE BEEN PREPARED PRIMARILY BASED ON INFORMATION PROVIDED BY OTHERS. I.C. THOMASSON HAS NOT VERIFIED THE ACCURACY OF ALL INFORMATION PROVIDED BY OTHERS. SEE LIMIT OF LIABILITY STATEMENT ON COVER SHEET.

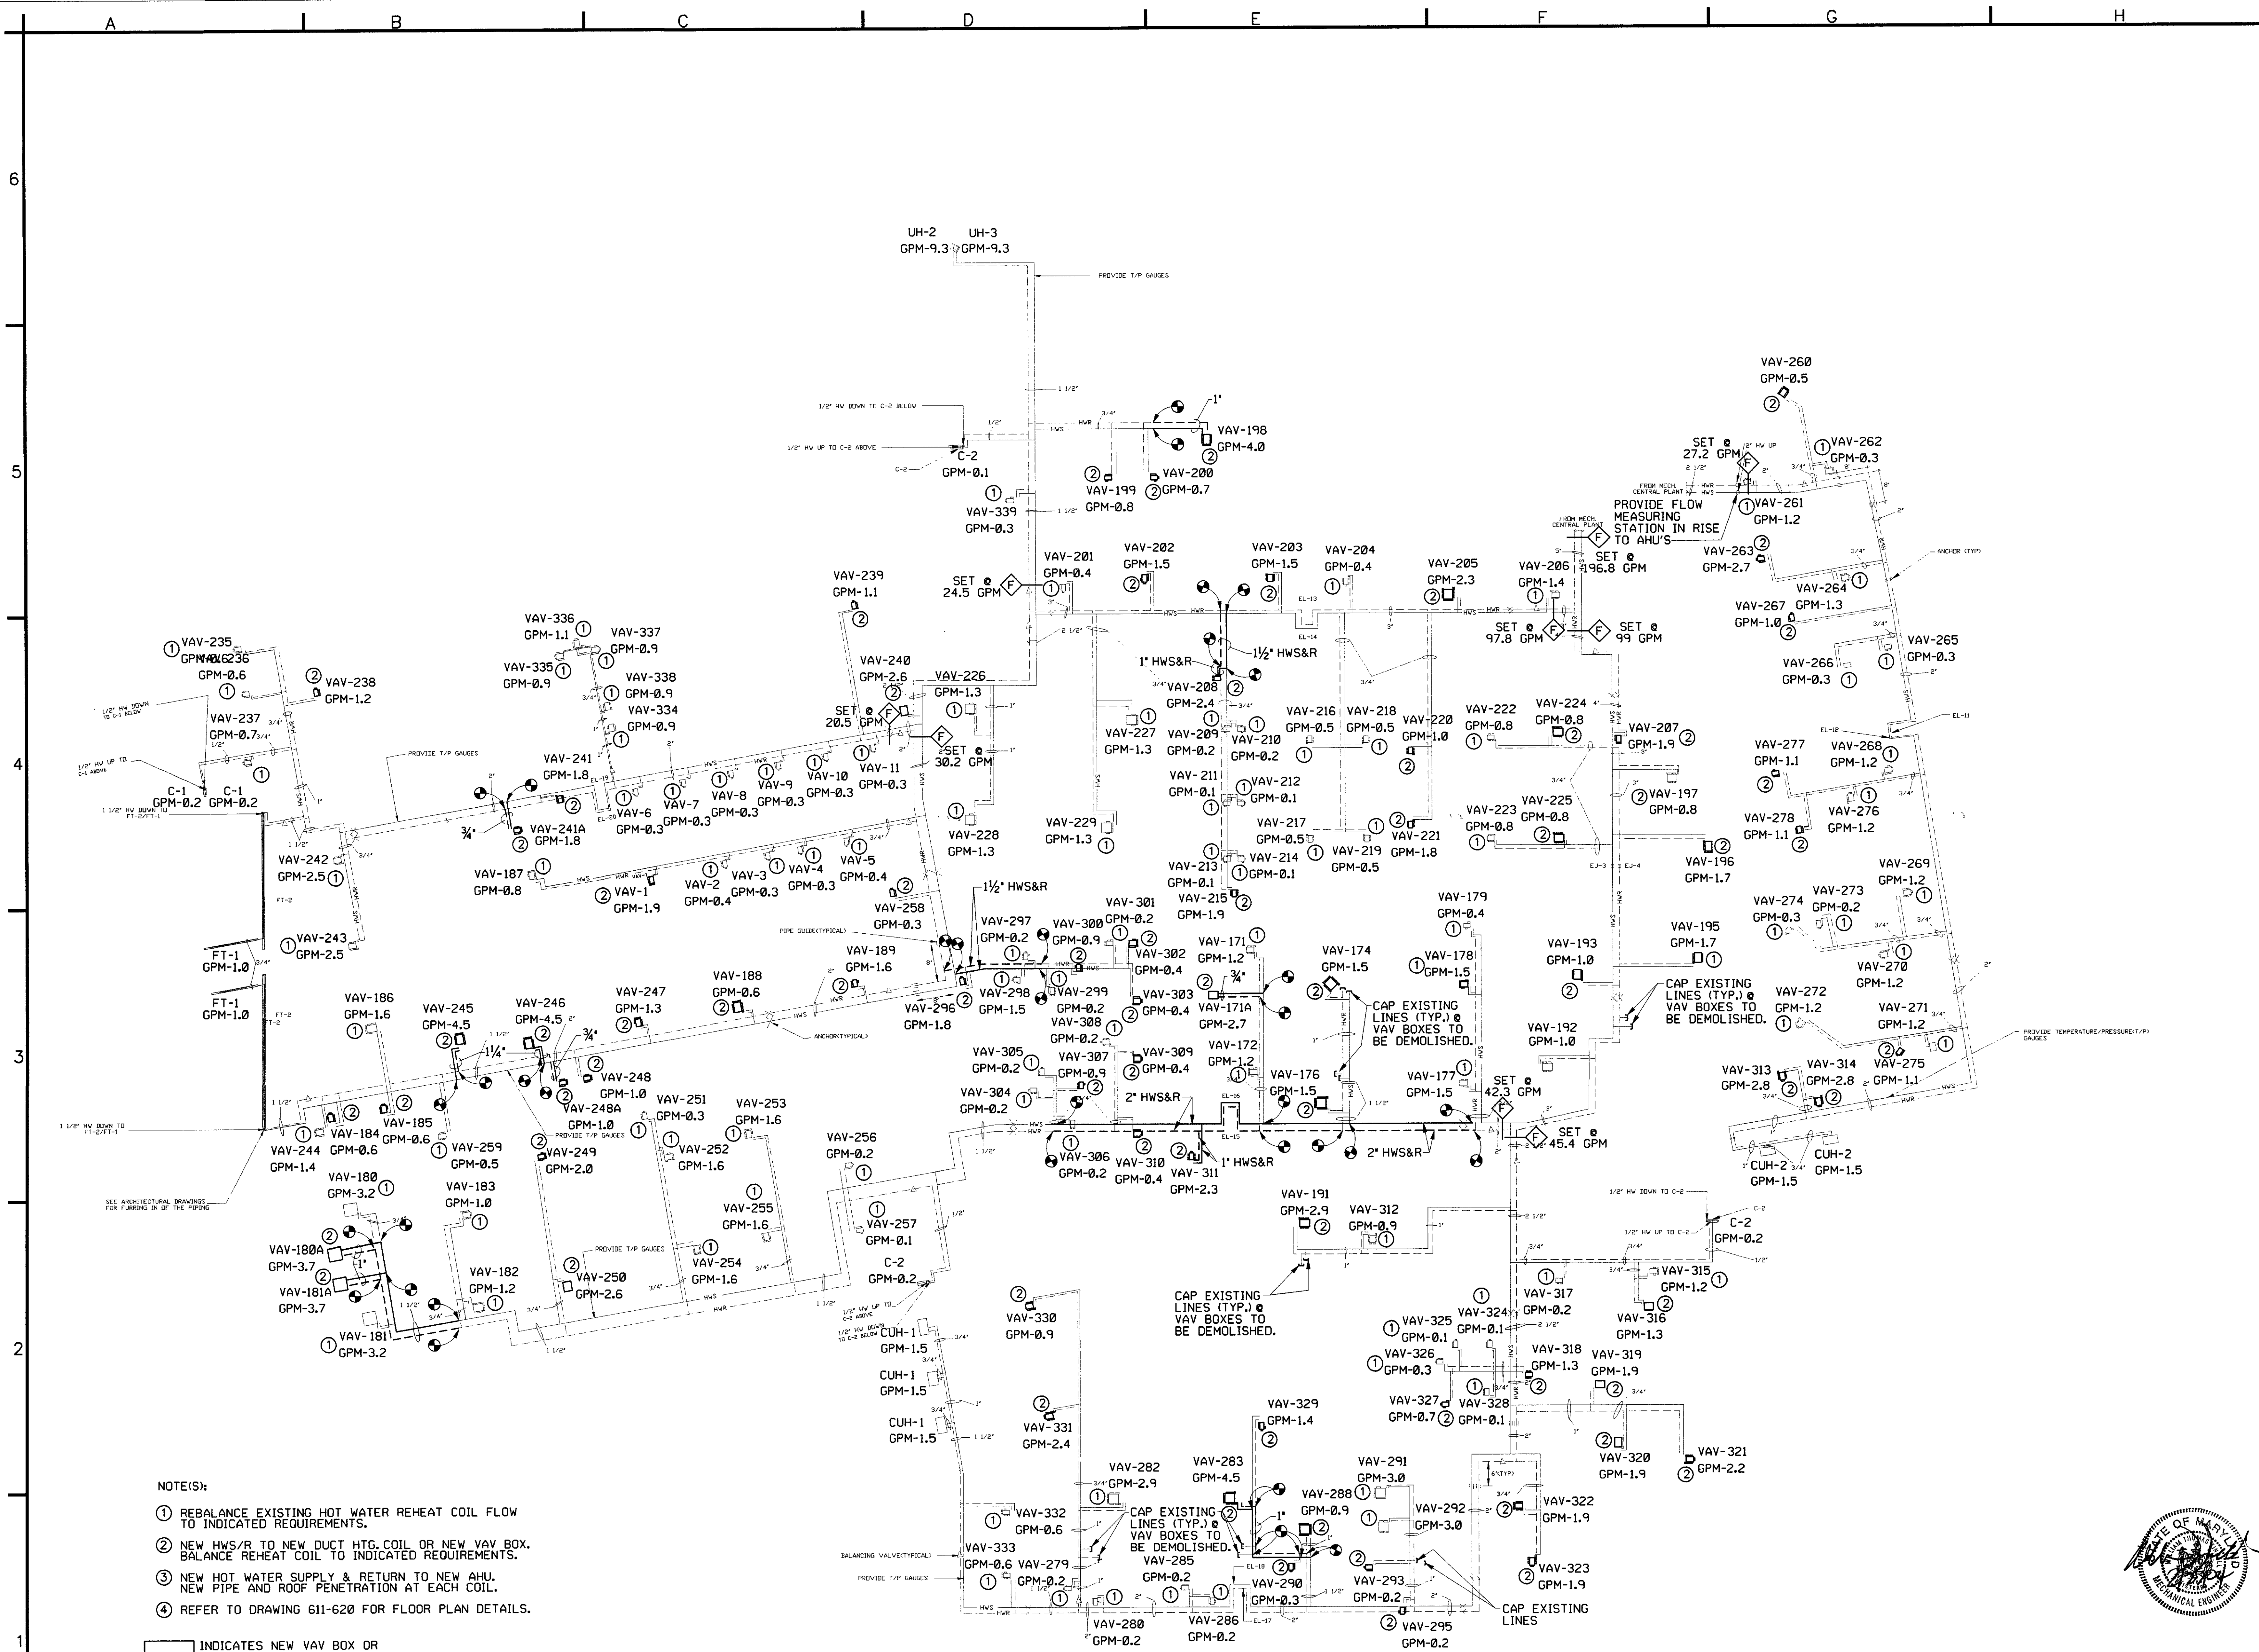

- NOTE(S):
- ① REBALANCE EXISTING HOT WATER REHEAT COIL FLOW TO INDICATED REQUIREMENTS.
  - ② NEW HWS/R TO NEW DUCT HTG. COIL OR NEW VAV BOX. BALANCE REHEAT COIL TO INDICATED REQUIREMENTS.
  - ③ NEW HOT WATER SUPPLY & RETURN TO NEW AHU. NEW PIPE AND ROOF PENETRATION AT EACH COIL.
  - ④ REFER TO DRAWING 611-620 FOR FLOOR PLAN DETAILS.
- INDICATES NEW VAV BOX OR AHU AND FLOW REQUIREMENTS.  
 INDICATES EXISTING VAV BOX OR AHU  
 FLOW MEASURING STATION, SEE DETAIL M-501.

**HW - FLOW SCHEMATIC - 1st FLOOR PLAN**  
 NTS

I:\312M06\312M06.dgn (PLOT) 02/27/04 10:52:11 AM