


NEW LIBRARY ADDITION - FLOOR PLAN - POWER  
SCALE: 1/8" = 1'-0"

DRAWING NOTES


- 1 ELECTRIC REHEAT COIL 11.6KW, 208V, 3φ.
- 2 ELECTRIC REHEAT COIL 8.6KW, 208V, 3φ.
- 3 ELECTRIC REHEAT COIL 19.5KW, 208V, 3φ.
- 4 ELECTRIC REHEAT COIL 8.0KW, 208V, 3φ.
- 5 ELECTRIC REHEAT COIL 3.5KW, 208V, 3φ.
- 6 ELECTRIC REHEAT COIL 2.1KW, 208V, 3φ.
- 7 ELECTRIC REHEAT COIL 2.5KW, 208V, 3φ.
- 8 ELECTRIC REHEAT COIL 3.9KW, 208V, 3φ.
- 9 EXHAUST FAN, 120", 1φ.
- 10 WATER HEATER, 1.5KW, 120V 1φ.
- 11 3P30A FUSED DISCONNECT SWITCH (F815A) IN NEMA 1 ENCLOSURE.
- 12 3P30A FUSED DISCONNECT SWITCH (F830A) IN NEMA 1 ENCLOSURE.
- 13 3P60A FUSED DISCONNECT SWITCH (F840) IN NEMA 1 ENCLOSURE.
- 14 3P100A FUSED DISCONNECT SWITCH (F870A) IN NEMA 1 ENCLOSURE.
- 15 LPB-45, 3 #10 + 1 #10 GROUND IN 3/4"R.
- 16 LPB-51, 3 #10 + 1 #10 GROUND IN 3/4"R.
- 17 LPB-57, 3 #10 + 1 #10 GROUND IN 3/4"R.
- 18 LPB-63, 3 #8 + 1 #8 GROUND IN 1"R.
- 19 LPB-69, 3 #4 + 1 #8 GROUND IN 1"R.
- 20 LPB-52, 3 #12 + 1 #12 GROUND IN 3/4"R.
- 21 FLOOR BOX WITH ONE DUPLEX RECEPTACLE AND BLANK COVER PLATE ON OTHER SIDE. PROVIDE MAXICOM TELEMATIC WITH VC24-CFX.
- 22 1" EMPTY RACEWAY WITH PULL WIRE TO NEAREST CEILING SPACE AND CAP, FOR FUTURE TELECOMMUNICATION CABLE.
- 23 1" EMPTY RACEWAY WITH PULL WIRE FROM FLOOR BOX TO FLOOR BOX.
- 24 PROVIDE NEMA 5-20R RECEPTACLE FOR COPIER.
- 25 FOR WORK IN THIS AREA, REFER TO PART PLAN - COUNTER WORK ON THIS DRAWING.
- 26 ROOF TOP UNIT, 208V, 3φ.
- 27 3P400A FUSED DISCONNECT SWITCH (F8250A) IN NEMA 3R ENCLOSURE.
- 28 LPB-75 3 #1/0 + 1 #4 GROUND IN 1 1/2" R.
- 29 GFI, DUPLEX RECEPTACLE IN WEATHERPROOF ENCLOSURE. MOUNTED ON R.TV UNIT ON ROOF.
- 30 MOUNTING HEIGHT OF RECEPTACLE SHALL BE 36" A.F.F.
- 31 JUNCTION BOX WITH EXISTING SOUND SYSTEM WIRING. CONNECT TO NEW SPEAKERS.



810 Light Street Baltimore Maryland 21230

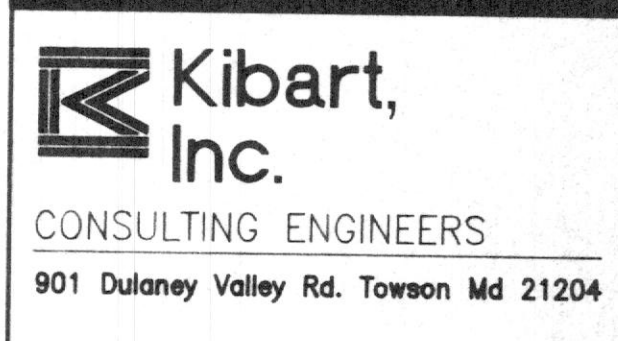

NO.	DATE	DESCRIPTION
REVISIONS		

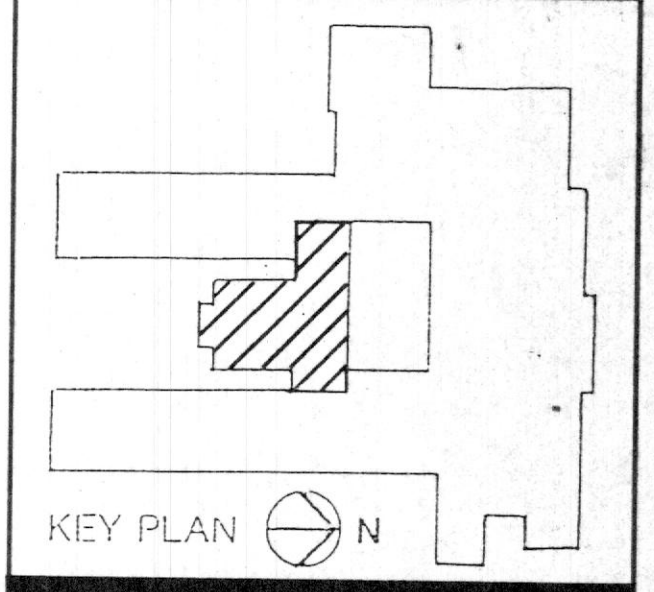

Additions and Renovations to  
**NOTRE DAME  
 PREPARATORY  
 SCHOOL**  
 Towson, Maryland

**NEW POWER PLAN  
 -LIBRARY-**

PROJ. NO.	DWG. NO.
DATE	E-2
MAY 28, 1991	