
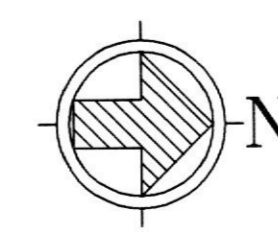


A B C D E F G H J K L M N P Q R S T U

**GENERAL NOTES:**

1. COORDINATE ROUTING OF RAINLEADERS PRIOR TO INSTALLATION OF PIPING WITH DUCTWORK, LIGHTING & STRUCTURE, RUN PIPING UP & AS HIGH AS POSSIBLE

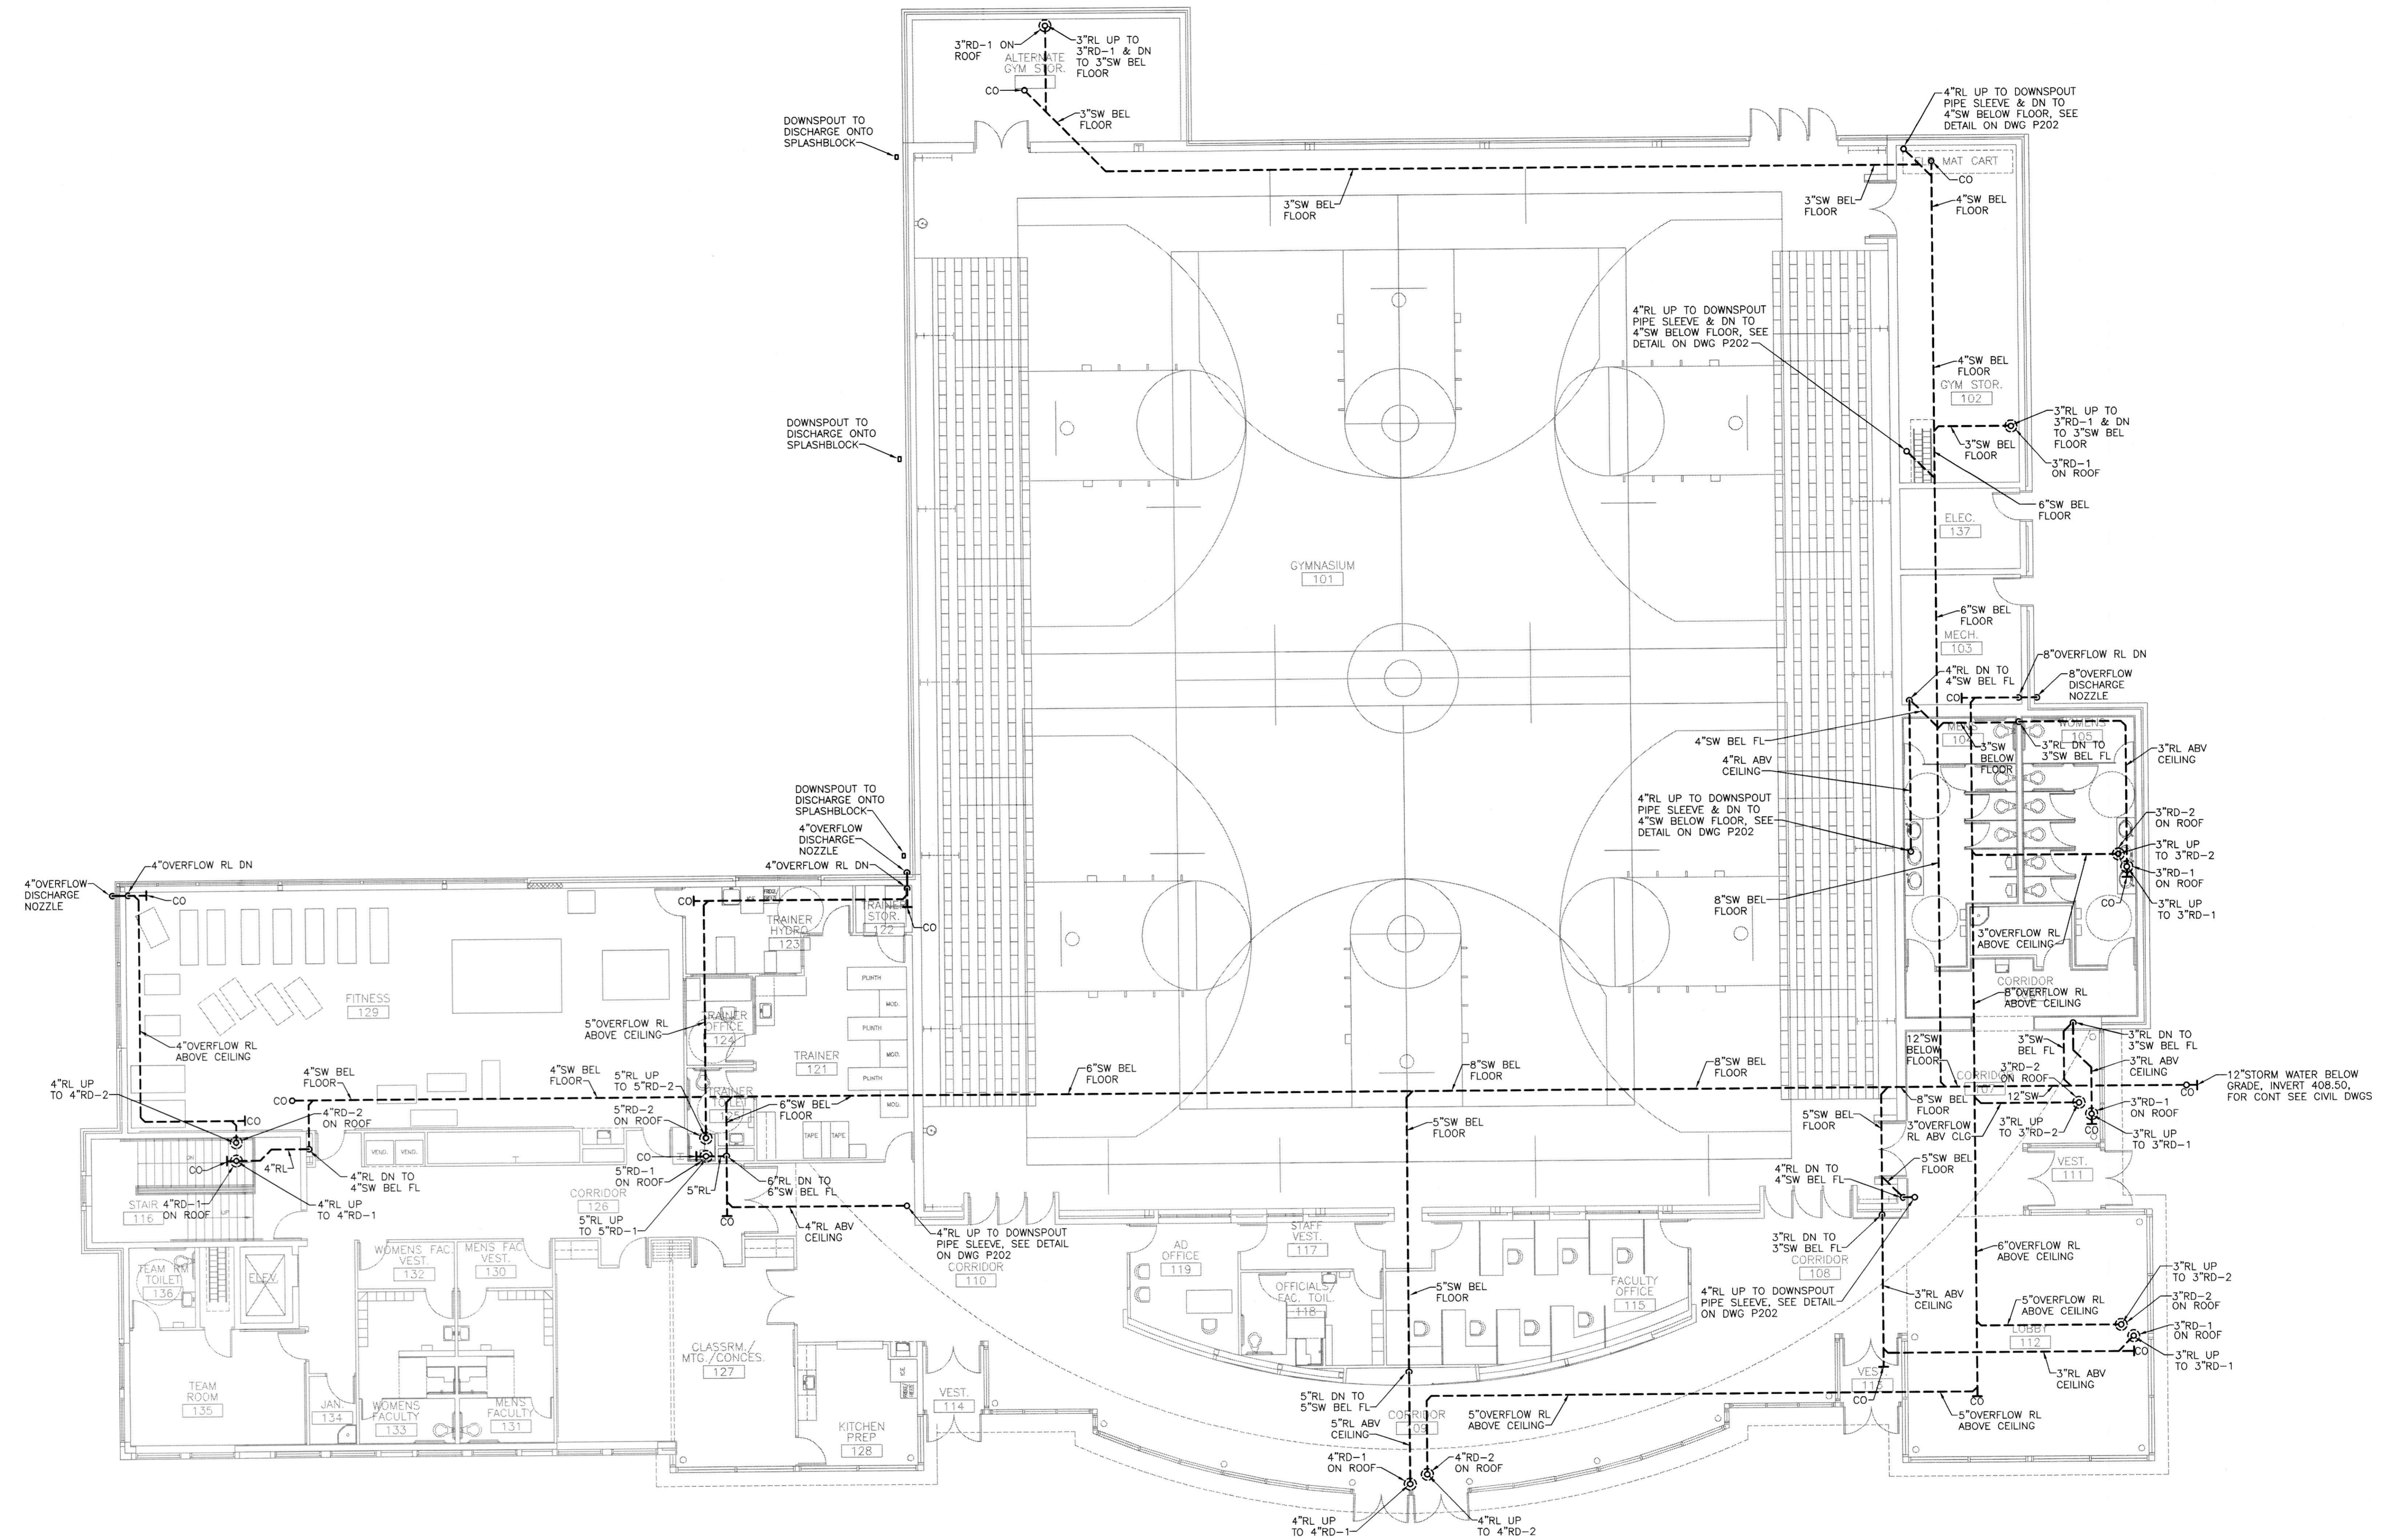


**MAIN FLOOR PLAN - ROOF DRAINAGE - PLUMBING**

SCALE: 1/8" = 1'-0"



**RUBELING & ASSOCIATES, INC.**  
ARCHITECTURE  
INTERIOR DESIGN  
401 JEFFERSON AVENUE  
TOWSON, MARYLAND 21286-5308  
410-337-2886  
FAX: 410-337-3974

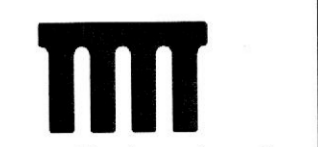

**Century Engineering, Inc.**  
32 West Road  
Towson, Maryland 21284  
Voice (410) 823-8070  
Fax (410) 823-2194

**SPORTS AND FITNESS CENTER  
NOTRE DAME PREPARATORY SCHOOL**

815 HAMPTON LANE  
TOWSON, MARYLAND 21286

95% SUBMISSION

REVISIONS:

| NO. | DESCRIPTION | DATE |
|-----|-------------|------|
|     |             |      |
|     |             |      |
|     |             |      |

LAST REV.:

PROJECT NO.: 02-037

DATE: 2-19-03

SCALE: AS NOTED

TITLE:

**MAIN FLOOR  
PLAN-ROOF  
DRAINAGE  
PLUMBING**

SHEET:

**P**

**104**

22111.01