


REFERENCED NOTES

- ◇ PROVIDE JUNCTION BOX ABOVE THE CEILING.
- ◇ PROVIDE NFSS 600V,1P,30A
- ◇ PROVIDE NFSS 600V,3P,30A.
- ◇ ALL CIRCUITS ON THIS FLOOR SHALL BE FED FROM PANEL RPA UNLESS OTHERWISE NOTED.
- ◇ PROVIDE 120V,1Ø,30A FSS AND CONNECT TO ELEVATOR CAB LIGHTING.
- ◇ PROVIDE 600V,3P,400A FSS AND CONNECT TO ELEVATOR CONTROLLER 480V,3Ø,60FLA. VERIFY REQUIREMENTS WITH SUPPLIER.

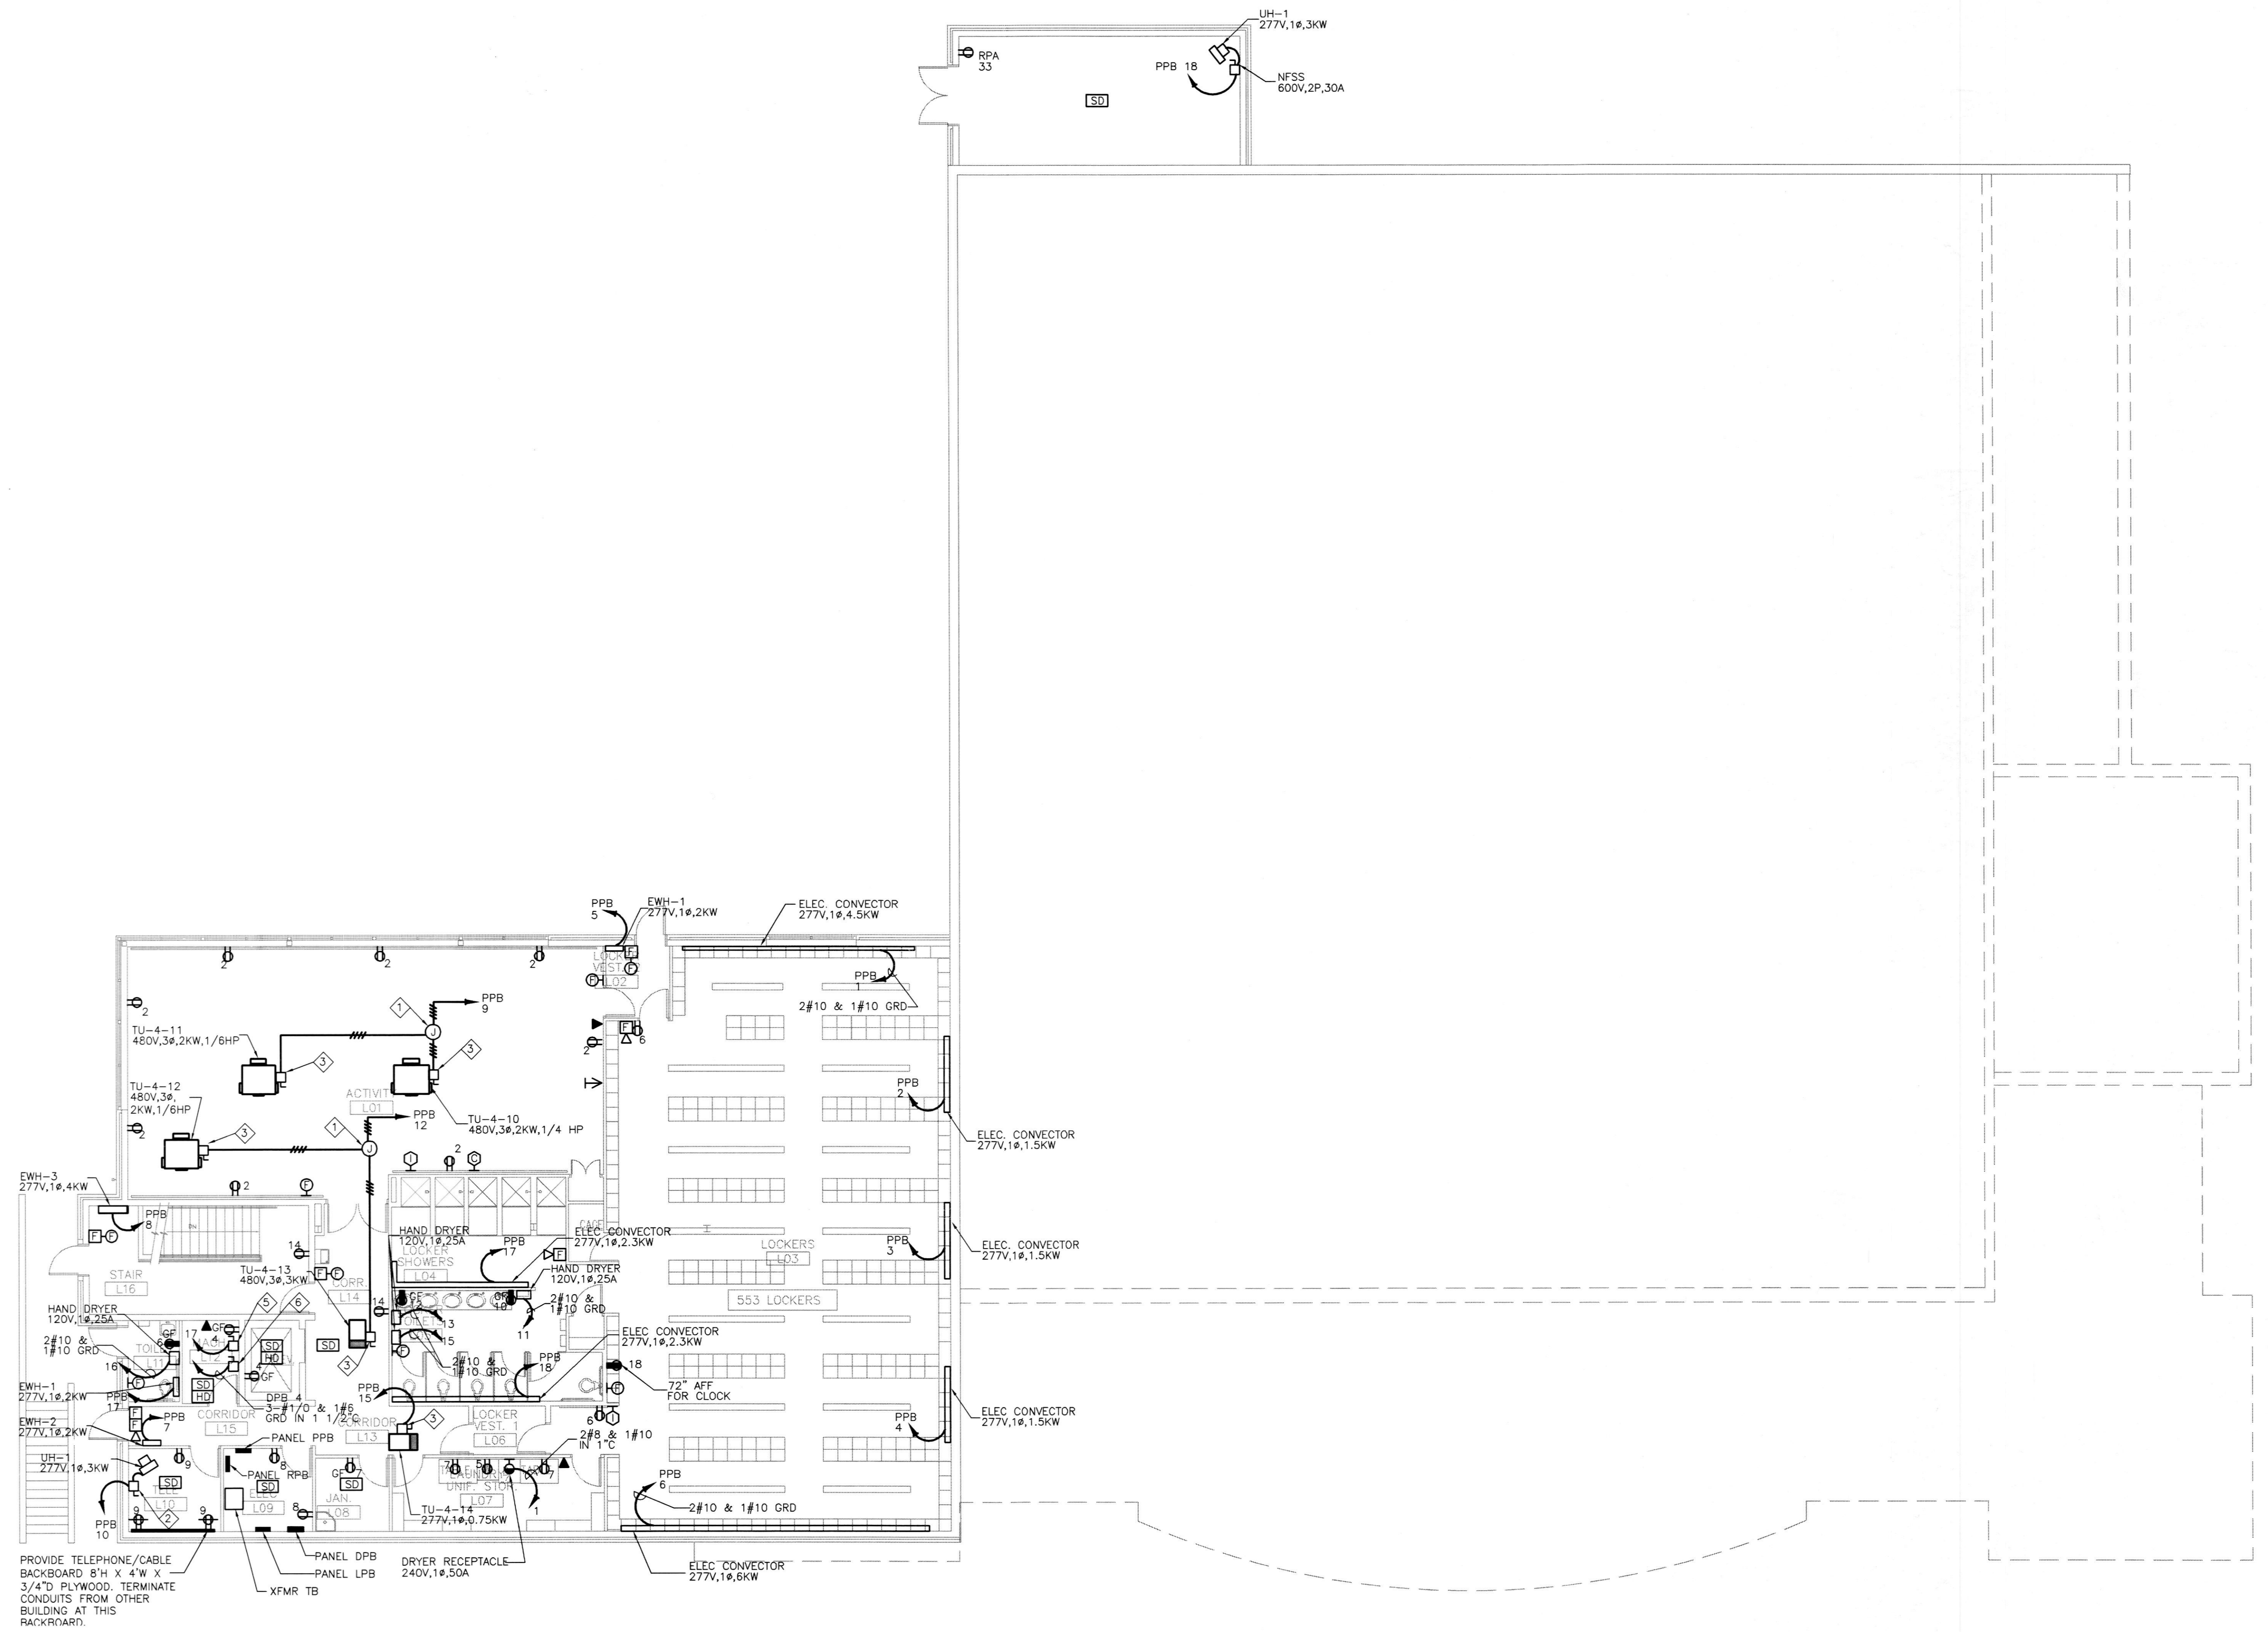

LOWER LEVEL FLOOR PLAN - POWER AND SPECIAL SYSTEMS ◇

SCALE: 1/8" = 1'-0"

SPORTS AND FITNESS CENTER
NOTRE DAME PREPARATORY SCHOOL
 815 HAMPTON LANE
 TOWSON, MARYLAND 21286

95% SUBMISSION

REVISIONS:		
NO.	DESCRIPTION	DATE

LAST REV.:
 PROJECT NO.: 02-037
 DATE: 2-19-03
 SCALE: AS NOTED
 TITLE:

LOWER FLOOR PLANS
 -POWER AND SPECIAL SYSTEMS

SHEET:
E

103

