


108 I-803-42  
502-64  
7.8.1


FLOOR PLAN - LOWER LEVEL - LIGHTING

SCALE: 1/8" = 1'-0"

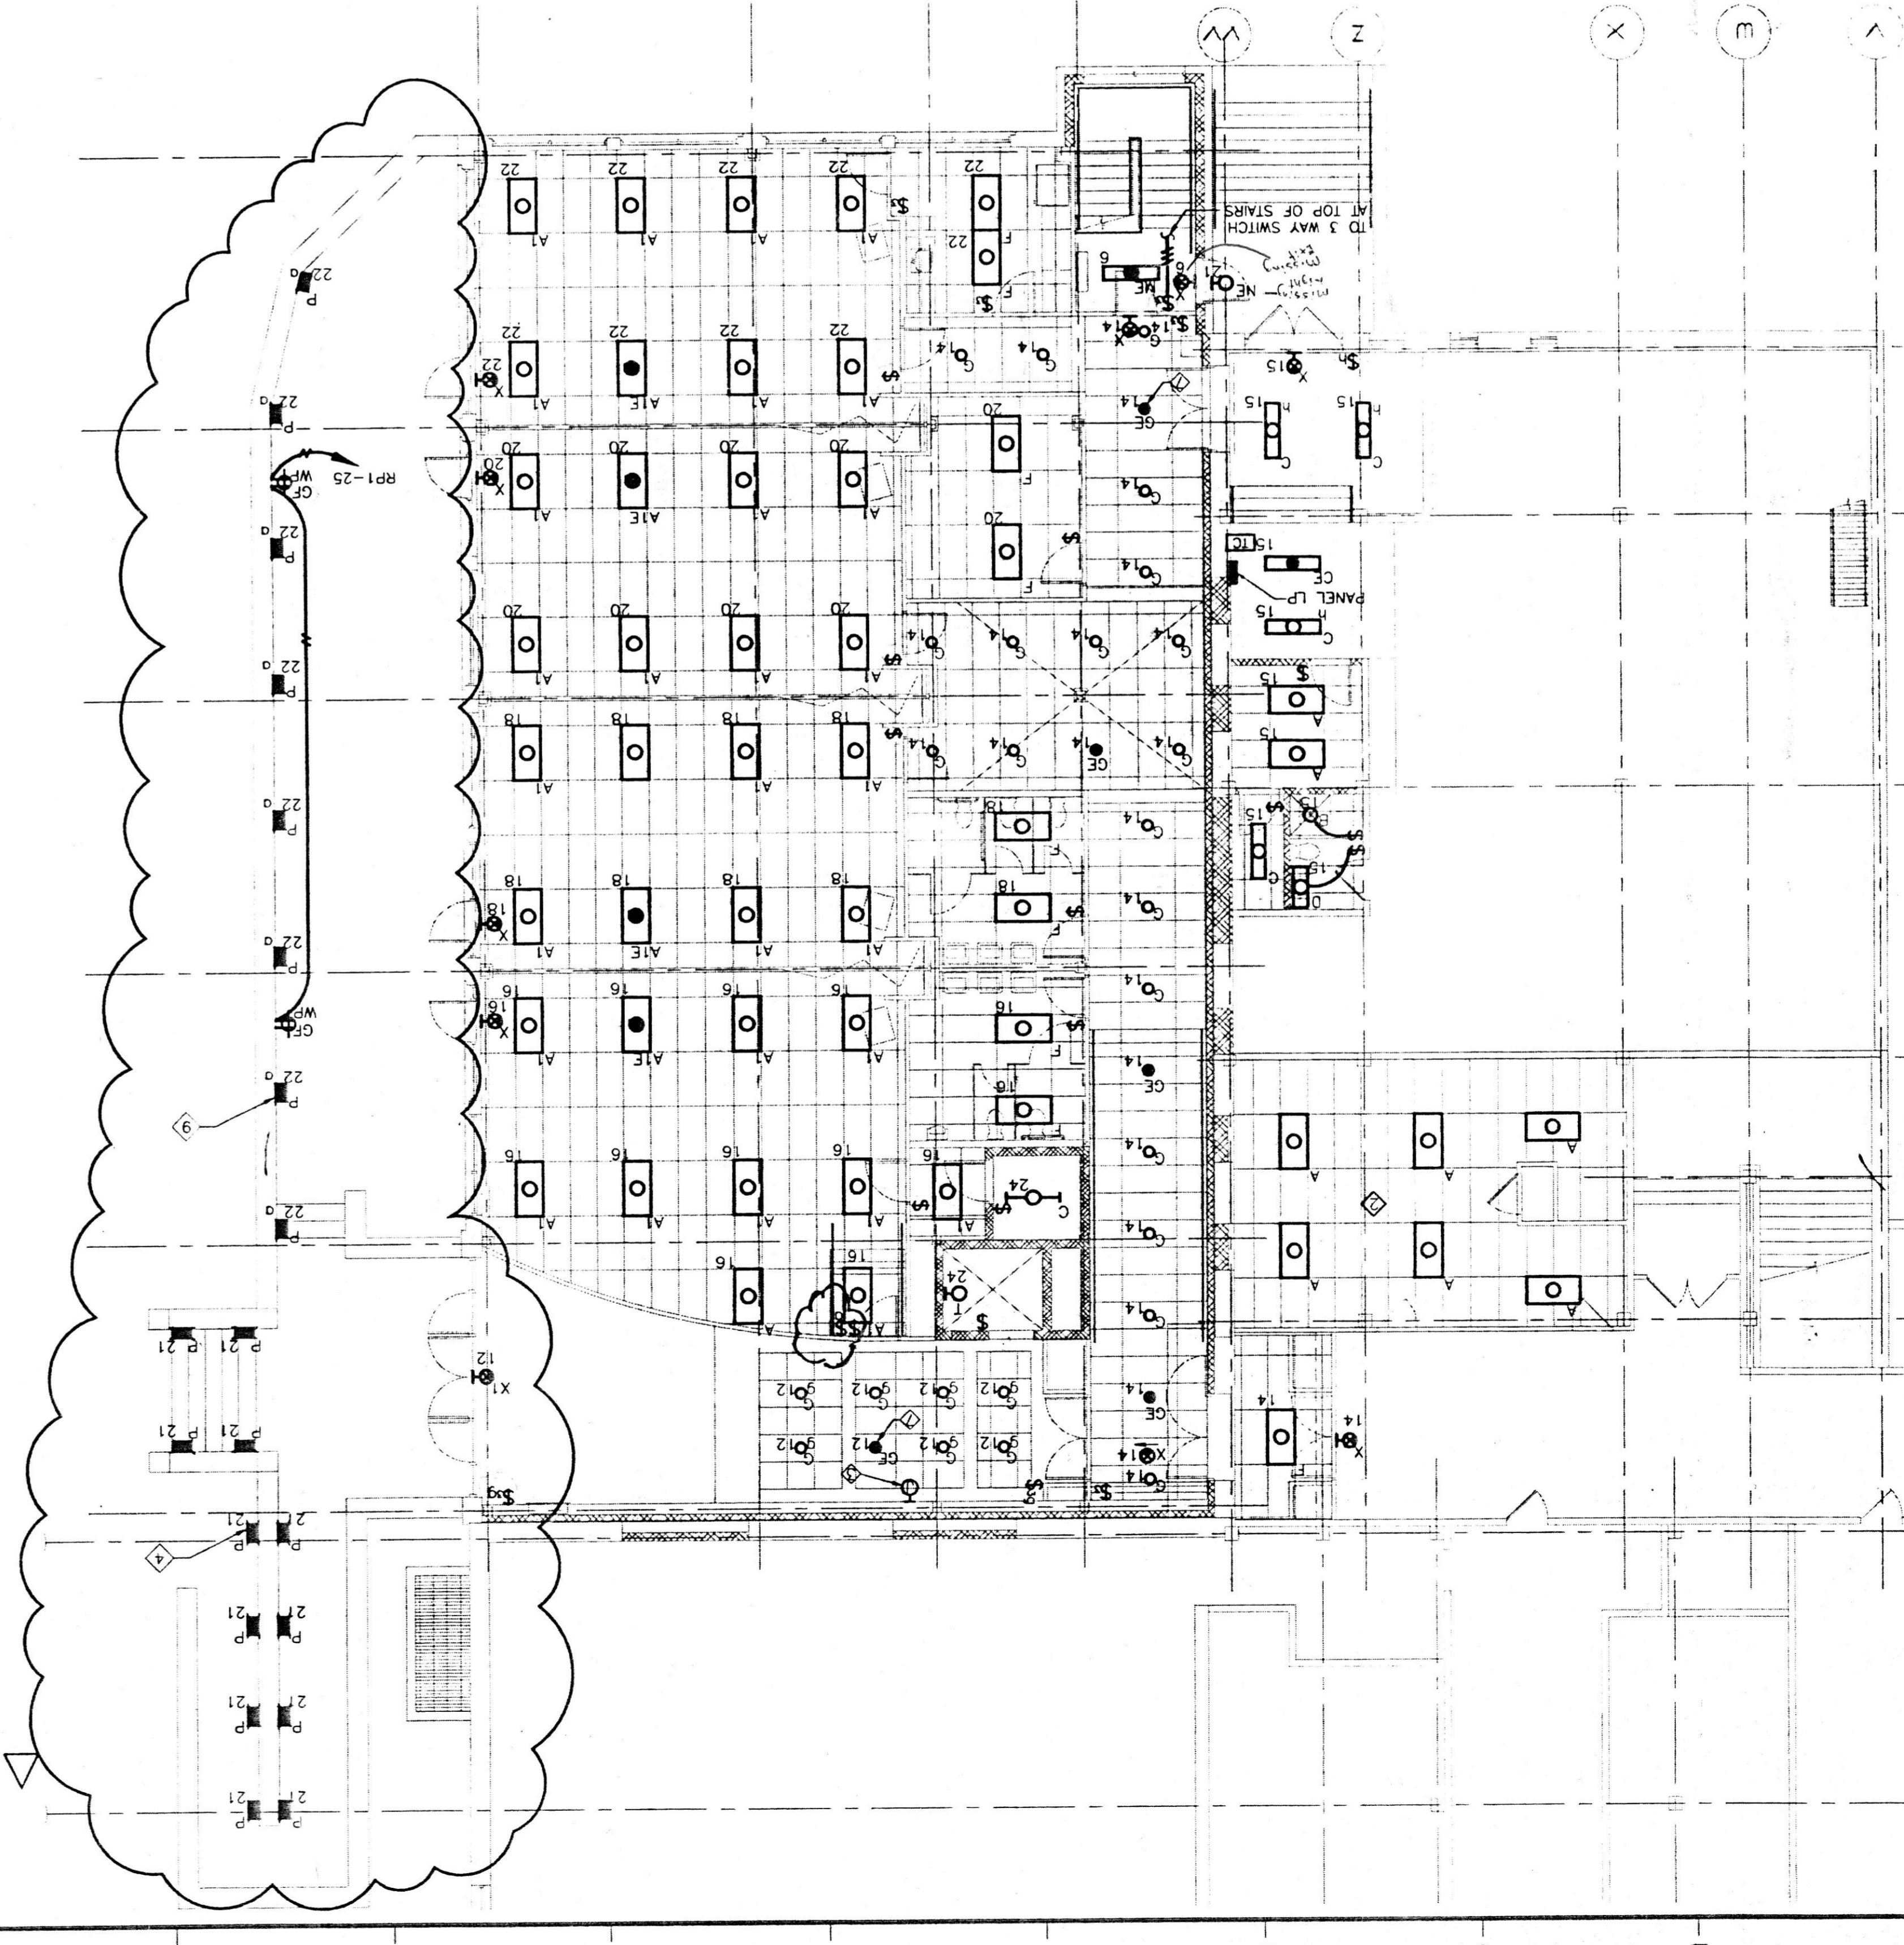

FLOOR PLAN - MAIN LEVEL - LIGHTING

SCALE: 1/8" = 1'-0"

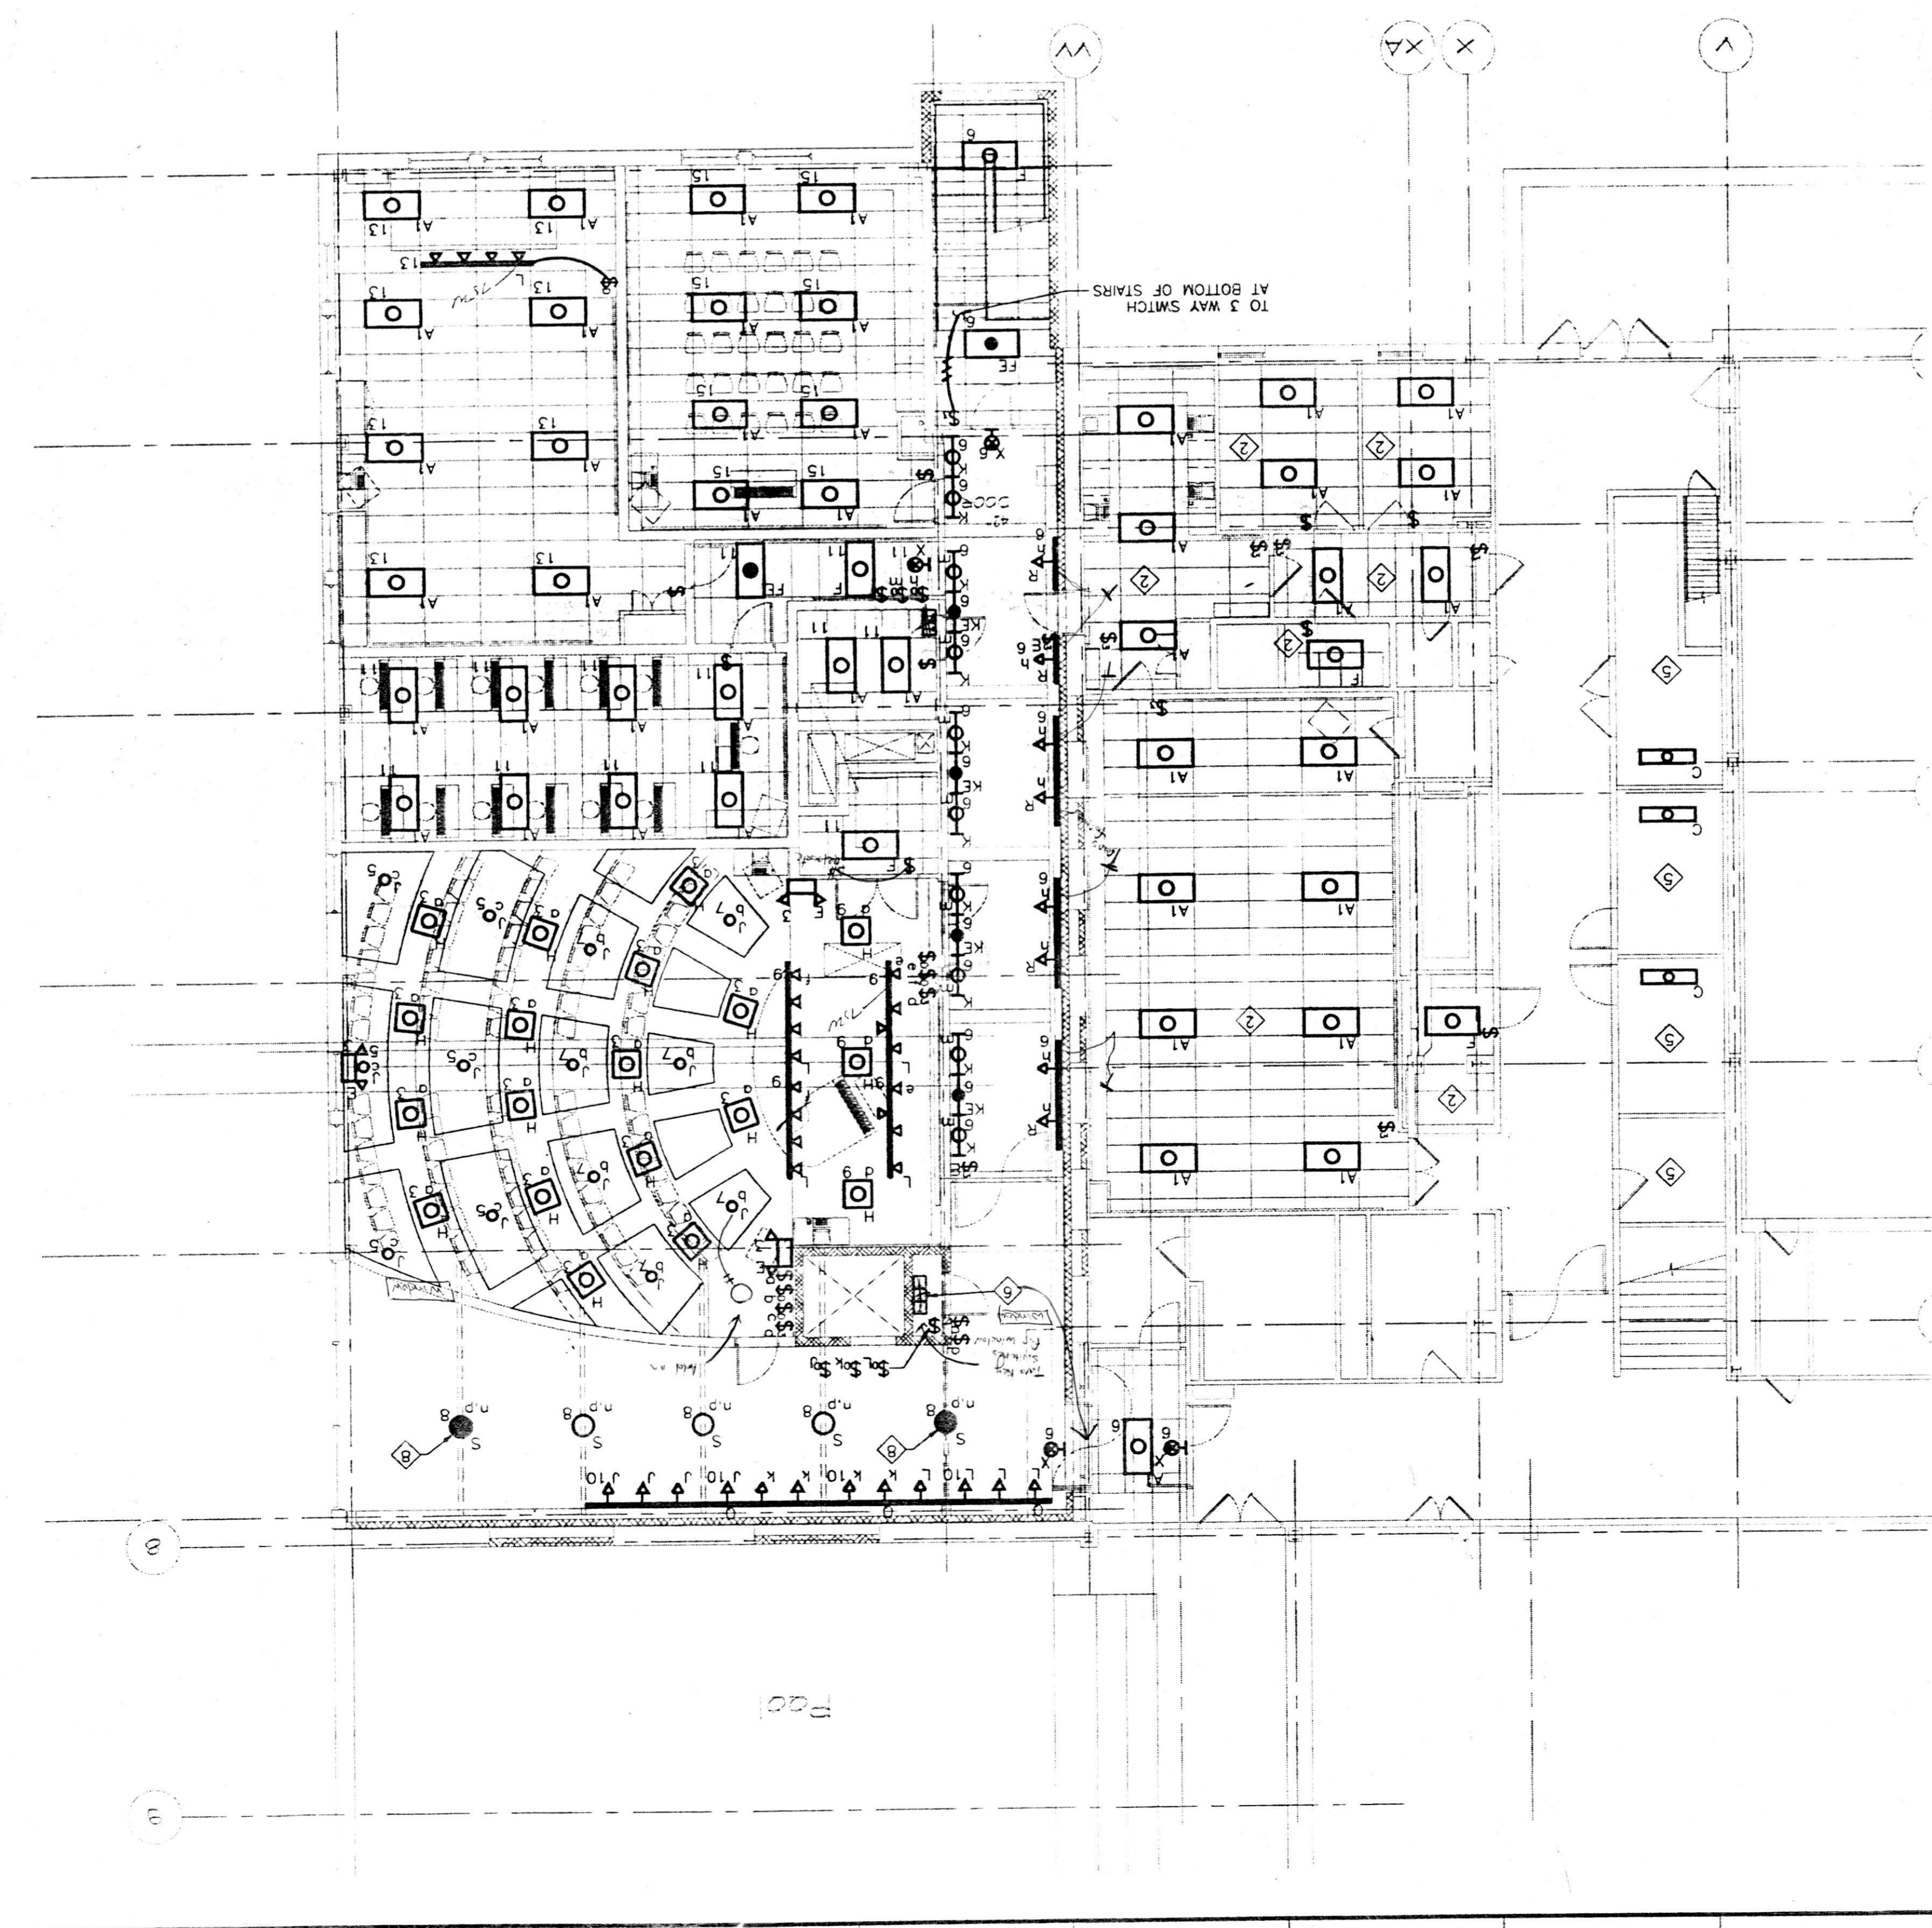

REFERENCED NOTES:

- 1 ALL CIRCUITS ON THIS PLAN SHALL BE CONNECTED TO PANEL LP, UNLESS NOTED OTHERWISE.
- 2 CONNECT NEW FIXTURES IN THIS AREA TO THE EXISTING LIGHTING CIRCUIT.
- 3 PROVIDE A JUNCTION BOX IN ACCESSIBLE CEILING SPACE FOR DISPLAY CABINET LIGHTING. CONNECT TO CIRCUIT LP 17. MAKE ALL FINAL CONNECTIONS.
- 4 EXTERIOR WALL FIXTURES, TYPES NE AND P, ON CIRCUIT LP-21 SHALL BE CONTROLLED BY A PHOTOCELL (MOUNTED OFF ON BLDG ROOF NEAR STAIRWELL AT COL. LINE W) AND TURNED OFF VIA A 24 HR. TIME CLOCK. PROVIDE A PARAGON 24 HR. GENERAL PURPOSE TIME CONTROL, DST SWITCH WITH SKIP-A-DAY AND ASTRONOMICAL DIAL FEATURES, (MOUNTED ADJACENT TO PANEL LP) MAKE ALL FINAL CONNECTIONS.
- 5 CONTRACTOR SHALL REARRANGE EXISTING LIGHTING TO CORRESPOND WITH NEW ROOM LAYOUT. LIGHT FIXTURES MAY BE ADDED IF REQUIRED. ALL LIGHTS SHALL BE CONNECTED TO THE EXISTING LIGHTING CIRCUIT FOR THIS AREA. MAKE ALL FINAL CONNECTIONS.
- 6 DATE: FEB. 17, 1999  
PROJECT NO.: 98-033  
SCALE: AS NOTED  
TITLE: FLOOR PLANS - PERFORMING ARTS LIGHTING
- 7 FIXTURE TYPE 'GE' IN CORRIDOR SHALL BE WIRED AHEAD OF SWITCH FOR NIGHT LIGHTING. (TYP.)
- 8 PROVIDE BATTERY BACK-UP FOR (1) LAMP IN FIXTURE FOR EMERGENCY LIGHTING. BATTERY UNIT SHALL BE MOUNTED IN BEAM ADJACENT TO FIXTURE. MAKE ALL FINAL CONNECTIONS.
- 9 FIXTURE TYPE 'P' SHALL BE A RECESSED STEP LIGHT AS MANUFACTURED BY BEGA, CAT. NO. 2179P OR APPROVED EQUAL 920 9W. PL LAMPS, 120V. FIXTURES LOCATED AT STAIRS AND RAMP SHALL BE MTD.

1.0' F SHEET

PERFORMING ARTS AND CLASSROOM ADDITIONS  
NOTRE DAME PREPARATORY SCHOOL

TOWSON, MARYLAND

CENTURY ENGINEERING  
1300 KENNEDY BLVD.  
TOWSON, MARYLAND 21286  
TEL: 410-287-3900  
FAX: 410-287-3900

RUBBING ARCHITECTURE & ASSOCIATES INC.  
401 JEFFERSON AVENUE  
TOWSON, MARYLAND 21286-3300  
TEL: 410-287-3900  
FAX: 410-287-3900

REVISIONS:

NO. 1	DATE	DESCRIPTION
1	7/9/99	ISSUED FOR PERFORMING ARTS LIGHTING

LAST REV.:

DATE: FEB. 17, 1999  
PROJECT NO.: 98-033  
SCALE: AS NOTED  
TITLE: FLOOR PLANS - PERFORMING ARTS LIGHTING