

BOILER REPLACEMENT FOR

NOTRE DAME PREPARATORY SCHOOL

815 HAMPTON LANE BALTIMORE, MD 21286


BOILER REPLACEMENT FOR
NOTRE DAME PREPARATORY SCHOOL
 815 HAMPTON LANE
 TOWSON, BALTIMORE COUNTY, MARYLAND 21286




James Posey Associates
 Engineering Your Vision
 Mechanical & Electrical
 Consulting Engineers
 3112 Lord Baltimore Drive
 Baltimore, MD 21244
 tel 410-265-6100
 fax 410-298-9820
 jamesposey.com

PROFESSIONAL CERTIFICATION
 These contract documents for Notre Dame Preparatory School were prepared under my supervision and to the best of my knowledge, information, and belief, they comply with the relevant building codes of the State of Maryland.
 _____ (Date) February 26, 2010
 Maryland Professional Engineer Registration No. 19159

VICINITY PLAN

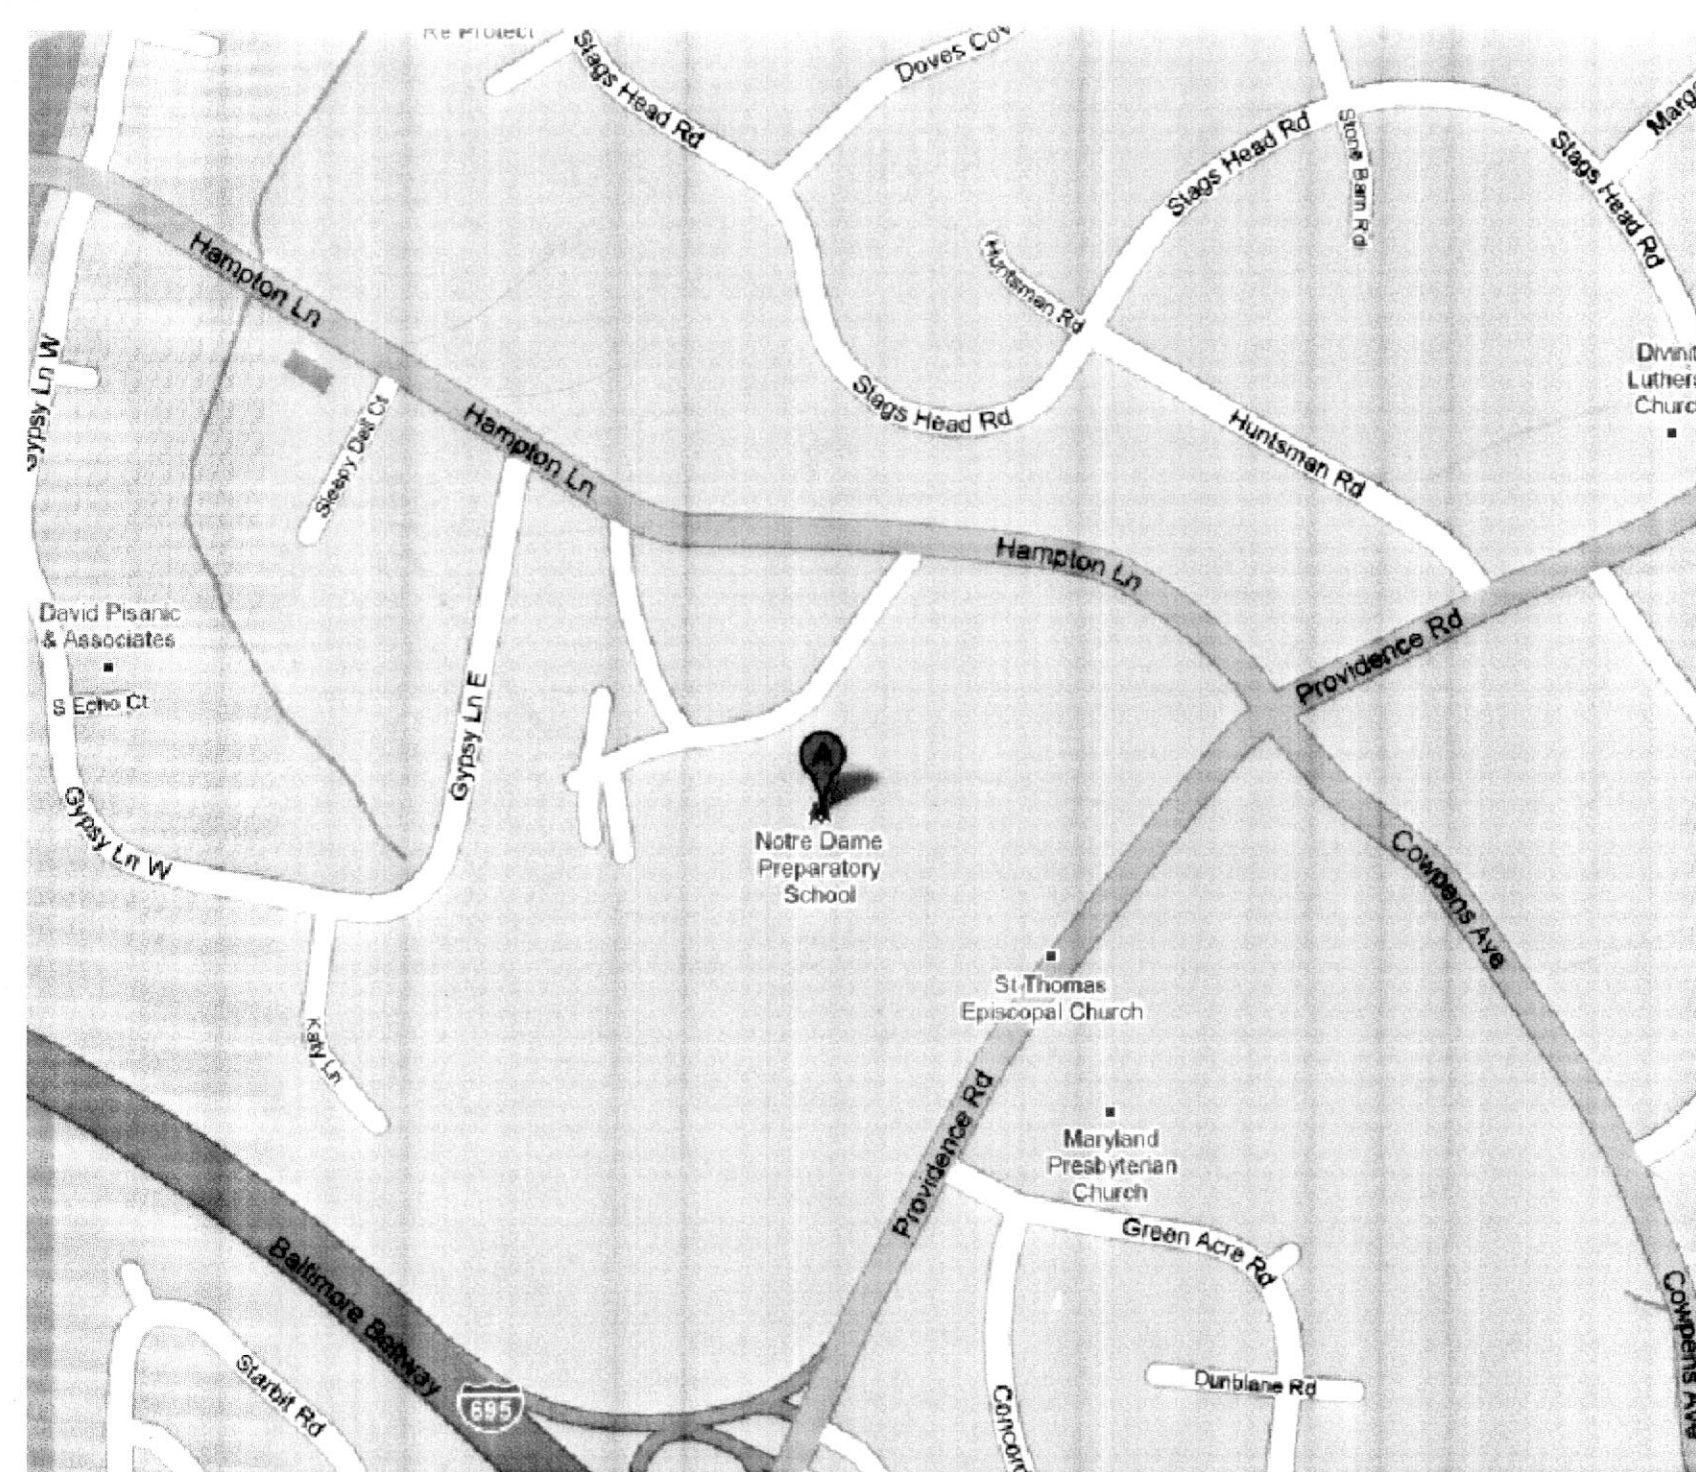

SITE LOCATION PLAN

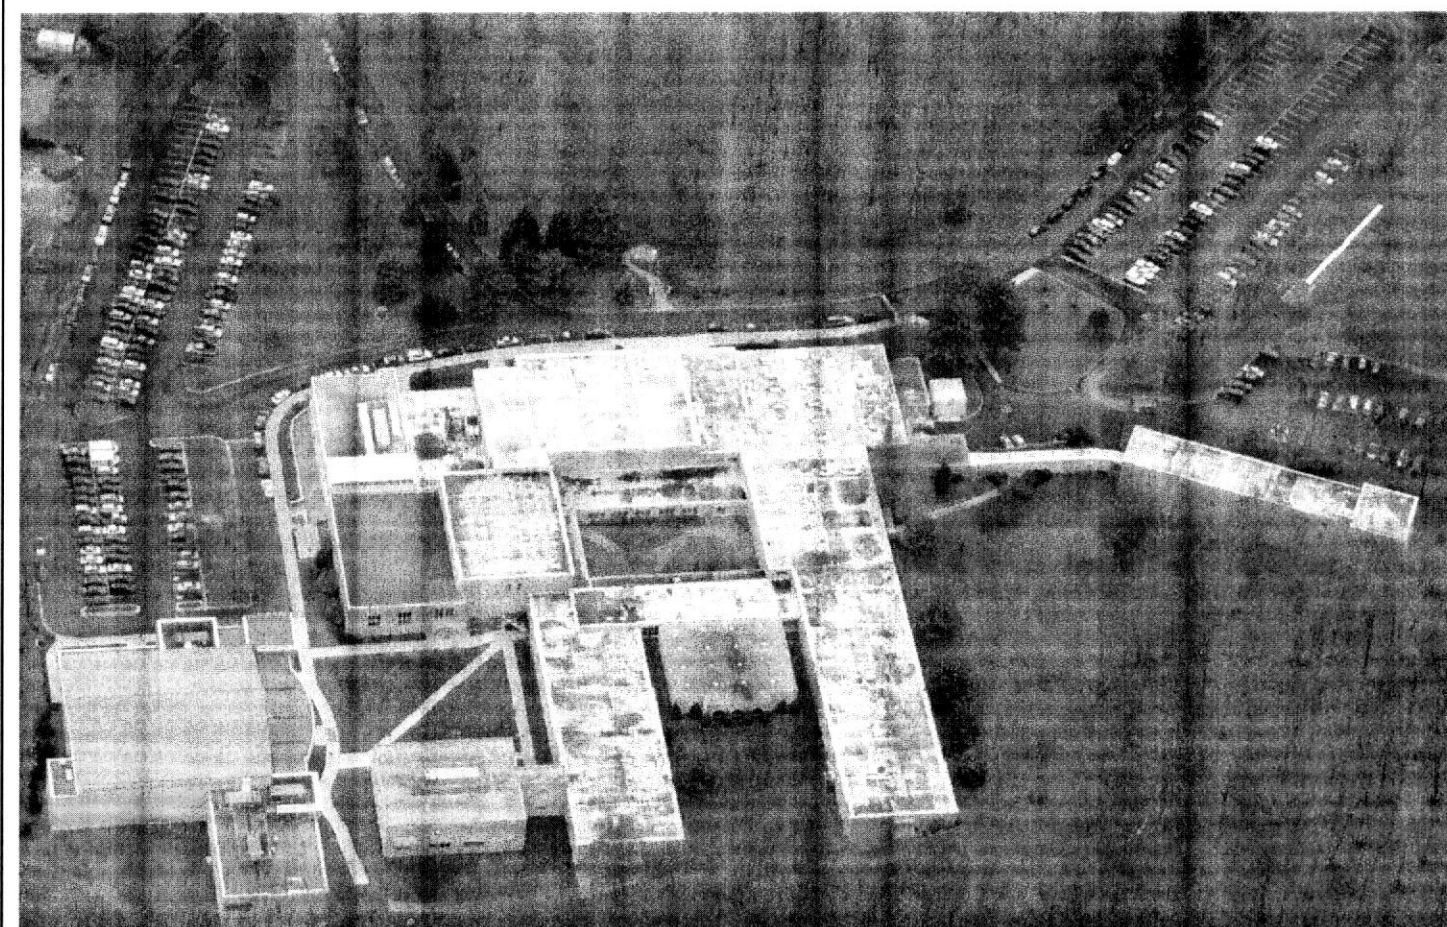

DRAWING INDEX

- COVER SHEET**
- T1.1 TITLE SHEET
- MECHANICAL**
- M0.1 SYMBOLS AND ABBREVIATIONS
 - M1.1 PART FLOOR PLAN MECHANICAL ROOM - HVAC
 - M5.1 DIAGRAMS
 - M5.2 DETAILS AND SECTIONS
 - M6.1 SCHEDULES
 - M7.1 ATC SEQUENCES
 - M7.2 ATC SEQUENCES
 - M7.3 INPUT/OUTPUT SCHEDULE
- ELECTRICAL**
- E0.1 SYMBOLS AND ABBREVIATIONS
 - E1.1 PART FLOOR PLAN MECHANICAL ROOM - POWER
 - E6.1 PANEL SCHEDULES

APPLICABLE CODES AND STANDARDS

- 2006 IBC: INTERNATIONAL BUILDING CODE
 - 2006 IMC: INTERNATIONAL MECHANICAL CODE
 - 2006 IMEC: INTERNATIONAL MODEL ENERGY CONSERVATION CODE WITH BALTIMORE COUNTY AMENDMENTS
 - 2006 IFC: INTERNATIONAL FIRE CODE BALTIMORE COUNTY FIRE PREVENTION CODE
 - 2006 IFG: INTERNATIONAL FUEL GAS CODE
 - 2006 IPC: INTERNATIONAL PLUMBING CODE WITH BALTIMORE COUNTY PLUMBING AND GAS FITTING CODE
 - NATIONAL FIRE PROTECTION ASSOCIATION, NFPA 13 AND 54 LATEST VERSION
 - NFPA 70: NATIONAL FIRE PROTECTION ASSOCIATION, NATIONAL ELECTRICAL CODE LATEST EDITION
 - 2006 IEC: INTERNATIONAL ELECTRICAL CODE
 - NFPA 90A: STANDARD FOR INSTALLATION OF AIR CONDITIONING AND VENTILATION SYSTEMS LATEST EDITION
 - ASHRAE 2005-2009 HANDBOOK
- NOTE:** NOT ALL CODES AND STANDARDS ARE LISTED ABOVE THAT APPLY TO THIS PROJECT.

Comm. No. 5806-09

Sym.	REVISIONS	Date

Drawn	AMB
Designed	TG&
Checked	SJH
Approved	

Scale	
Comm No	5806-09
Date	4/7/2010

Drawing Title
TITLE SHEET

Sheet No:
T1.1

April 06, 2010 6:05 AM
 D:\b\10584-09-C-REVISED\JOB\10584-09-01-01.dwg TSCHEBGR
 © 2010 James Posey Associates, Inc.