


MAIN FLOOR PLAN
SCALE 1/8"=1'-0"


Schedule-Power Panel "K-P"

Circ. No.	Feeds	Pk. Volts	Breaker Type
1	Waters, 1 HP	3/208	30A
2	Food Chopper, 3/4 HP	3/208	30A
3	Garbage Grinder, 3 HP	3/208	30A
4	Food Warmer, 2 KW	3/208	30A
5	Dispenser, 2 HP	3/208	30A
6	Dispenser, 1/2 KW	3/208	30A
7	Food Warmer, 3750W	1/110	20A
8	Food Warmer, 3750W	1/110	20A
9	Food Warmer, 3750W	1/110	20A
10	Food Warmer, 3750W	1/110	20A
11	Food Warmer, 3750W	1/110	20A
12	Food Warmer, 3750W	1/110	20A
13	Food Warmer, 3750W	1/110	20A
14	Food Warmer, 3750W	1/110	20A
15	Food Warmer, 3750W	1/110	20A
16	Food Warmer, 3750W	1/110	20A
17	Food Warmer, 3750W	1/110	20A
18	Food Warmer, 3750W	1/110	20A
19	Food Warmer, 3750W	1/110	20A
20	Food Warmer, 3750W	1/110	20A

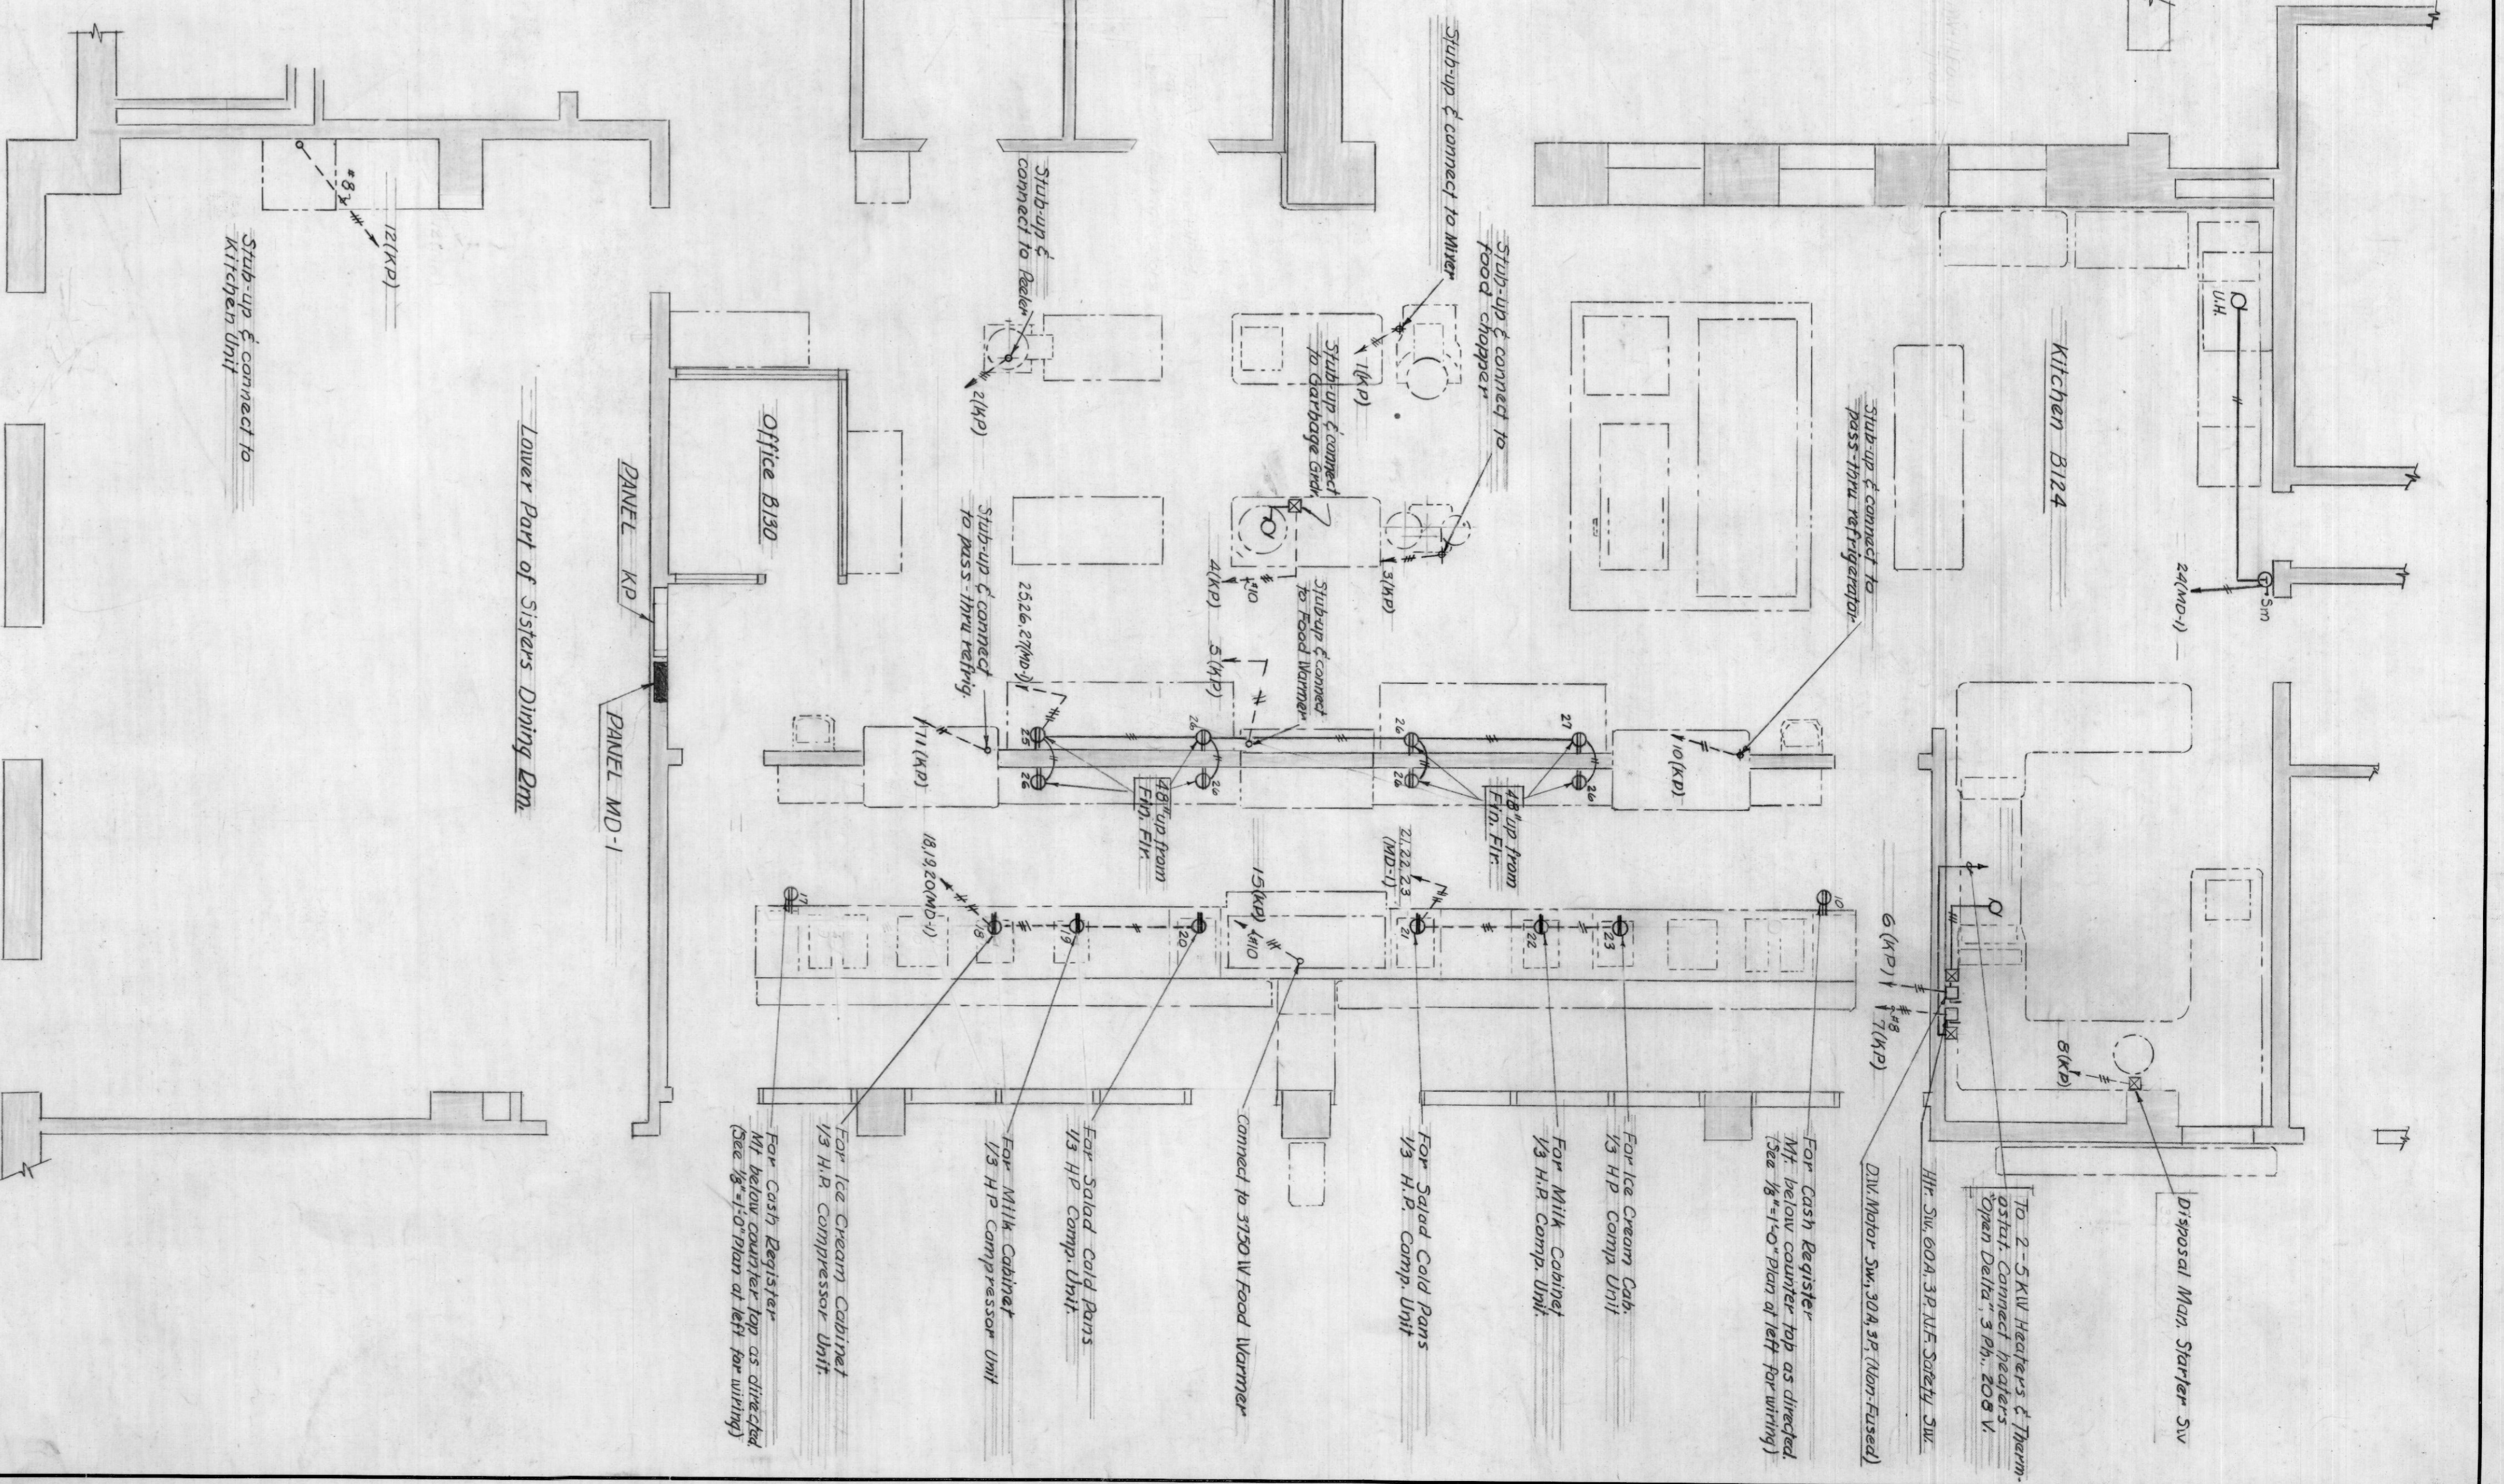

KITCHEN AREA PLAN-EQUIPMENT WIRING
Scale 1/4"=1'-0"

Notes:
1. Provide 3 empty 3/4" conduits from panel to kitchen ceiling.
2. Provide 3 empty 3/4" conduits from panel to kitchen ceiling.

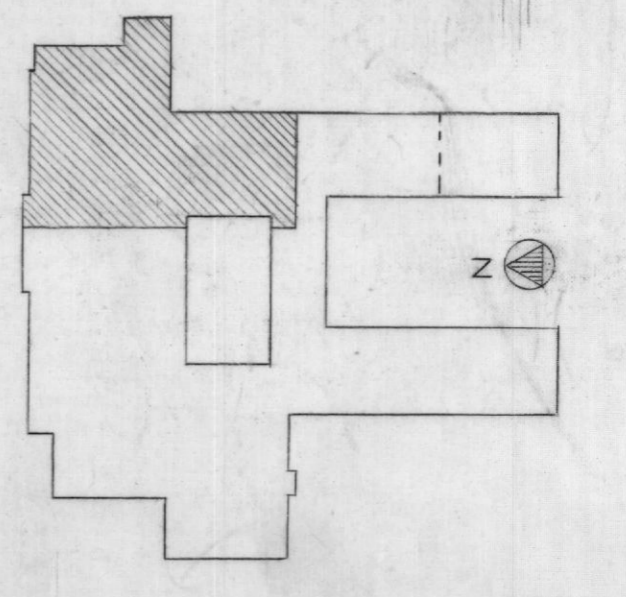

MAIN FLOOR PLAN PART B

NOTRE DAME PREPARATORY SCHOOL
BALTIMORE COUNTY, MARYLAND
UPPER SCHOOL
FOR THE
SCHOOL SISTERS OF NOTRE DAME

TAYLOR AND FISHER ARCHITECTS
130 W. HANLINGTON ST., BALTIMORE 1, MD.
VAN RENSSALAER P. Saxe - STRUCTURAL ENGINEERS
HENRY ADAMS, INC. - MECHANICAL ENGINEERS
MARTIN FUNNELL - LANDSCAPE ARCHITECT

JOB NO. 1115
DATE: 2/28/64

E-4
DATE: 2/28/64