


D

C


B

A

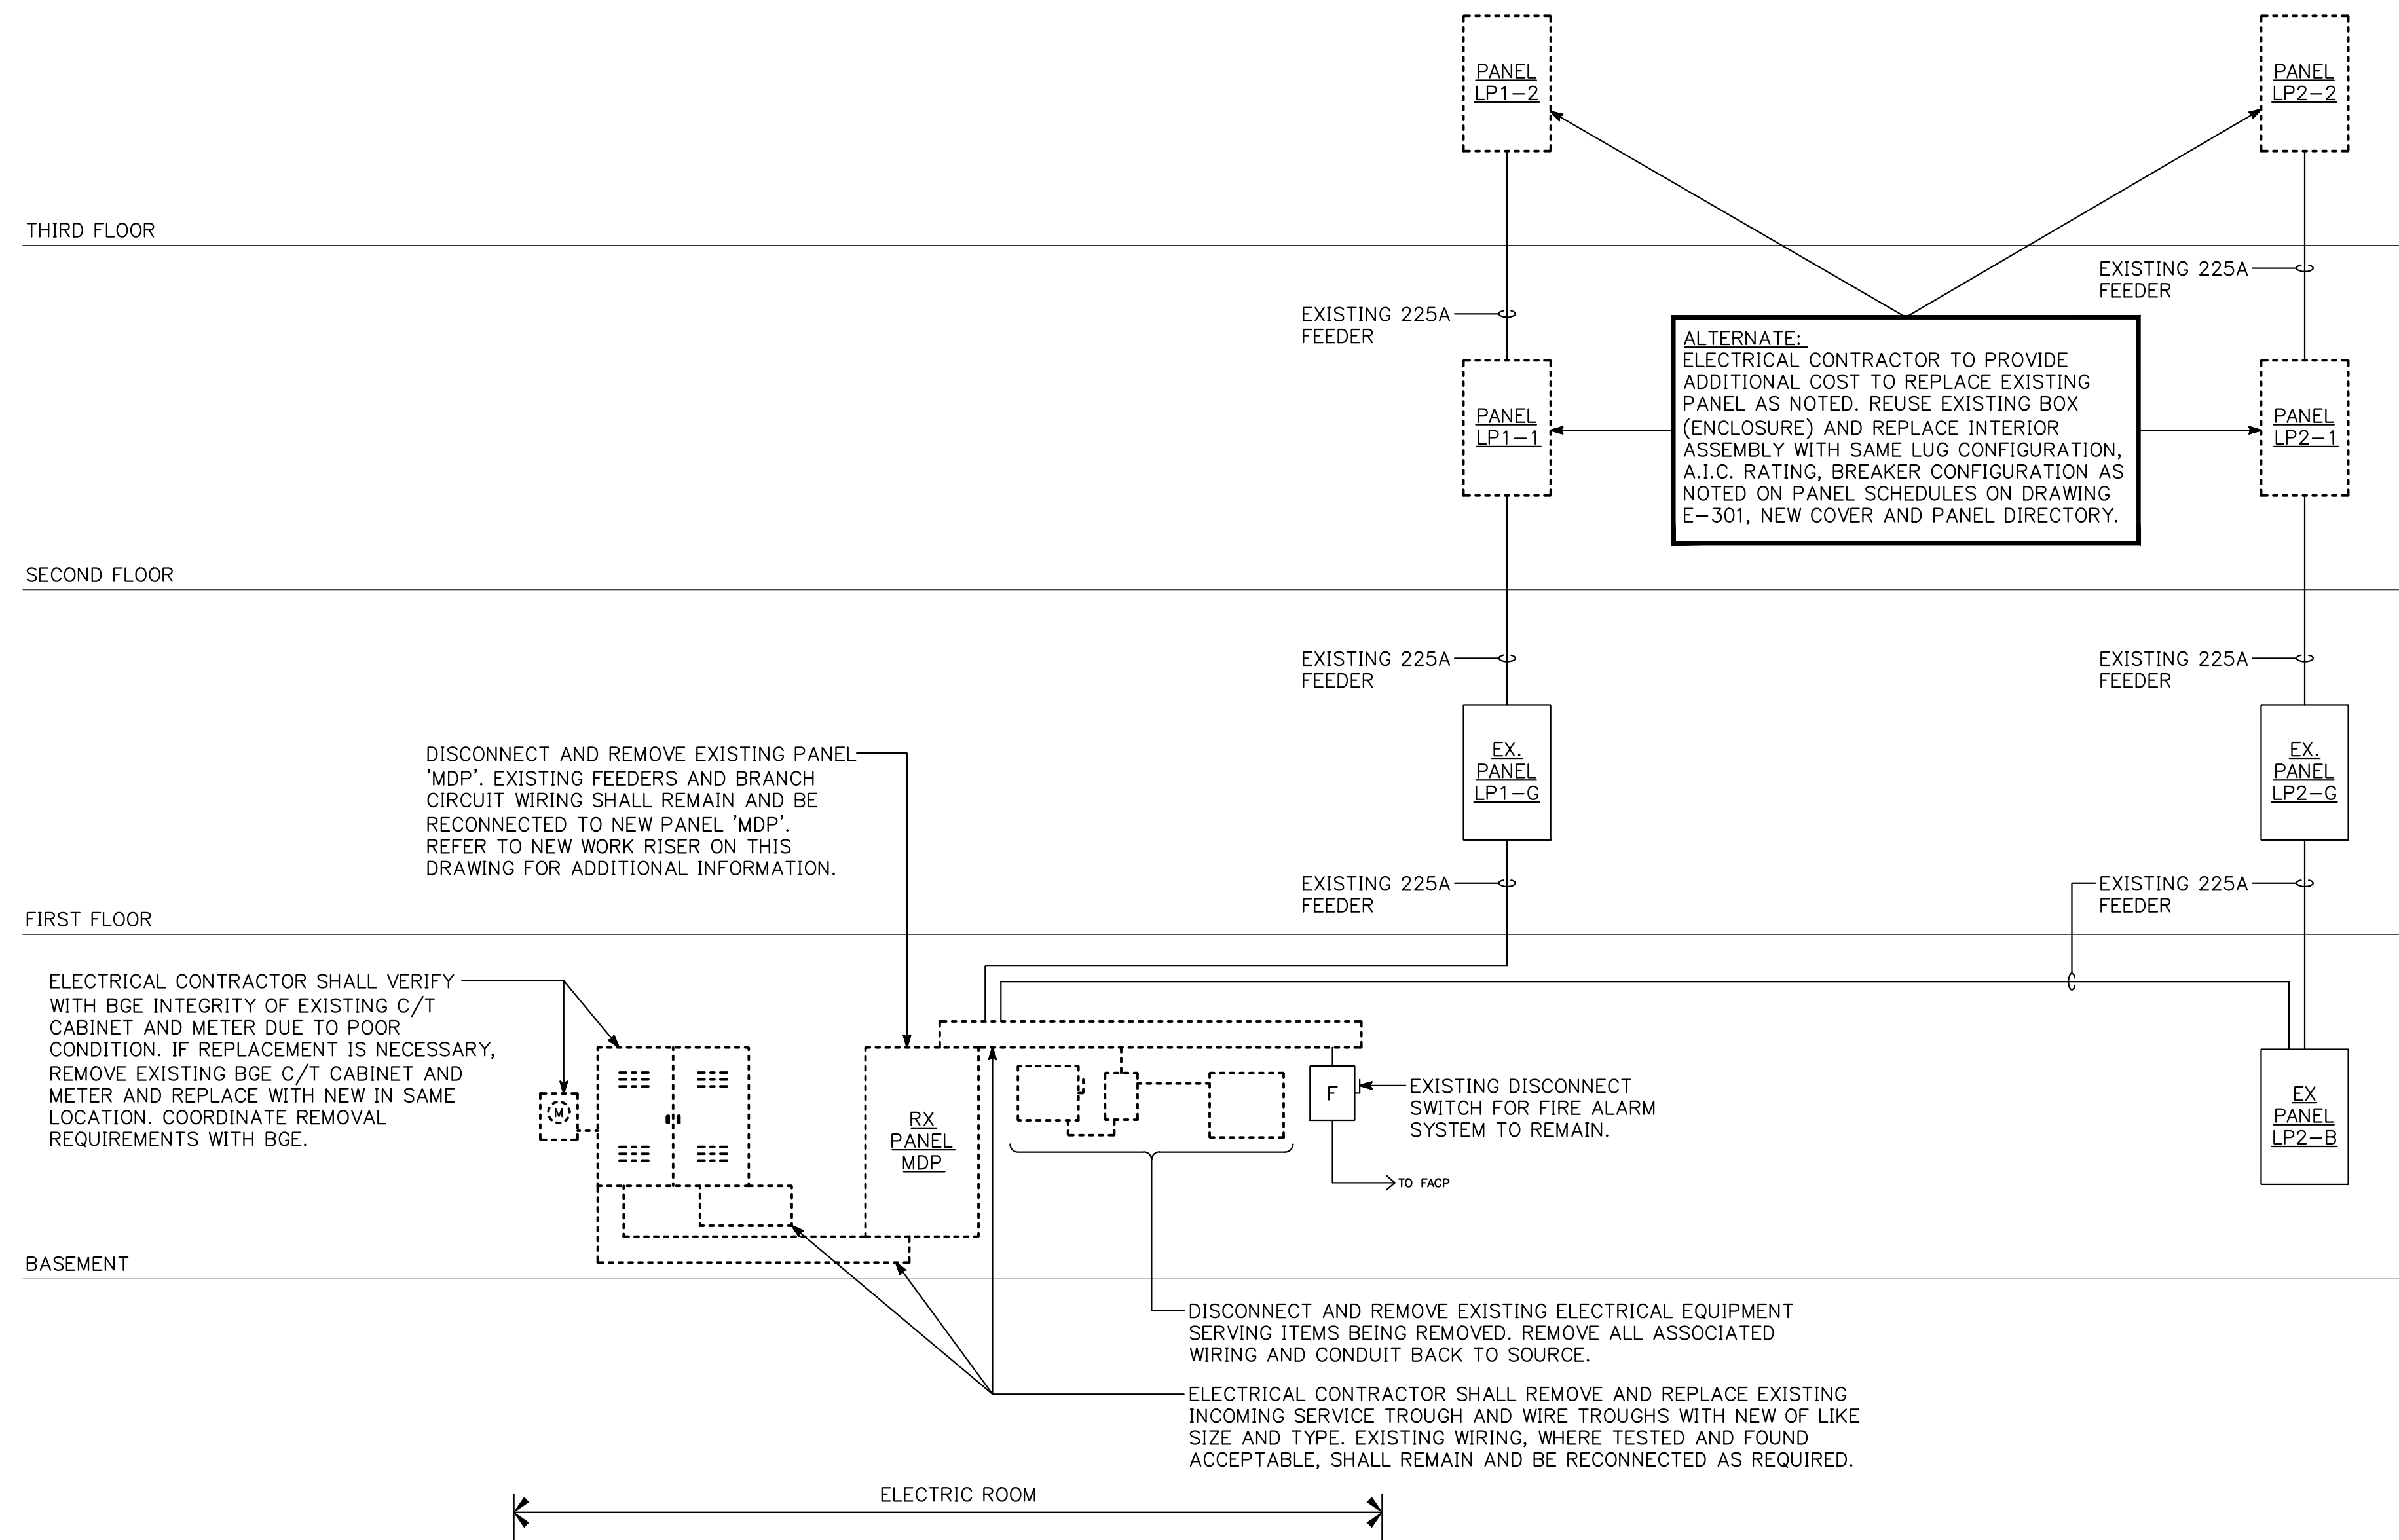

**POWER RISER DIAGRAM - DEMOLITION**

NO SCALE

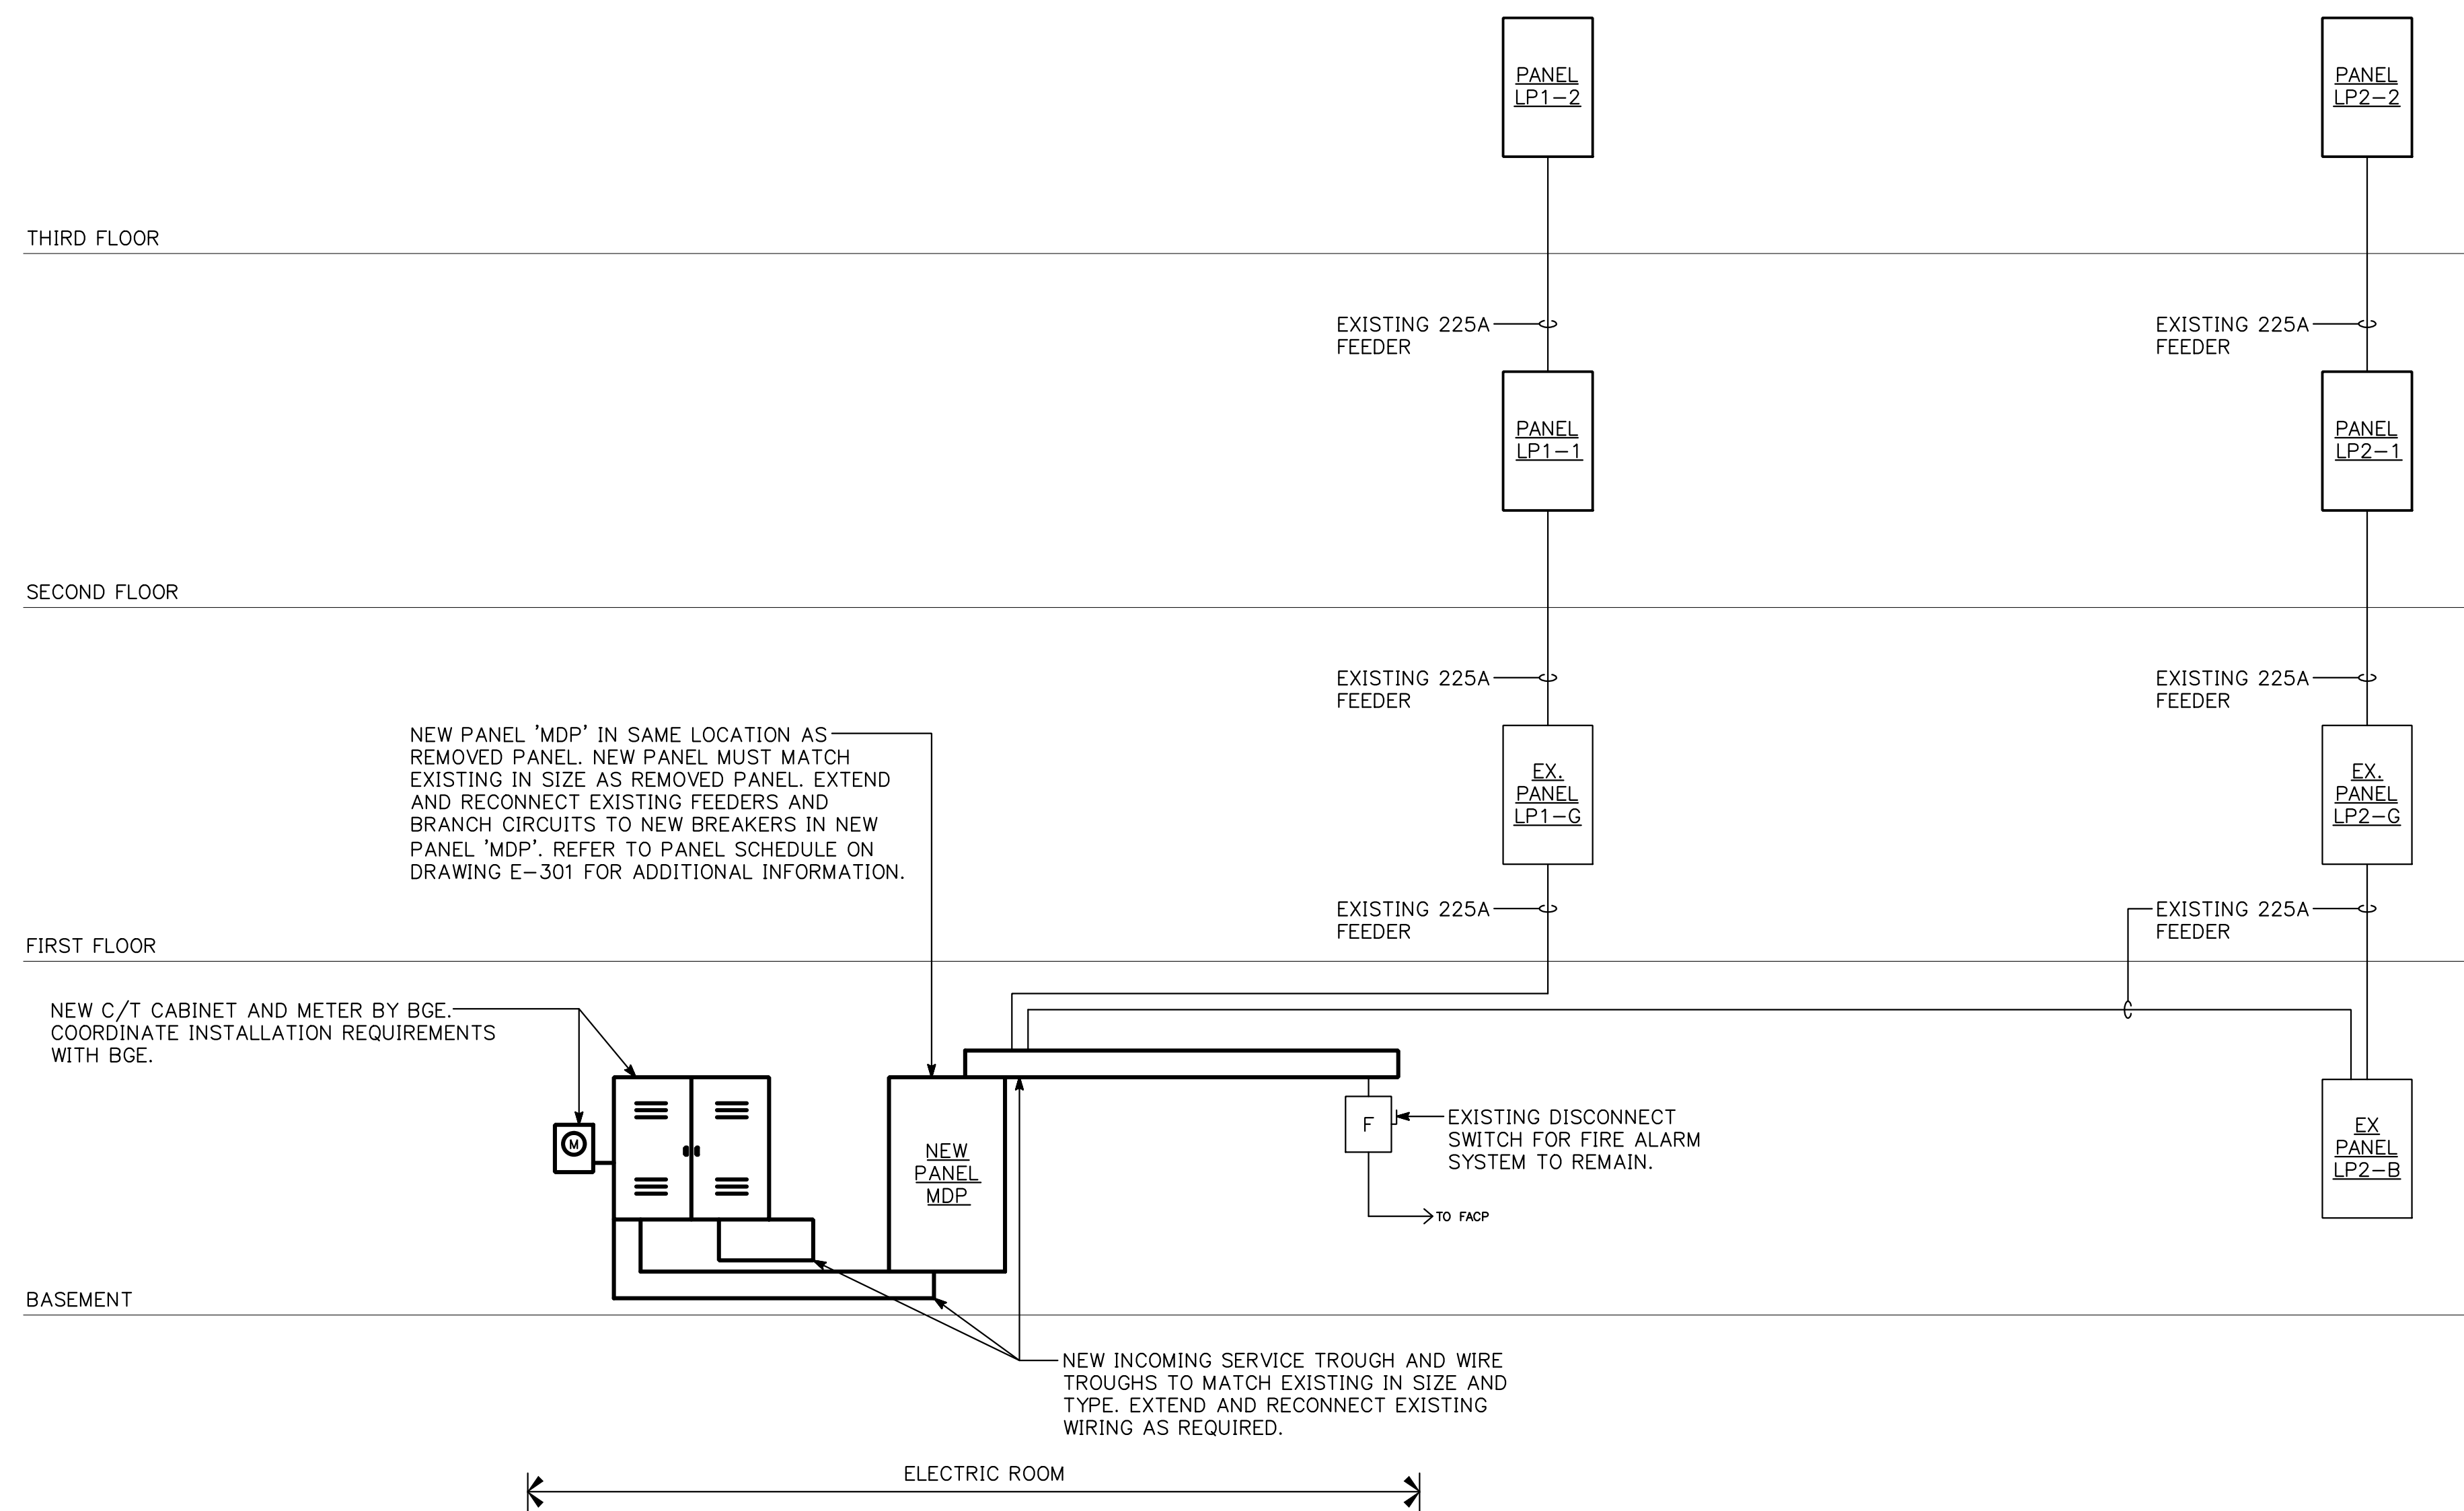

**POWER RISER DIAGRAM - NEW WORK**

NO SCALE



810 Light Street Baltimore, Maryland 21230

Structural  
**Skarda & Associates, Inc.**  
 2439 North Charles Street  
 Baltimore, Maryland 21218

Mechanical, Electrical & Plumbing  
**JennERIK Engineering, Inc.**  
 1700 Beason Street  
 Baltimore, Maryland 21230

Professional Certification: I certify that these documents were prepared or approved by me, and that I am a duly licensed engineer under the laws of the State of Maryland. License No: 18968, Expiration Date: 3/4/2015.

NO	DATE	DESCRIPTION
1	06/17/13	PERMIT

REVISIONS

**NOTRE DAME PREP CONVENT RENOVATION**

815 HAMPTON LANE TOWSON, MD 21286

**POWER RISER DIAGRAMS**

PROJECT NO 13007-00	DWG NO <b>E-201</b>
DATE 06/17/13	