


DRAWING NOTES (APPLY TO DRAWING E-101 WHERE INDICATED):

1. CONNECT ALL EM & EX FIXTURES AHEAD OF LOCAL SWITCHING.
2. ALL FIXTURE LABELED 'NL' ARE TO BE CONNECTED AHEAD OF LOCAL SWITCHING.
3. CLEAN AND RELAMP ALL EXISTING FIXTURES TO REMAIN.
4. REFER TO THE EQUIPMENT CONNECTION SCHEDULE ON SHEET E-001 FOR INFORMATION REGARDING MECHANICAL EQUIPMENT.


SPECIFIC NOTES (APPLY TO DRAWING E-101 WHERE INDICATED):

- 1 EXISTING PANEL LP1-G. REFER TO RISER DIAGRAM ON SHEET E-601 FOR DETAILS.
- 2 EXISTING PANEL LP2-G. REFER TO RISER DIAGRAM ON SHEET E-601 FOR DETAILS.
- 3 CONNECTION FOR DISHWASHER.
- 4 CONNECTION FOR GARBAGE DISPOSAL.
- 5 CONNECTION FOR COFFEE MACHINE.
- 6 CONNECTION FOR MICROWAVE.
- 7 CONNECTION FOR ELECTRIC RANGE.
- 8 CONNECTION FOR REFRIGERATOR.
- 9 CONNECT TO EXISTING CIRCUIT SERVING THIS AREA.
- 10 RELOCATE EXISTING CONTROLS SERVING EXISTING EXTERIOR FIXTURES TO REMAIN TO THIS LOCATION. PROVIDE NEW BOX, COVER PLATE AND SWITCHES.


- 11 CONNECT TO EXISTING PA SYSTEM.
- 12 CONNECTION FOR MOTORIZED SCREEN.
- 13 CONNECTION FOR PROJECTOR.
- 14 RECEPTACLE SHALL BE MOUNTED AT 44" AWAY FROM FLOOR TO TOP OF DEVICE.
- 15 LIGHTING IN CORRIDOR SHALL BE CONTROLLED VIA TIME CLOCK. OWNER SHALL CLARIFY WHAT TIME SHALL THE LIGHTING SHALL BE TURNED OFF/ON. NIGHT LIGHTS (INDICATED WITH AN 'NL' SUBSCRIPT) SHALL REMAIN ON 24/7.
- 16 IF CIRCUITS SERVING THE BOARD ROOM AREA ARE MADE SPARE UNDER DEMOLITION, CONNECT NEW WORK TO SAID CIRCUITS - OTHERWISE CIRCUIT NEW DEVICES AS INDICATED ON PLAN.
- 17 MOUNTED HIGH RECEPTACLE FOR VANITY.

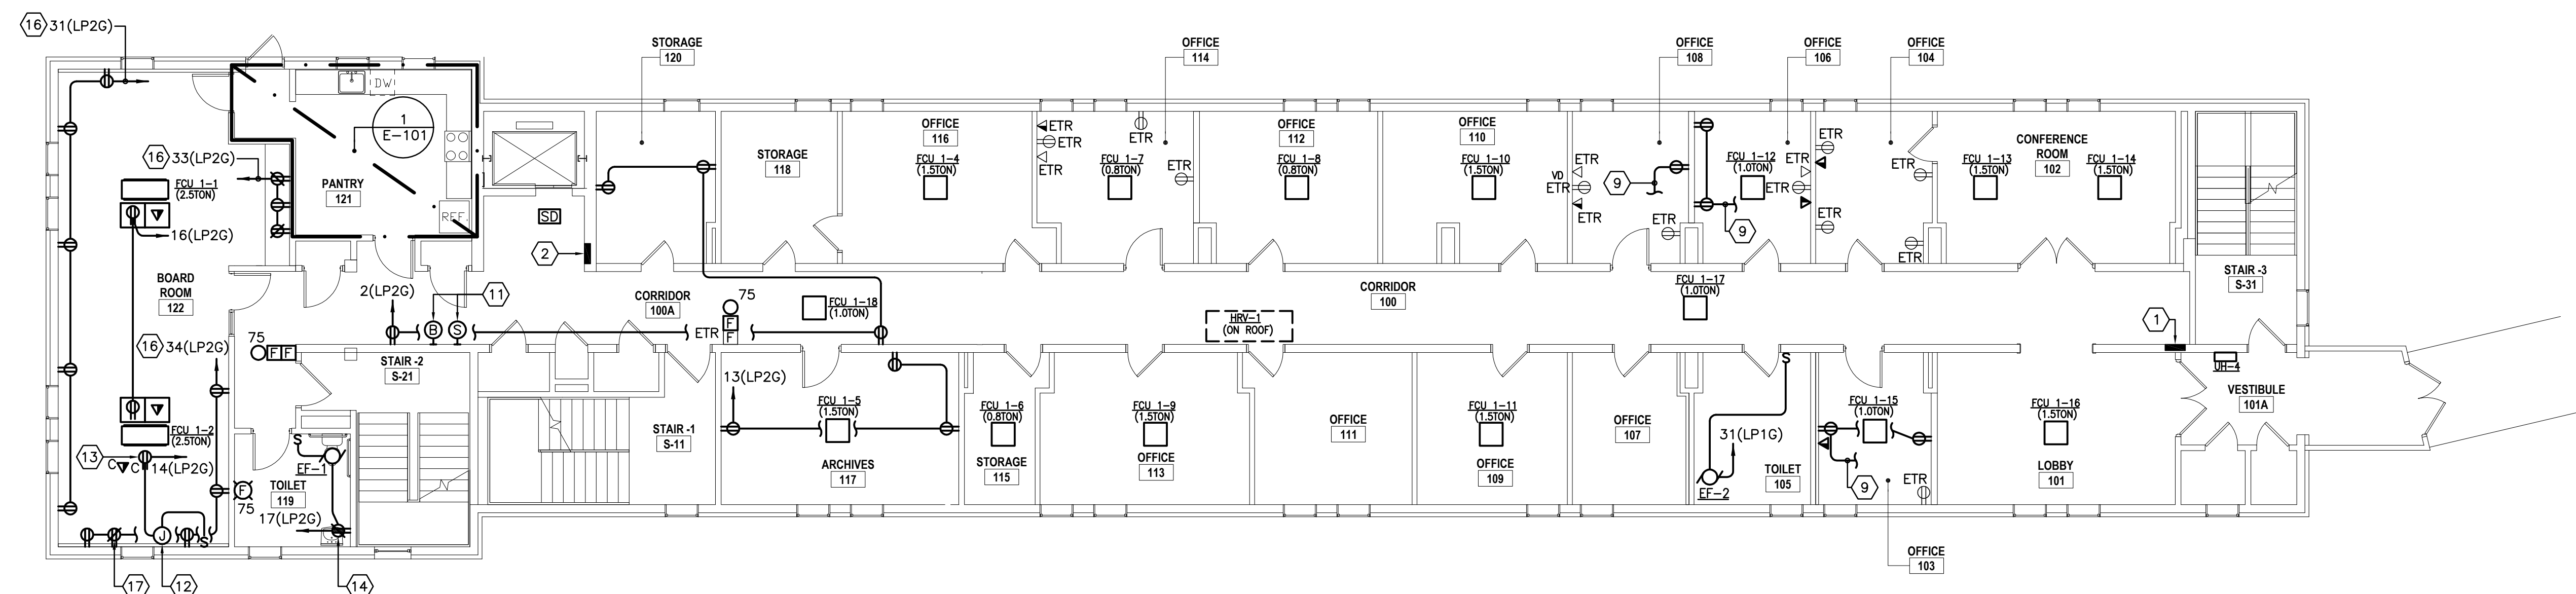


FIRST FLOOR PLAN - POWER - NEW WORK
SCALE: 1/8" = 1'-0"

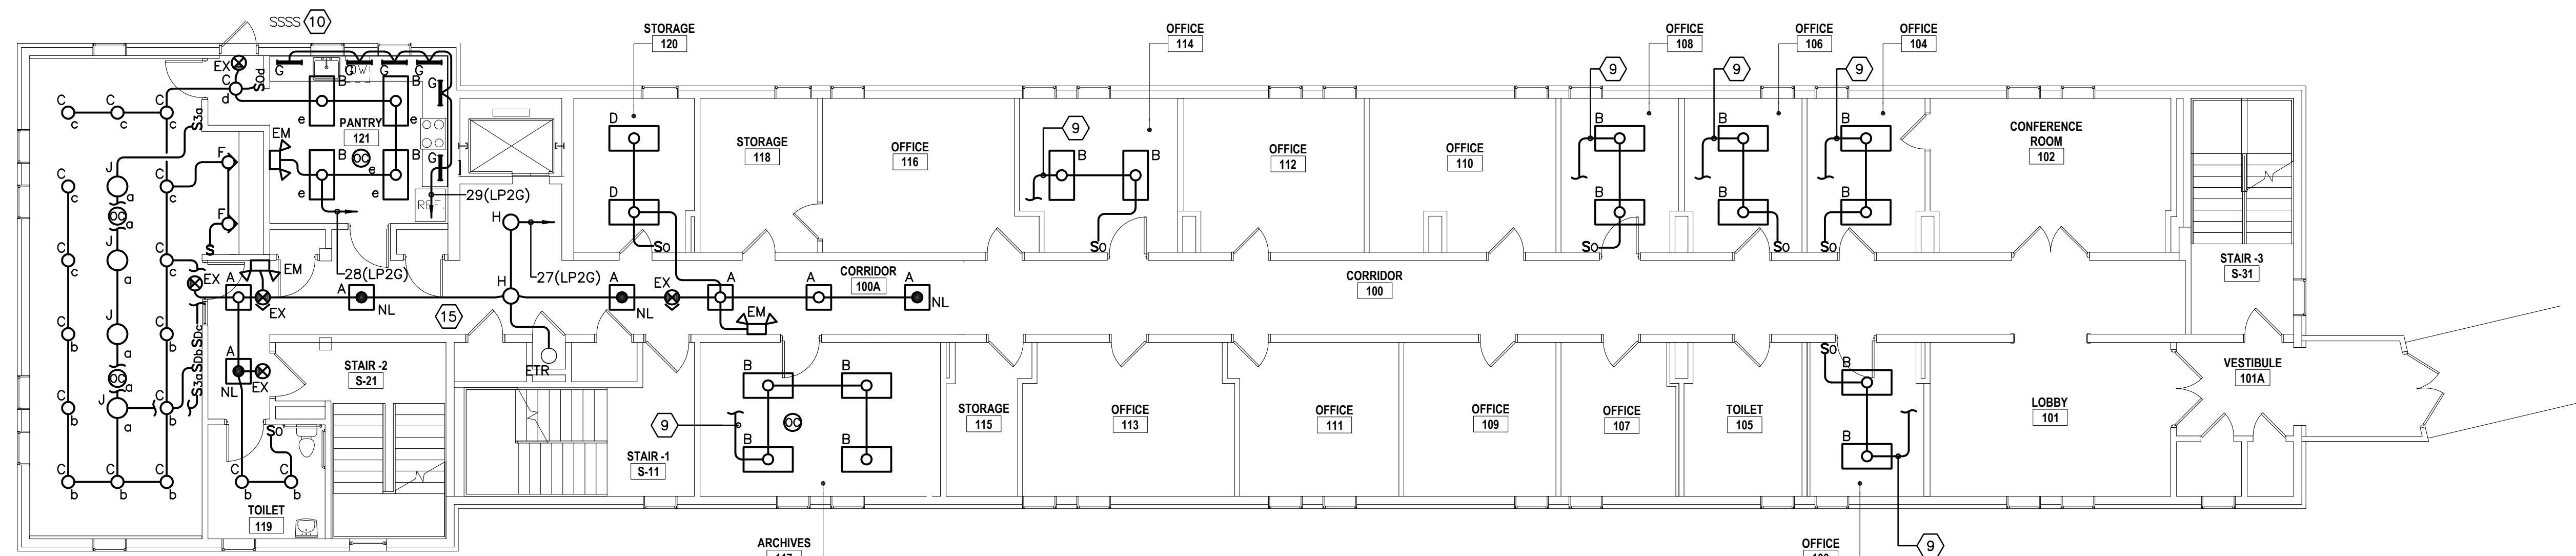

FIRST FLOOR PLAN - LIGHTING - NEW WORK
SCALE: 1/8" = 1'-0"

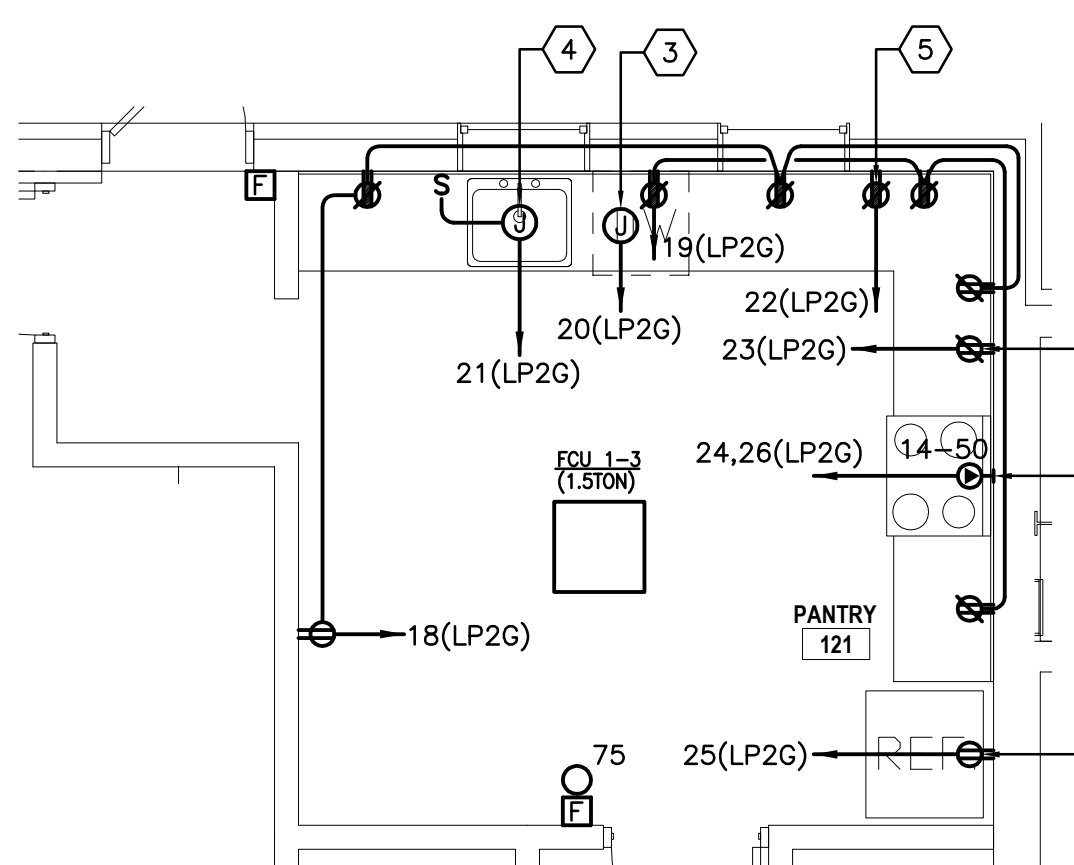

1 PART PLAN - PANTRY 121 - POWER
SCALE: 1/4" = 1'-0"

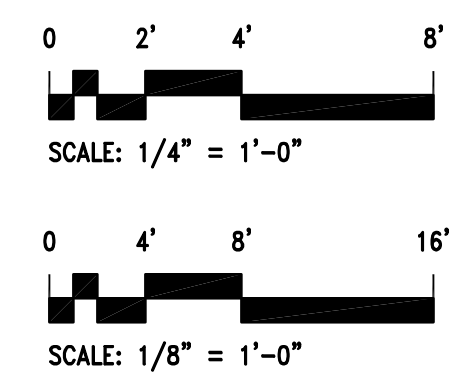

810 Light Street Baltimore, Md 21230

Professional Certification: I certify that these documents were prepared or approved by me, and that I am a duly licensed engineer under the laws of the State of Maryland.
License No: 19926 Expiration Date: 3/4/2015

NO	DATE	DESCRIPTION

REVISIONS

**NOTRE DAME
PREP CONVENT
RENOVATION**

**FLOOR PLAN -
ELECTRICAL -
NEW WORK**

PROJ. NO.: 13007-00	DWG NO.
DRAWN BY: TED	E-101
DATE: 08-06-13	