
 




810 Light Street Baltimore, Md 21230

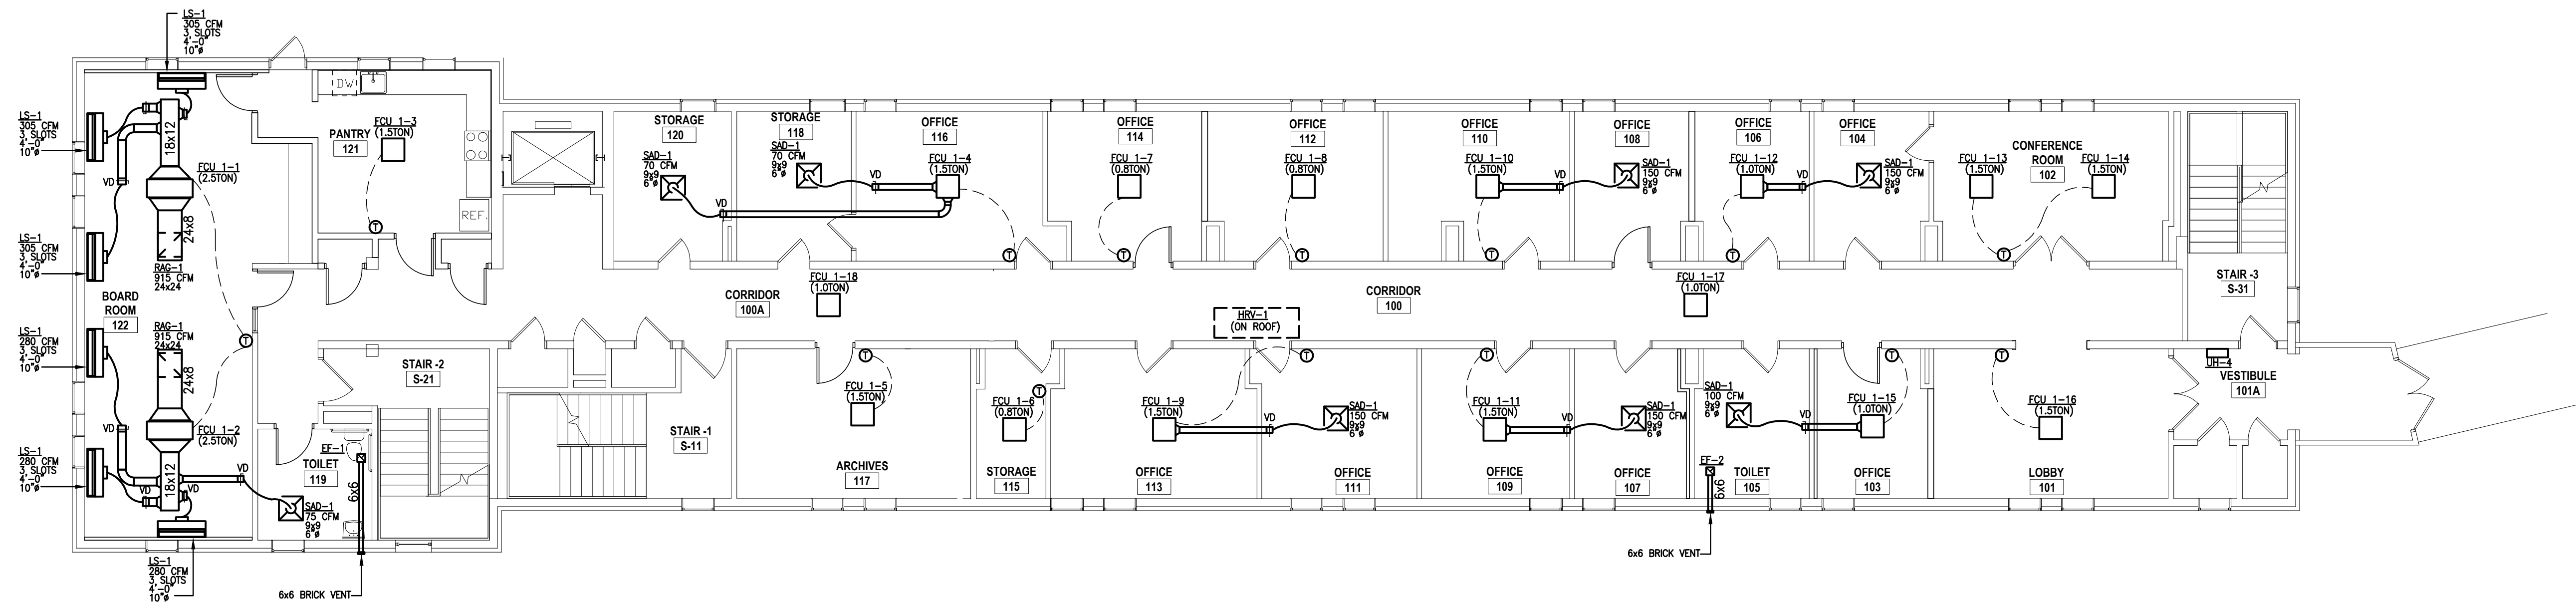

FIRST FLOOR PLAN - HVAC - NEW WORK
SCALE: 1/8"=1'-0"



Professional Certification: I certify that these documents were prepared or approved by me, and that I am a duly licensed engineer under the laws of the State of Maryland. License No: 19989 Expiration Date: 3/4/2015


NO	DATE	DESCRIPTION
----	------	-------------

REVISIONS

NOTRE DAME
PREP CONVENT
RENOVATION

FIRST
FLOOR
PLAN - HVAC
NEW WORK

PROJ. NO.: 13007-00	DWG NO.
DRAWN BY: FDD	M-101
DATE: 08-06-13	

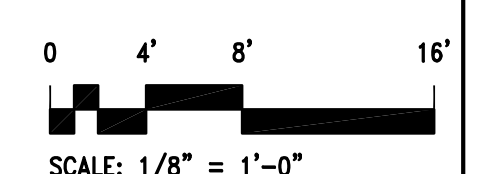

SCALE: 1/8" = 1'-0"