

1

2

3

4


5

D


C

B

A

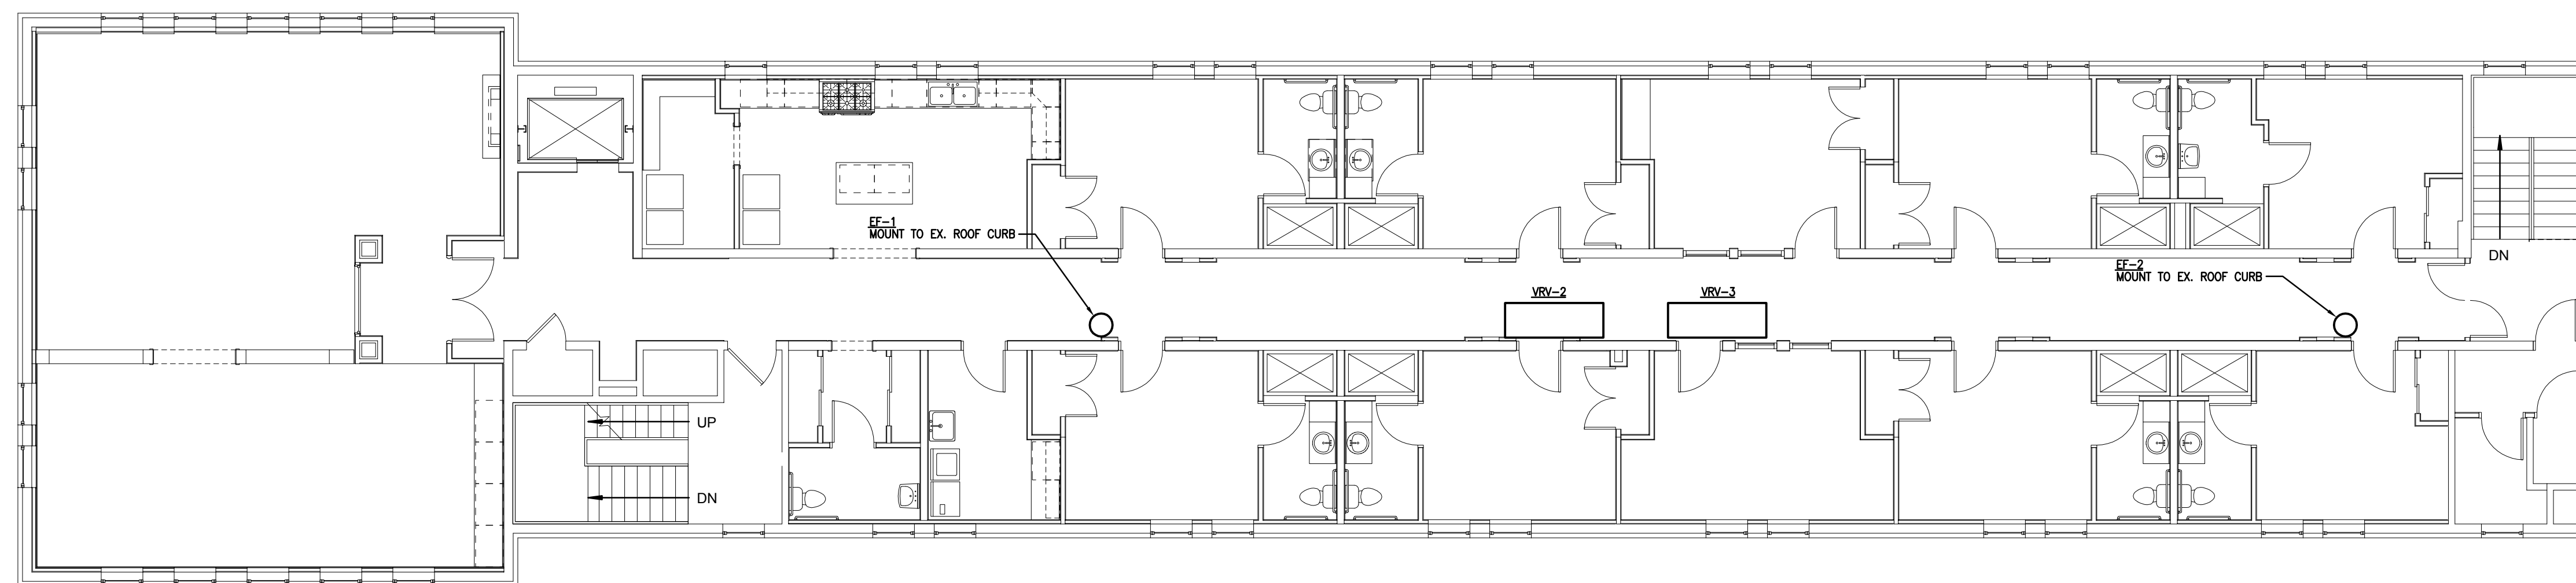

ROOF PLAN - HVAC - NEW WORK
 SCALE: 1/8"=1'-0"

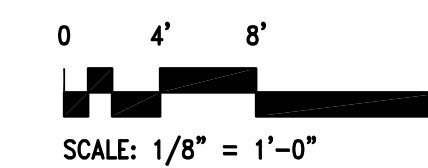

810 Light Street Baltimore, Maryland 21230

NO	DATE	DESCRIPTION

REVISIONS

**NOTRE DAME
 PREP CONVENT
 RENOVATION**

815 Hampton Lane
 Towson, MD 21286

**ROOF
 PLAN - HVAC
 NEW WORK**

PROJECT NO 13007-00	DWG NO
DRAWN BY FDD	M-102
DATE 06/13/13	