

1

2

3

4


5

D


C

B



A

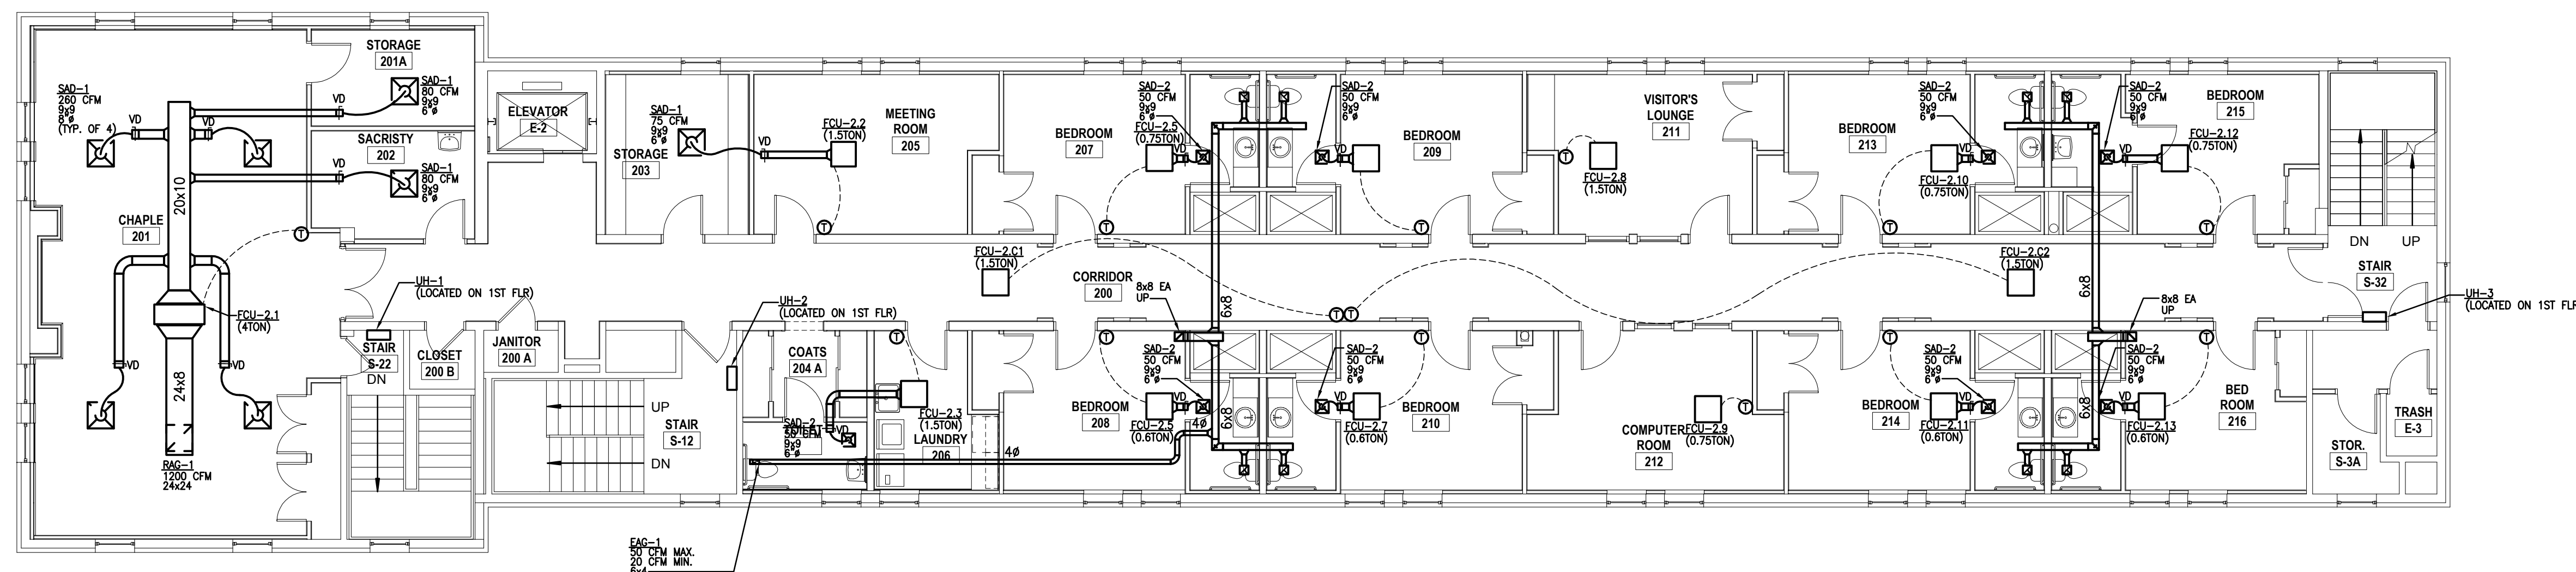

SECOND FLOOR PLAN - HVAC - NEW WORK
SCALE: 1/8"=1'-0"

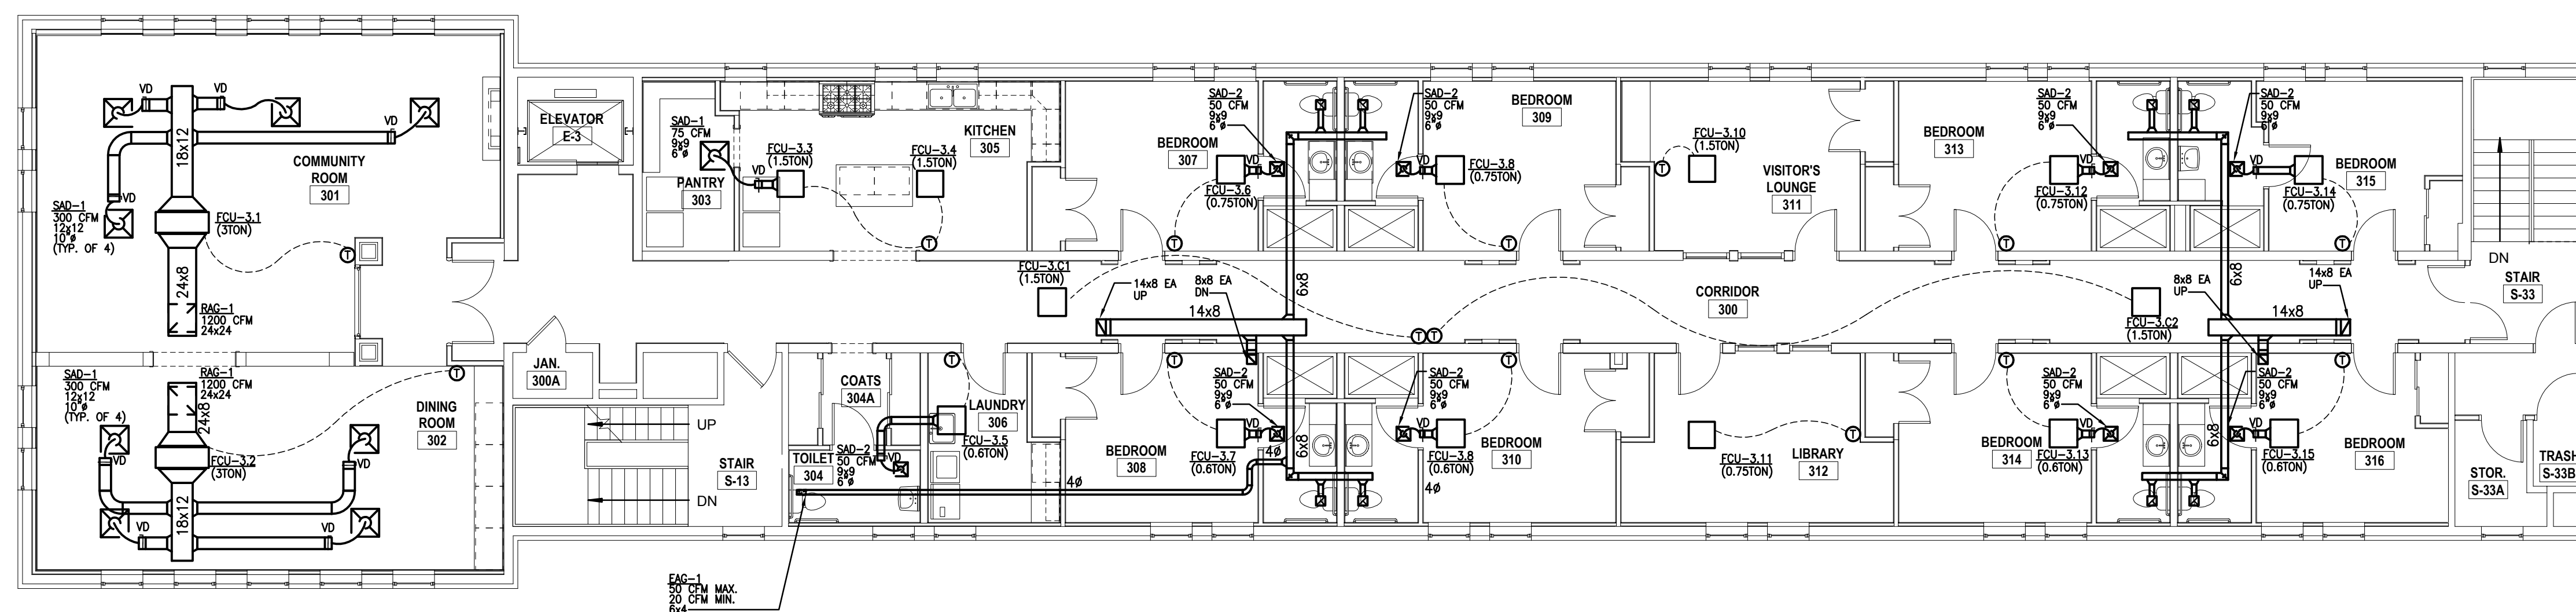

THIRD FLOOR PLAN - HVAC - NEW WORK
SCALE: 1/8"=1'-0"

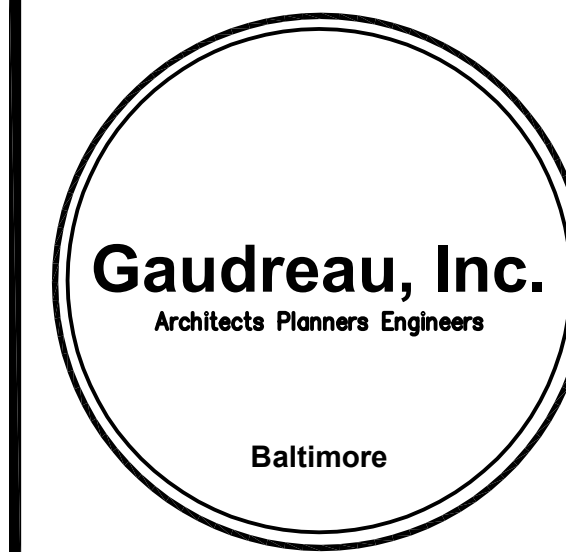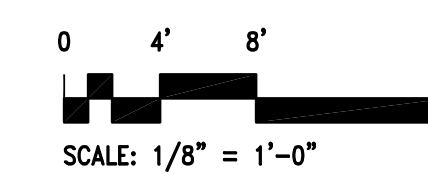

810 Light Street Baltimore, Maryland 21230

| NO | DATE | DESCRIPTION |
|----|------|-------------|
| | | |
| | | |
| | | |
| | | |

REVISIONS

**NOTRE DAME
PREP CONVENT
RENOVATION**

815 Hampton Lane
Towson, MD 21286

**SECOND AND
THIRD FLOOR
PLAN - HVAC
NEW WORK**

| | |
|------------------------|------------------|
| PROJECT NO 13007-00 | DWG NO M-101 |
| DRAWN BY FDD | DATE 06/13/13 |

1

2

3

4


5

D



C

B

A

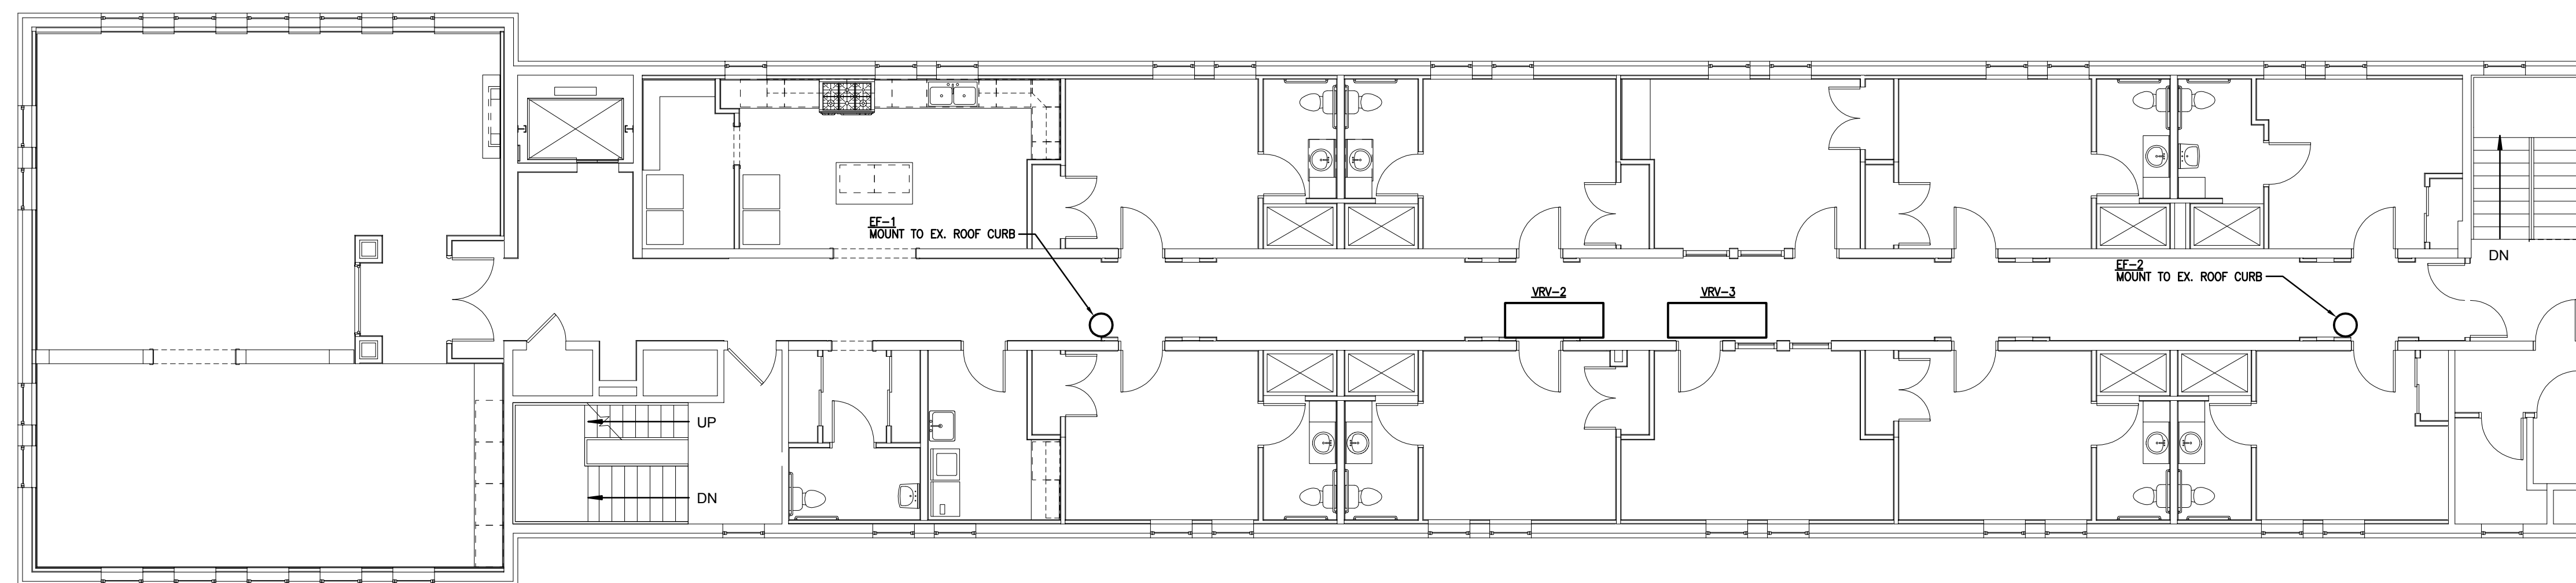

ROOF PLAN - HVAC - NEW WORK
 SCALE: 1/8"=1'-0"

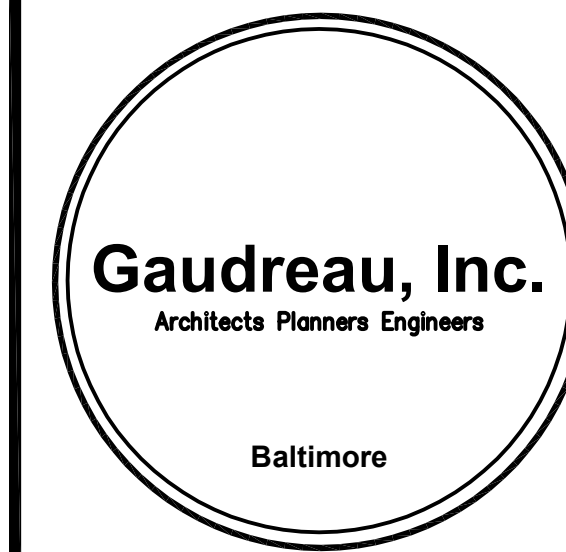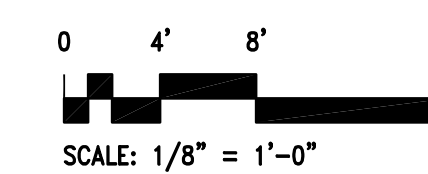

810 Light Street Baltimore, Maryland 21230

| NO | DATE | DESCRIPTION |
|----|------|-------------|
| | | |
| | | |
| | | |

REVISIONS

**NOTRE DAME
 PREP CONVENT
 RENOVATION**

815 Hampton Lane
 Towson, MD 21286

**ROOF
 PLAN - HVAC
 NEW WORK**

| | |
|------------------------|--------------|
| PROJECT NO 13007-00 | DWG NO |
| DRAWN BY FDD | M-102 |
| DATE 06/13/13 | |