


BUILDING DRAINAGE
FIXTURE UNITS = 108
(NEW CONSTRUCTION)

SANITARY RISER DIAGRAM
SCALE: NONE

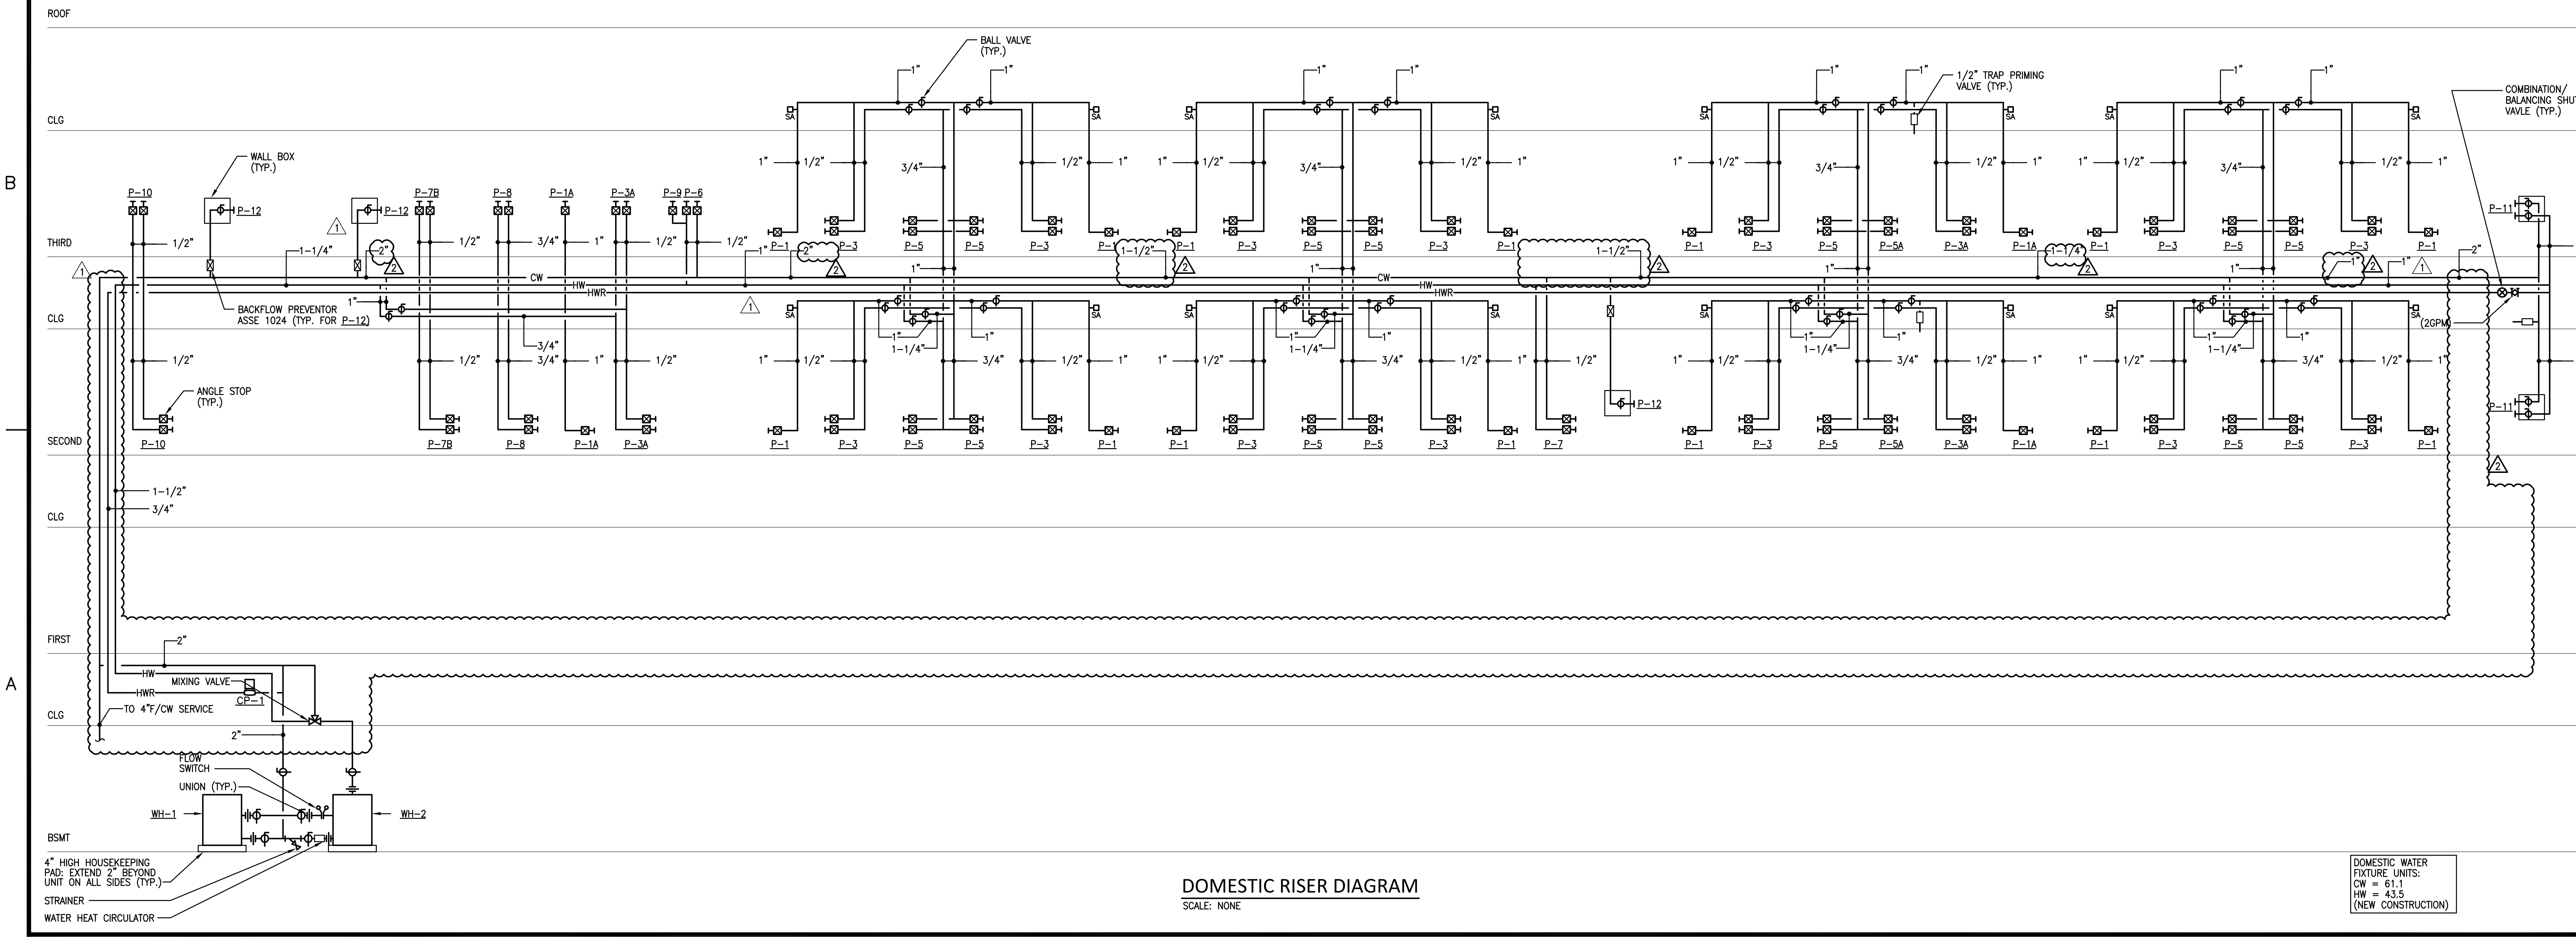

DOMESTIC WATER
FIXTURE UNITS:
CW = 61.1
HW = 43.5
(NEW CONSTRUCTION)

DOMESTIC RISER DIAGRAM
SCALE: NONE



810 Light Street Baltimore, Maryland 21230

Professional Certification: I certify that these documents were prepared or approved by me, and that I am a duly licensed engineer under the laws of the State of Maryland. License No. 19986 Expiration Date: 3/4/2015.

NO	DATE	REVISION #	DESCRIPTION
2	10/15/13	REVISION #2	
1	09/27/13	REVISION #1	

REVISIONS

**NOTRE DAME
PREP CONVENT
RENOVATION**

815 Hampton Lane
Towson, MD 21286

**RISER
DIAGRAMS**

PROJECT NO 13007-00	DWG NO
DRAWN BY FDD	P-601
DATE 03/15/13	