


GROUND FLOOR TOILET ROOM - PART PLAN
SCALE: 1/8" = 1'-0"

PLUMBING FIXTURE SCHEDULE						
No.	Description	HW	CW	SAN.	Vent	Remarks
P-1	Water Closet	----	1"	4"	2"	
P-1A	Water Closet	----	1"	4"	2"	Handicapped
P-2	Urinal	----	3/4"	2"	1 1/2"	
P-3	Lavatory	1/2"	1/2"	1 1/2"	1 1/2"	Handicapped
P-4	Service Sink	1/2"	1/2"	1 1/2"	1 1/2"	
P-5	ELECTRIC WATER COOLER	----	1/2"	1 1/2"	1 1/2"	

AIR DEVICE SCHEDULE					
No.	Description	CFM	neck size	Blow	Remarks
1	Exhaust	200	10x10	----	
2	Exhaust	60	6x6	----	

MECHANICAL LEGEND		
Symbol	Abbreviation	Description
---	CW	Cold Water
----	HW	Hot Water
---	SAN	Sanitary
---	V	Vent
---	VD	Volume damper
☐, ☐	RA DN RA UP	Return Air Dn & Return Air Up
☐, ☐	SA DN SA UP	Supply Air Dn & Supply Air Up
☐, ☐	EXH UP EXH DN	Exhaust air up & Exhaust air dn
---		Backflow preventer
---		Union
---		Gate valve
---		Pressure reducing valve
---		Globe valve
---	SW	Storm Water
---	F	Fire Line
---	CD	Condensate Line
---		Fire Damper
---	HWR	Hot water RETURN
---	G	Gas Line
---		Solenoid valve
---		Flow Switch
---	Z	Check Valve
---	VTR	Vent thru roof
---	SP	Sprinkler line
---	D	Drain line
---	FD	Floor drain
---	RD	Roof drain
---	HWS	HOT WATER SUPPLY
---	HB	HOSE BIBB

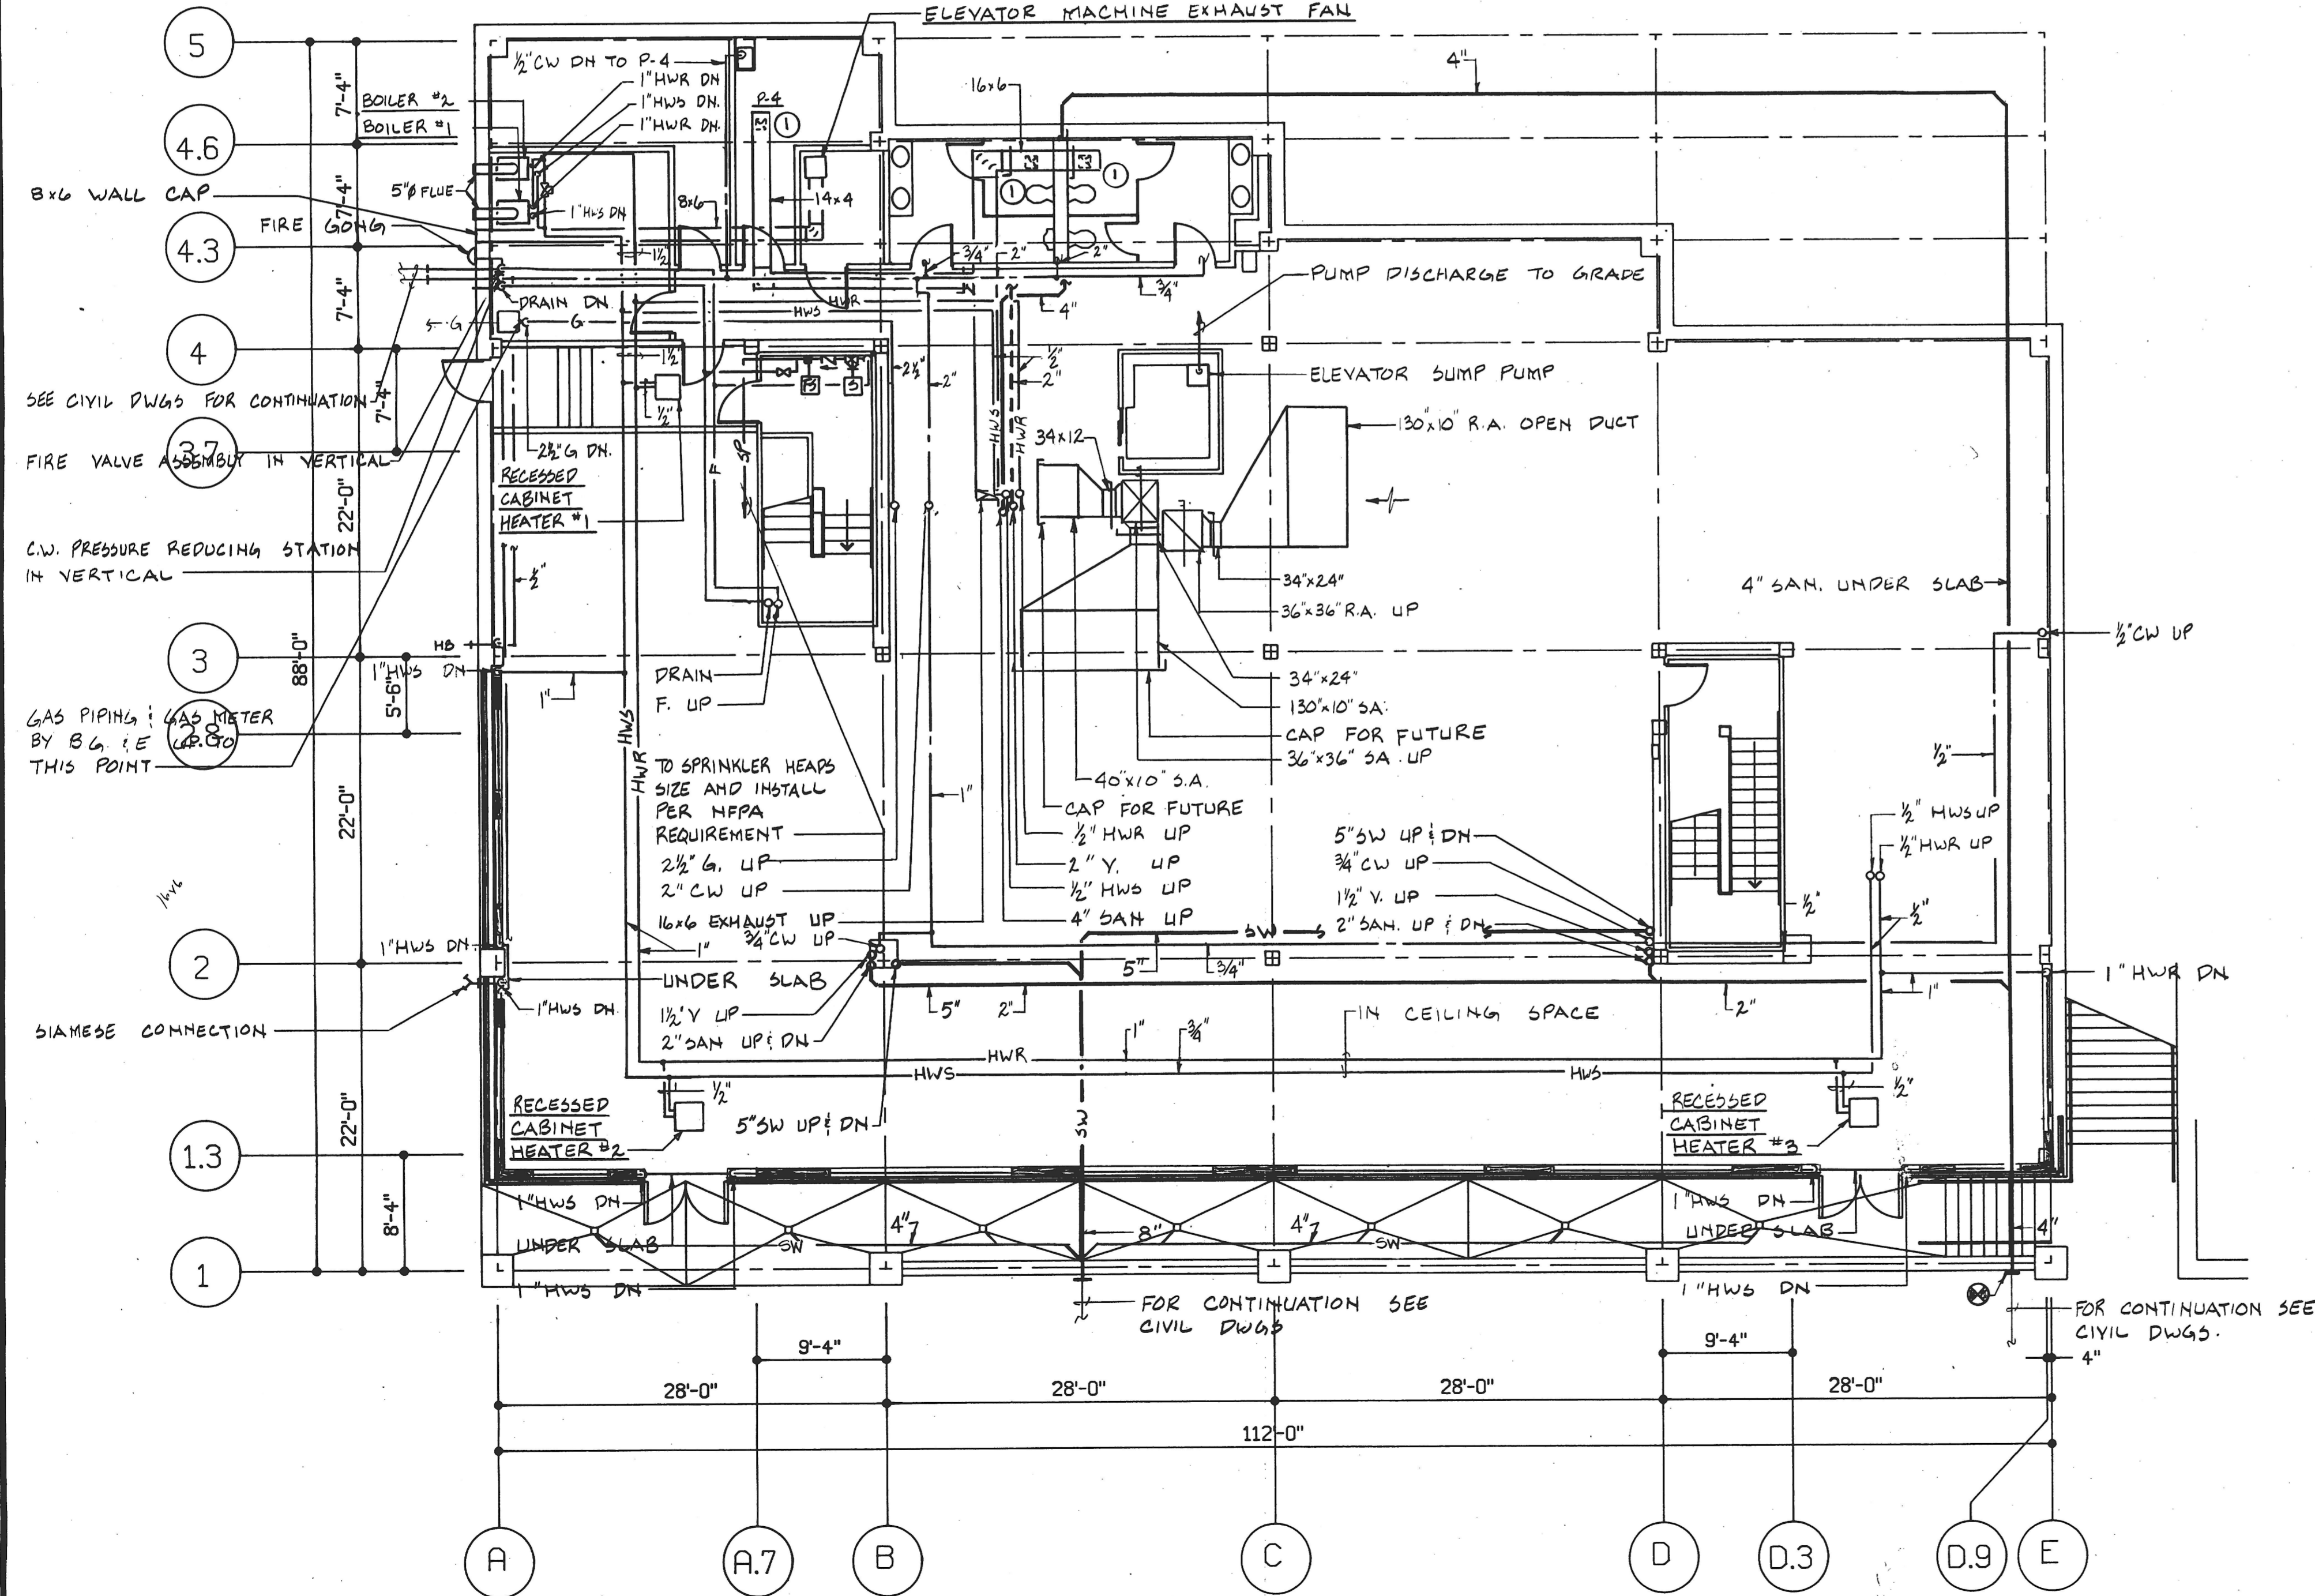

MECHANICAL GROUND FLOOR PLAN
SCALE: 1/8" = 1'-0"

KIBART, INC.
MECHANICAL ELECTRICAL ENGINEERS
698 FAIRMOUNT AVENUE
TOWSON, MARYLAND 21204

(301) 494-1111

LPJ, INC.
STRUCTURAL ENGINEERS
16 WEST 25th STREET
BALTIMORE, MARYLAND 21218

(301) 366-7800

Lapicki-Smith
ASSOCIATES, P.A.

THE PROFESSIONAL CENTER
211 WEST FAYETTE STREET
BALTIMORE, MARYLAND 21201
(301) 685-4900

project no. 86.30

1312 BELLONA AVENUE
LUTHERVILLE, MARYLAND

ZINK DEVELOPMENT COMPANY
1927 YORK ROAD
TIMONIUM, MARYLAND 21083

drawing title
GROUND FLOOR
MECHANICAL

date 1-26-87

drawing no.
M-1

M	M
W	W