



SPRINKLER ZONE VALVE ASSEMBLY DETAIL
SCALE: NONE

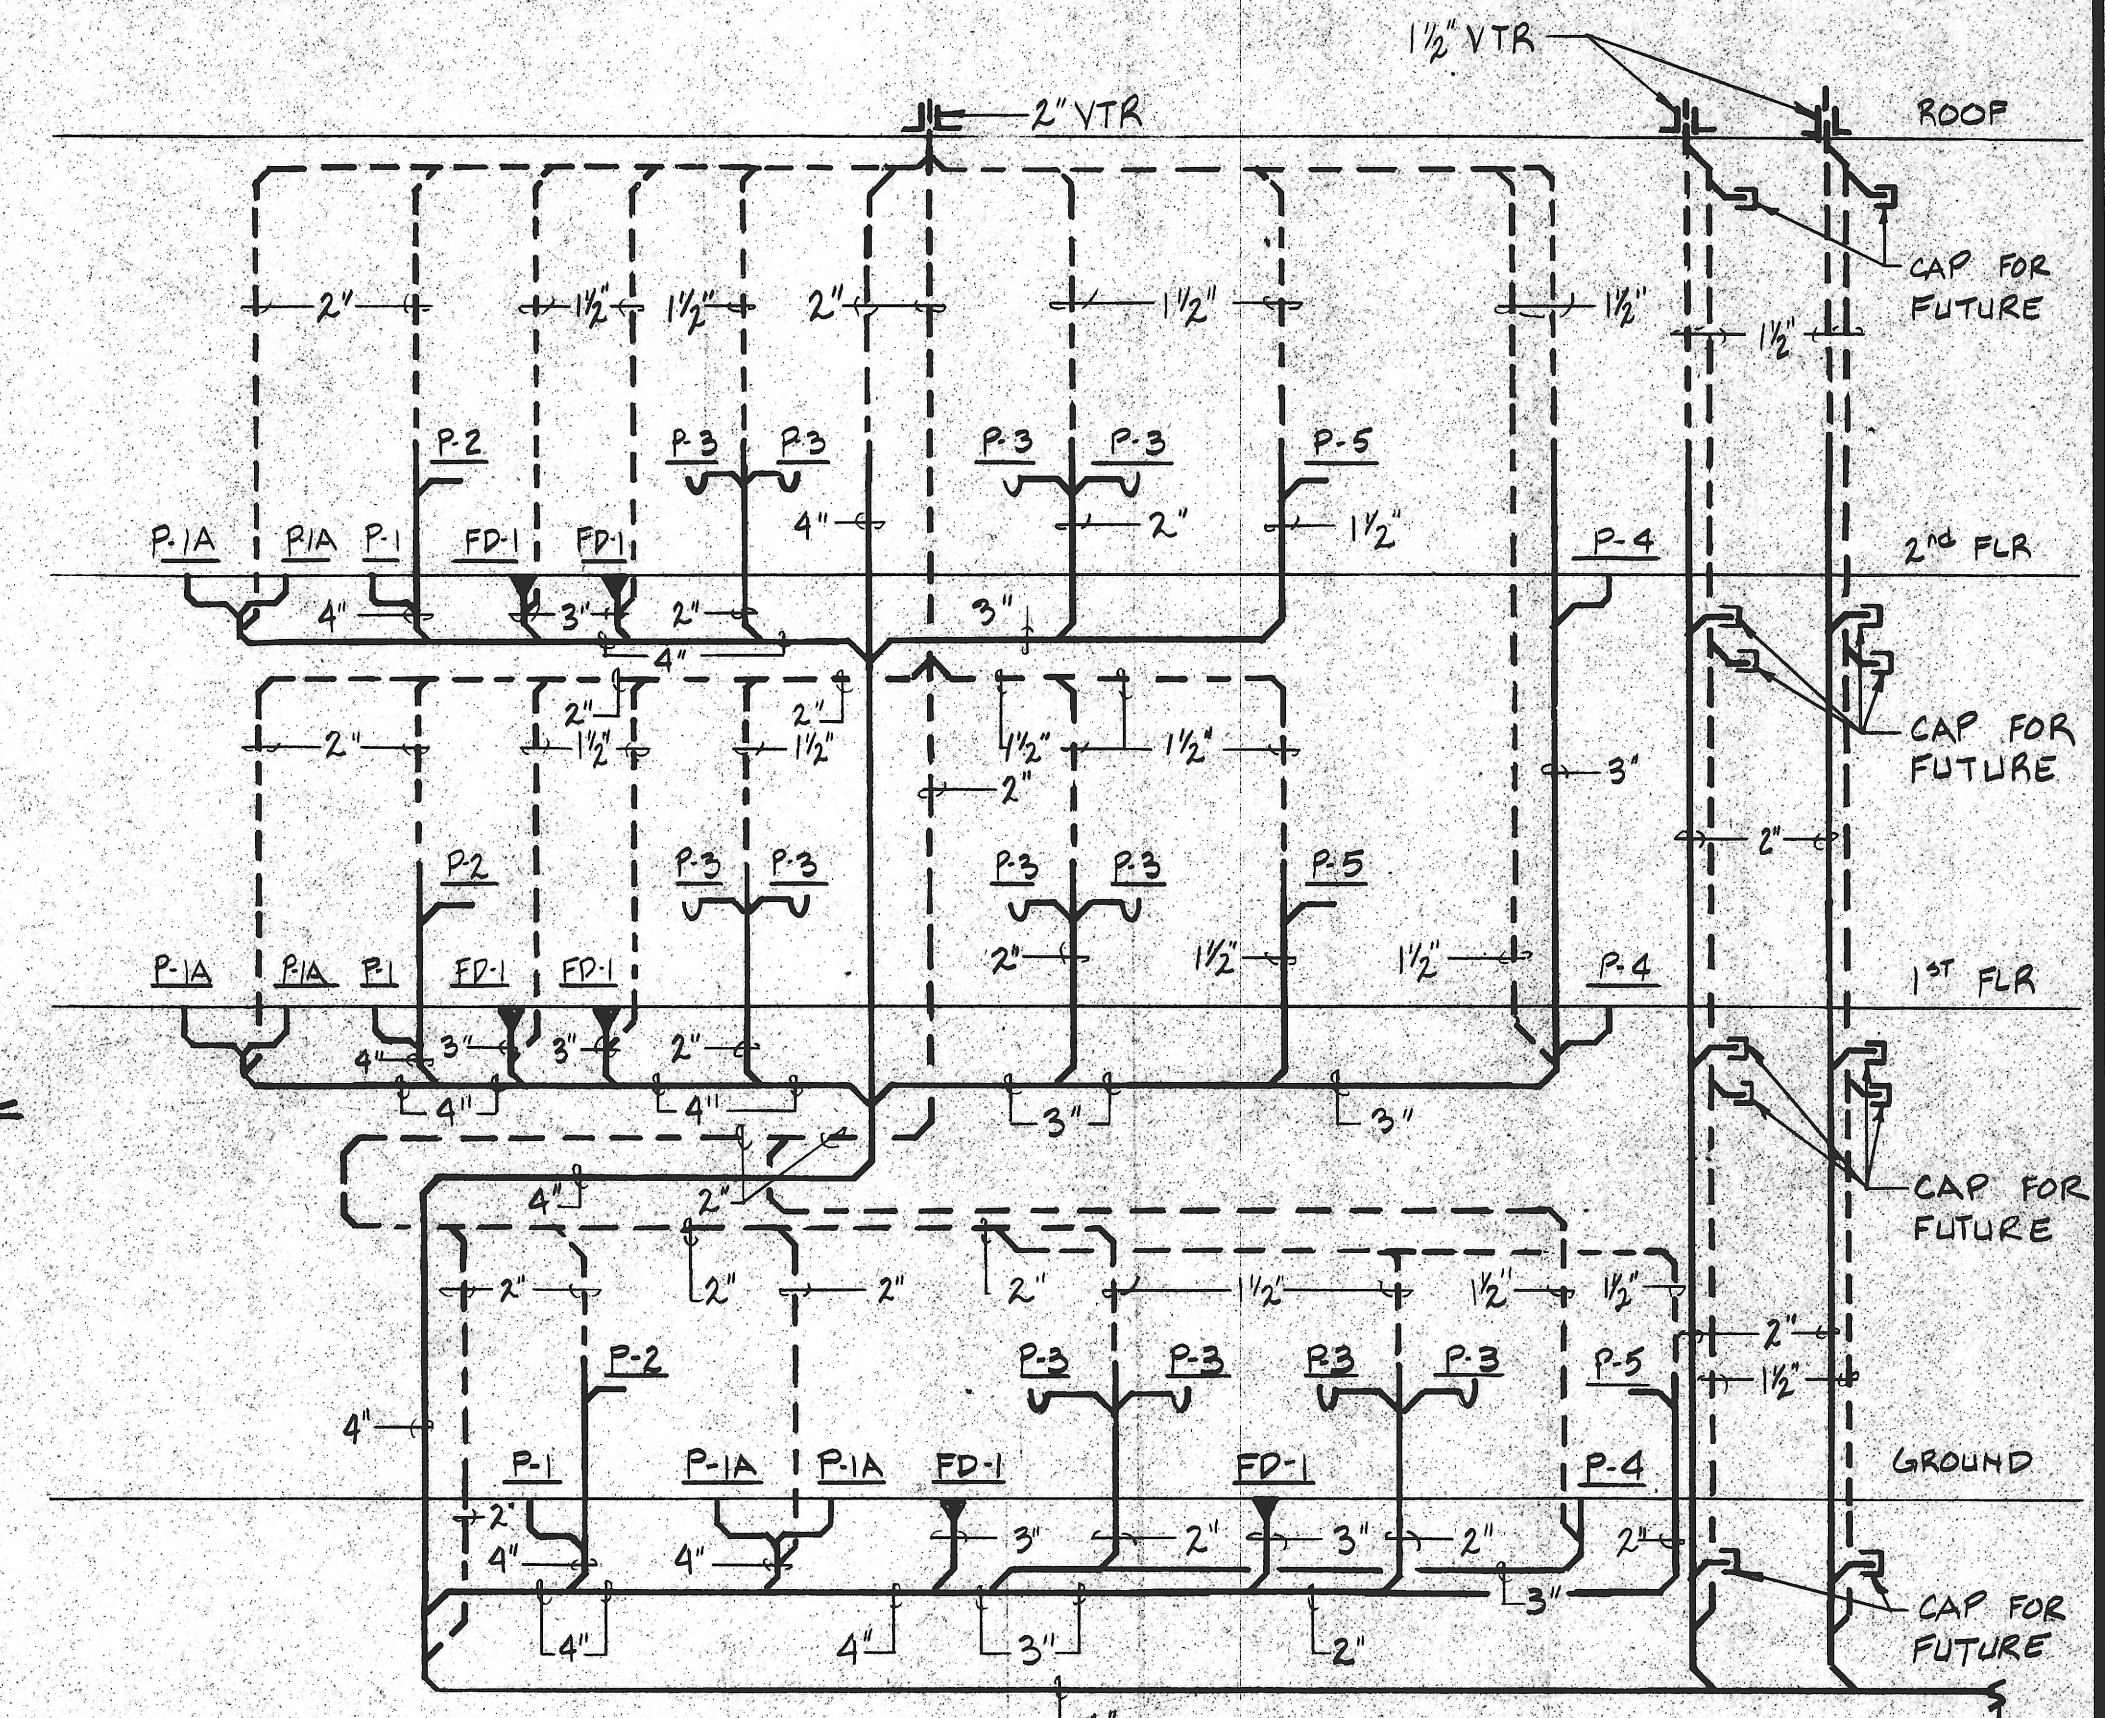

FOR CONTINUATION SEE FLOOR PLAN MP-1


SANITARY AND VENT RISER DIAGRAM
SCALE: NONE

FIRST FLOOR TOILET ROOM - PART PLAN
SCALE: 1/8" = 1'-0"

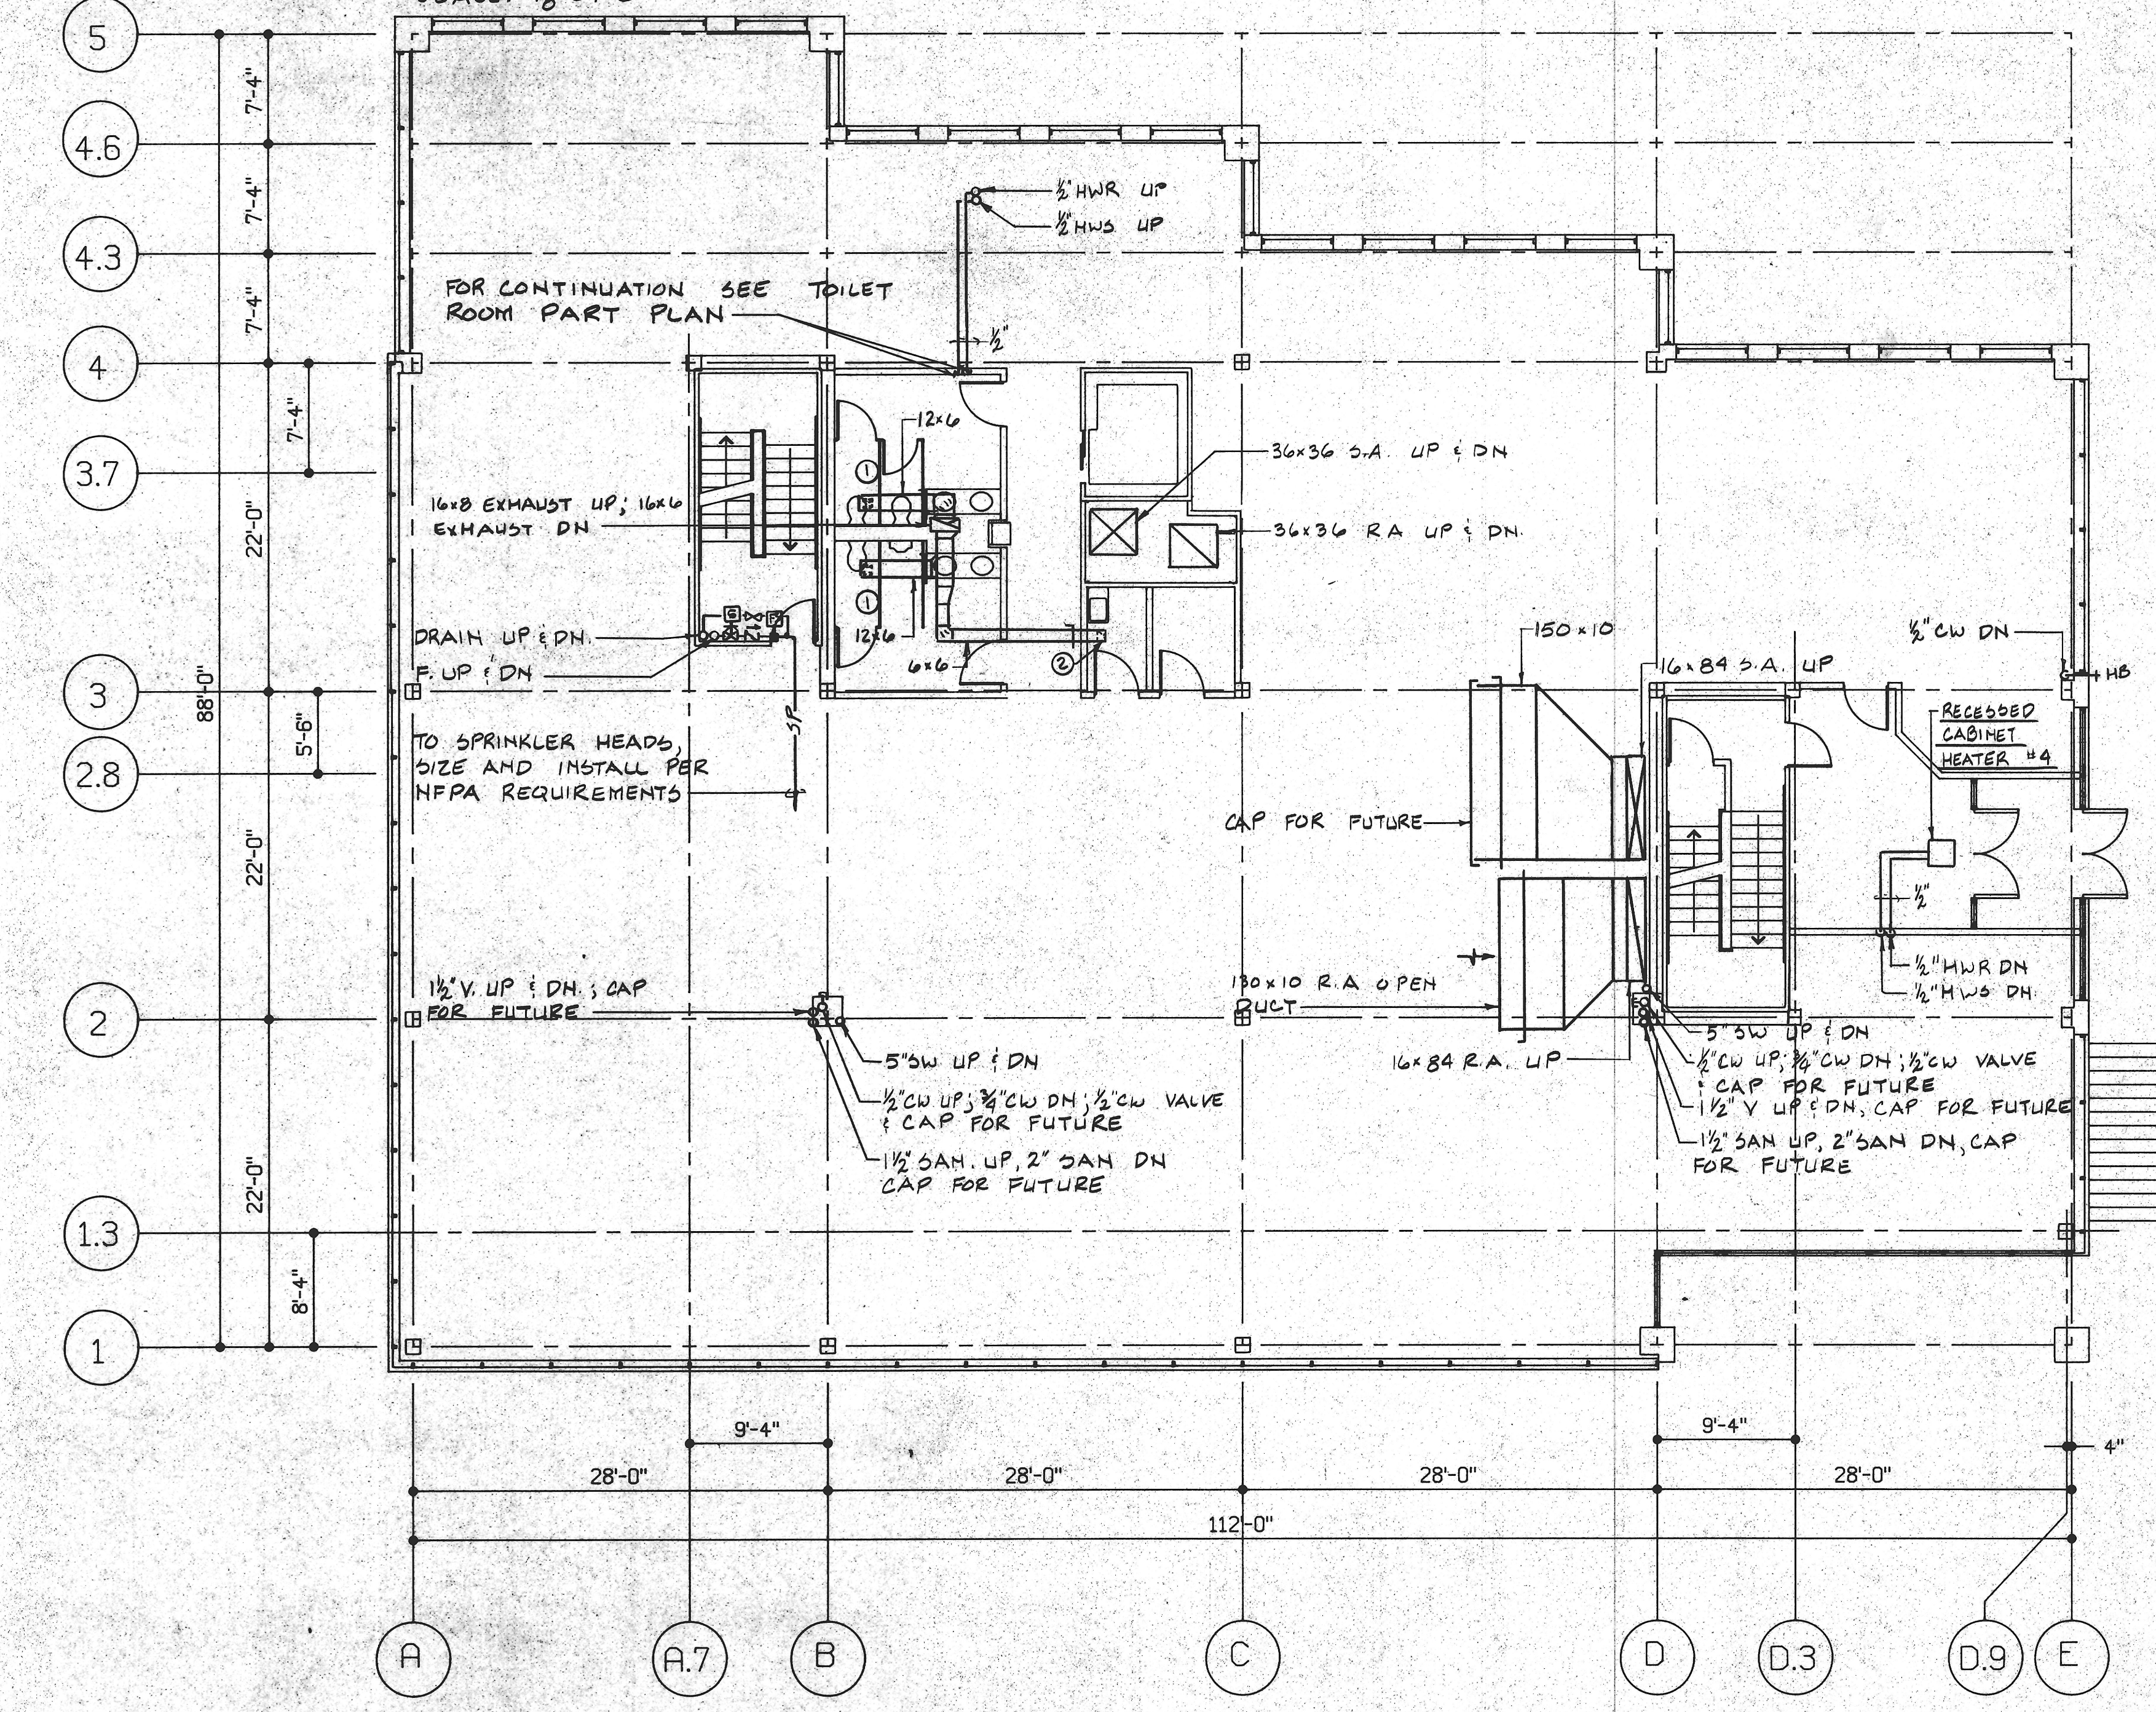


MECHANICAL FIRST FLOOR PLAN
SCALE: 1/8" = 1'-0"

FOR CONTINUATION SEE FLR. PLAN SHEET

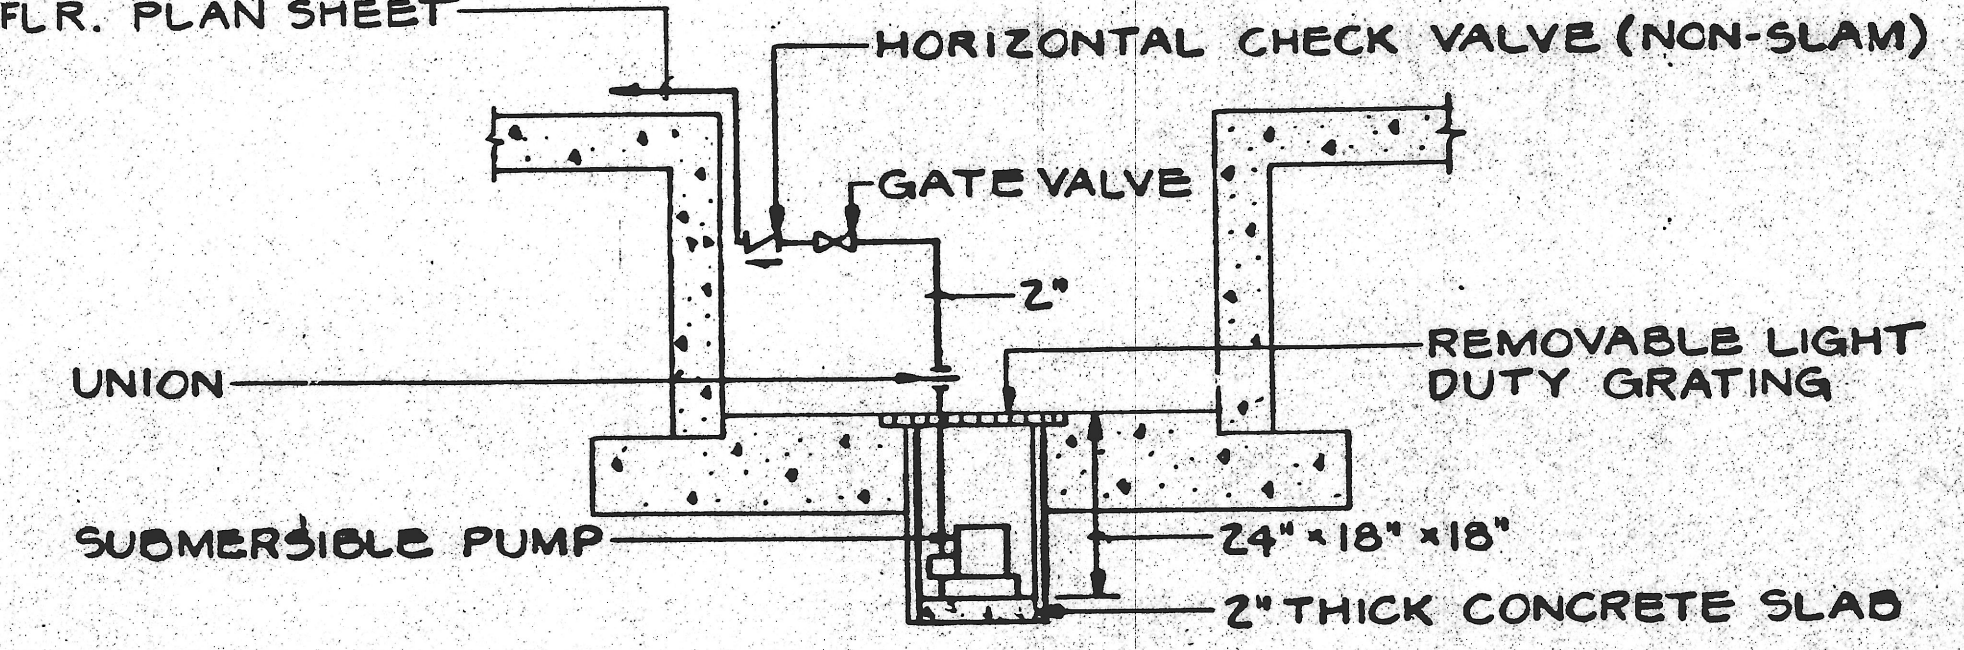

ELEVATOR SUMP PUMP DETAIL
SCALE: NONE

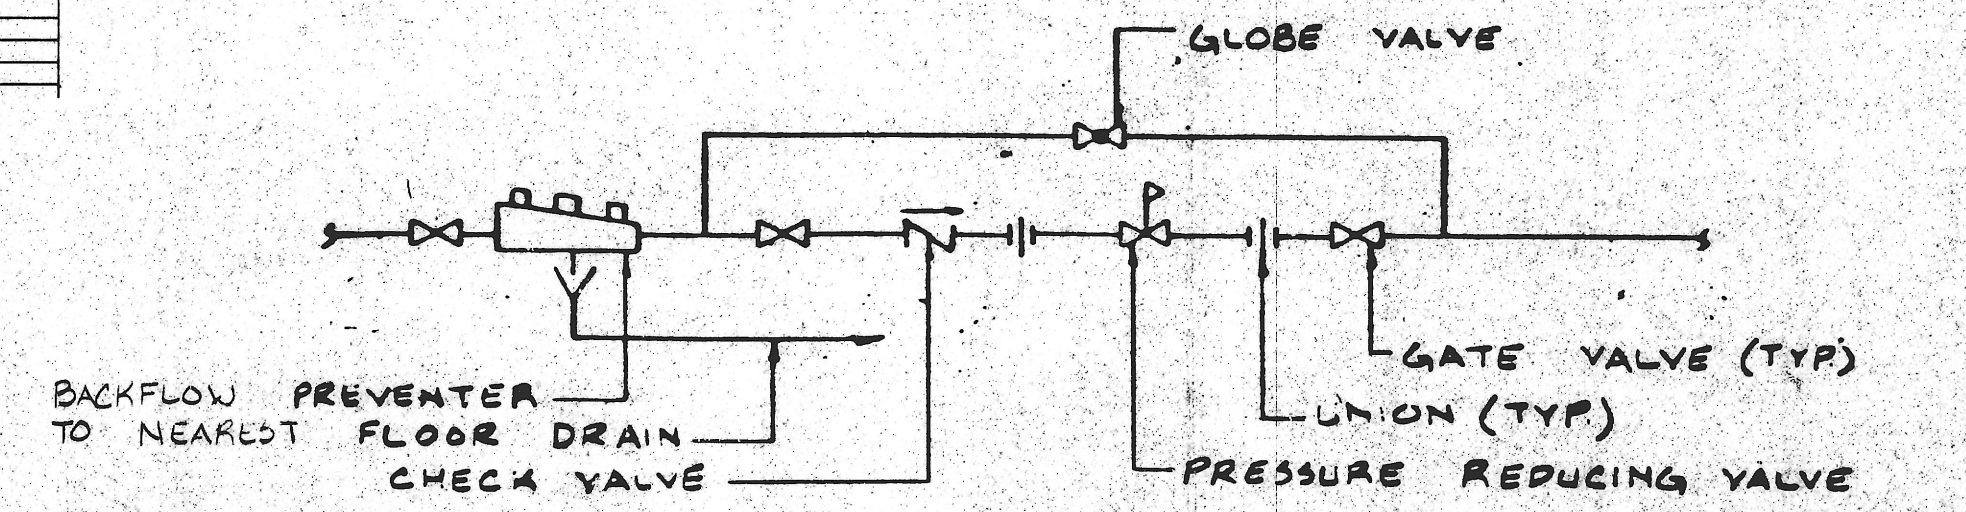

C.W. PRESSURE REDUCING STATION
NO SCALE

KIBART, INC.
MECHANICAL ELECTRICAL ENGINEERS
698 FAIRMOUNT AVENUE
TOWSON, MARYLAND 21204

(301) 494-1111

LPJ, INC.
STRUCTURAL ENGINEERS
16 WEST 25th STREET
BALTIMORE, MARYLAND 21218

(301) 366-7800

Lapicki-Smith
ASSOCIATES, P.A.

THE PROFESSIONAL CENTER
211 WEST FAYETTE STREET
BALTIMORE, MARYLAND 21201
(301) 685-4900

project no. 86.30

1312 BELLONA AVENUE
LUTHERVILLE, MARYLAND

ZINK DEVELOPMENT COMPANY
1927 YORK ROAD
TIMONIUM, MARYLAND 21093

drawing title
FIRST FLOOR MECHANICAL

date 1.26.87 drawing no. M-2

M2	M2
W2	W2